

This is a "PROVISIONAL BUILDING PLAN" approved only for the purpose of inviting objections from the general public.

DRG NO. BC-01

Checked and approved for Public Health (Internal) by the Director of Health & Family Welfare, Gurugram, Haryana. (Signature: Ramesh Kumar Bhasin, AD(HQ))
 Checked and approved for Fire (Internal) by the Chief Fire Officer, Gurugram, Haryana. (Signature: D.P. Singh, AD(HQ))
 Checked and approved for Building (Internal) by the Chief Engineer, Gurugram, Haryana. (Signature: M.A. Siddiqui, AD(HQ))

MA SD PA AFP

DLF49938

KEY PLAN

BUILDING - C



Architect
Hafeez Contractor
 29 Park Street, Bombay 400 023, Tel: 266198

RISMS ARCHITECTS

RSMS ARCHITECTS PVT. LTD.
 69, Nora Niwas, Bhawani Kunj (Behind D2), Vasant Kunj, New Delhi-110070.
 Tel.: 011-26898616, 26898617
 www.rsms-arch.com

Project: PROPOSED BUILDING PLANS OF BUILDING - B AND REVISED BUILDING PLANS OF BUILDING - C, D, E, & F IN CYBER CITY UNDER TRANSIT ORIENTED DEVELOPMENT (TOD) POLICY FOR MIX LAND USED COLONY (70% IT/ITES/430% COMMERCIAL) MEASURING 108.55922 ACRES IN SECTOR 24, 25 & 25-A, GURUGRAM MANESAR URBAN COMPLEX BEING DEVELOPED BY DLF CYBER CITY DEVELOPERS LIMITED

OWNER: DLF Cyber City Developers Ltd. 10th Floor DLF Gateway Tower, DLF Cyber City, Gurugram, Haryana Pin: 122002


DRAWING TITLE: STILT/GROUND FLOOR PLAN BLOCK-C

REVISION: JOB NO. - DRG NO. BC-01 NORTH -

SCALE: 1:100 DATE: 01-04-2021

FILE: DEALT BY: CHECKED BY: APPROVED BY:

ARCHITECT'S SEAL & SIGNATURE: OWNER'S SEAL & SIGNATURE:

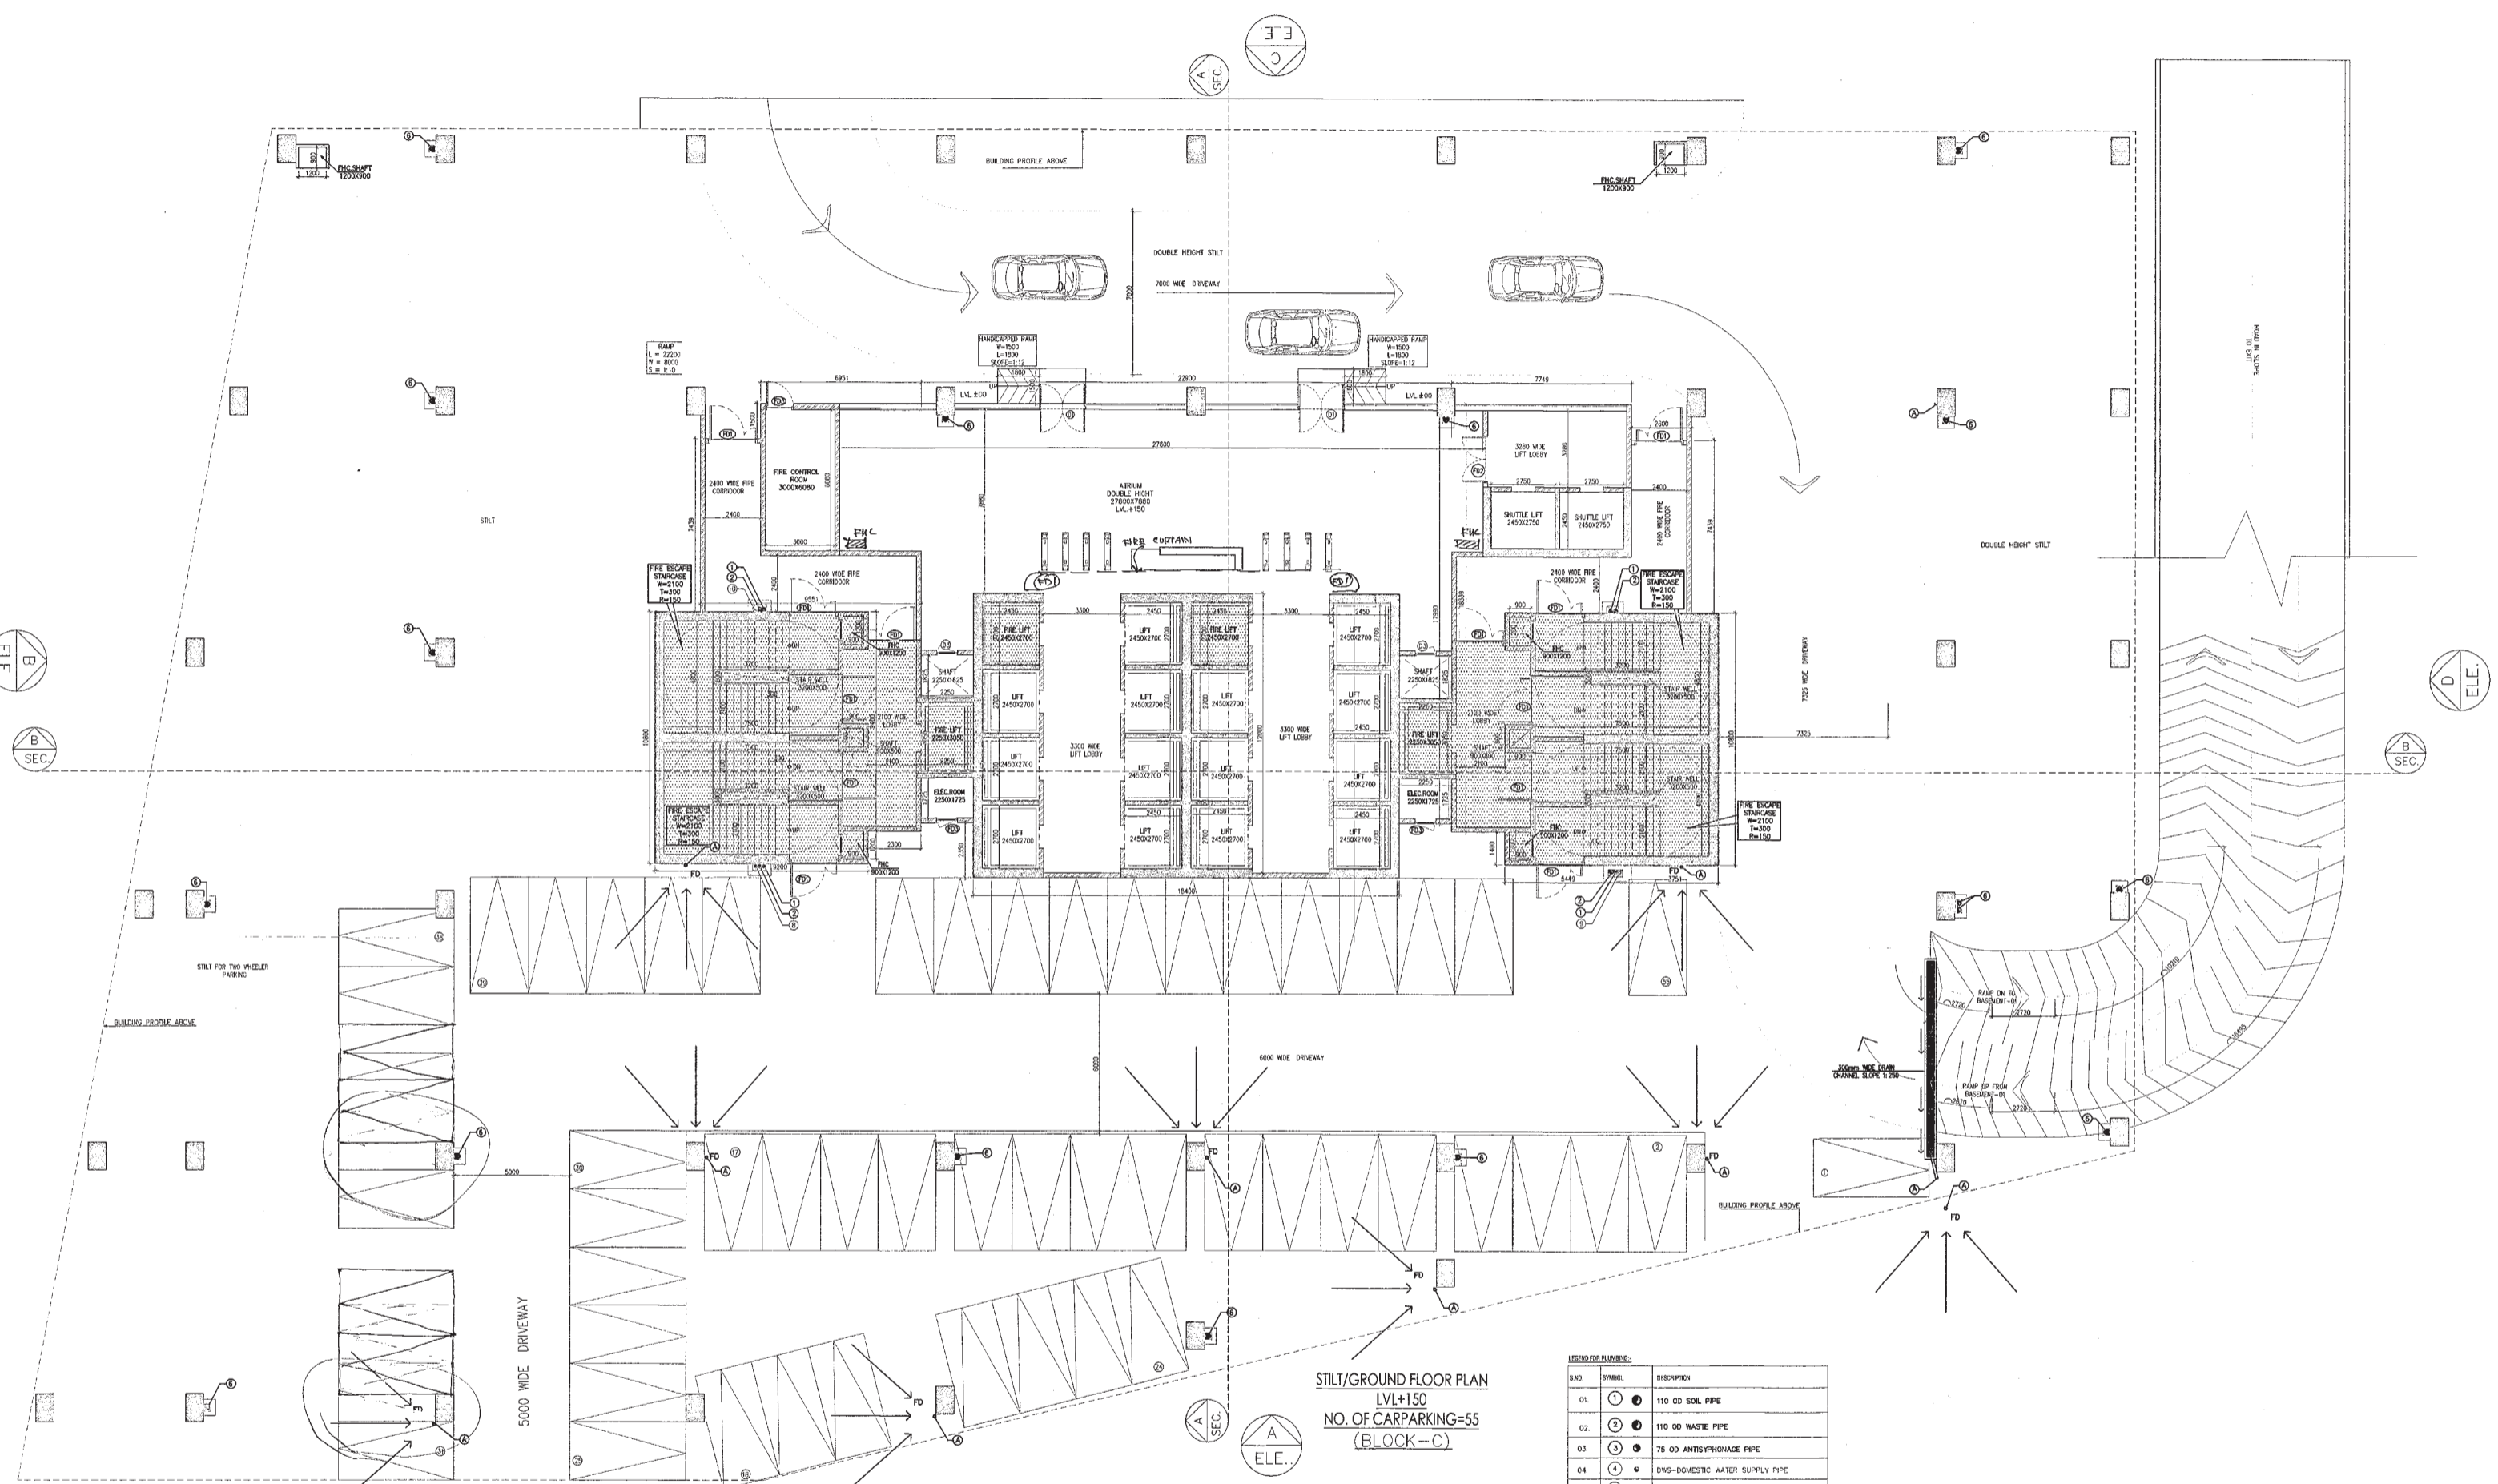

STILT/GROUND FLOOR PLAN LVL+150 NO. OF CARPARKING=55 (BLOCK-C)

SCHEDULE OF OPENINGS

S.No	TYPE	WIDTH	HEIGHT	REMARKS
1.	DH	2000	2450	
2.	D2	2100	2450	
3.	D3	900	2150	
4.	D4	1050	2150	
5.	D5	750	2150	
6.	DH	1700	2450	FIRE RATING
7.	FD	800	2450	2 HRS
8.	FDH	1700	2450	2 HRS
9.	FD2	2000	2450	2 HRS
9.	FD3	1200	2450	2 HRS

LEGEND/NOTES:

S.NO	SYMBOL	DESCRIPTION
01.	①	110 OD SOIL PIPE
02.	②	110 OD WASTE PIPE
03.	③	75 OD ANTI-SIPHONAGE PIPE
04.	④	DWS-DOMESTIC WATER SUPPLY PIPE
05.	⑤	FWS-FLUSHING WATER SUPPLY PIPE
06.	⑥	160 OD TERRACE RAIN WATER PIPE
07.	⑦	110 OD MURTY & BALCONY RAIN WATER PIPE
08.	⑧	DOMESTIC WATER RISER TO OH TANK FROM WTP
09.	⑨	FLUSHING WATER RISER TO OH TANK FROM STP
10.	⑩	SOFT WATER RISER TO OH TANK FROM STP
11.	⑪	110 OD BASEMENT DRAIN PIPE
11.	FD	FLOOR DRAIN
12.	FT	FLOOR TRAP
13.	UT	URINAL TRAP
14.	COF	FLOOR CLEAN OUT
15.	—	SOIL PIPE
16.	—	WASTE PIPE
17.	—	FLUSHING WATER SUPPLY (GRAVITY SUPPLY)
18.	—	DOMESTIC WATER SUPPLY (GRAVITY SUPPLY)