

This is a PROVISIONAL BUILDING PLAN approved only for the purpose of inviting objections from the general public.

Member Secretary
Member Secretary
Member Secretary

Ram Arav Basu
AD(HQ)


Checked and found OK for Public Health
Approved for the purpose of inviting objections from the general public
10/1/2021
10/1/2021
10/1/2021

DDA(HQ)
Member Secretary

370
1/1
1/1

DLF49939

S.NO.	SYMBOL	DESCRIPTION
01.	① ●	110 OD SOIL PIPE
02.	② ●	110 OD WASTE PIPE
03.	③ ●	75 OD ANTISYPHONAGE PIPE
04.	④ ●	DWS-DOMESTIC WATER SUPPLY PIPE
05.	⑤ ●	FWS-FLUSHING WATER SUPPLY PIPE
06.	⑥ ●	160 OD TERRACE RAIN WATER PIPE
07.	⑦ ●	110 OD MANTY & BALCONY RAIN WATER PIPE
08.	⑧ ●	DOMESTIC WATER RISER TO O.H. TANK FROM W/P
09.	⑨ ●	FLUSHING WATER RISER TO O.H. TANK FROM STP
10.	⑩ ●	SOFT WATER RISER TO O.H. TANK FROM STP
11.	⑪ ●	110 OD BASEMENT DRAIN PIPE
12.	FD ●	FLOOR DRAIN
13.	FT ●	FLOOR TRAP
14.	UT ●	URINAL TRAP
15.	COP	FLOOR CLEAN OUT
16.	—	SOIL PIPE
17.	—	WASTE PIPE
18.	—	FLUSHING WATER SUPPLY(GRAVITY SUPPLY)
19.	—	DOMESTIC WATER SUPPLY(GRAVITY SUPPLY)

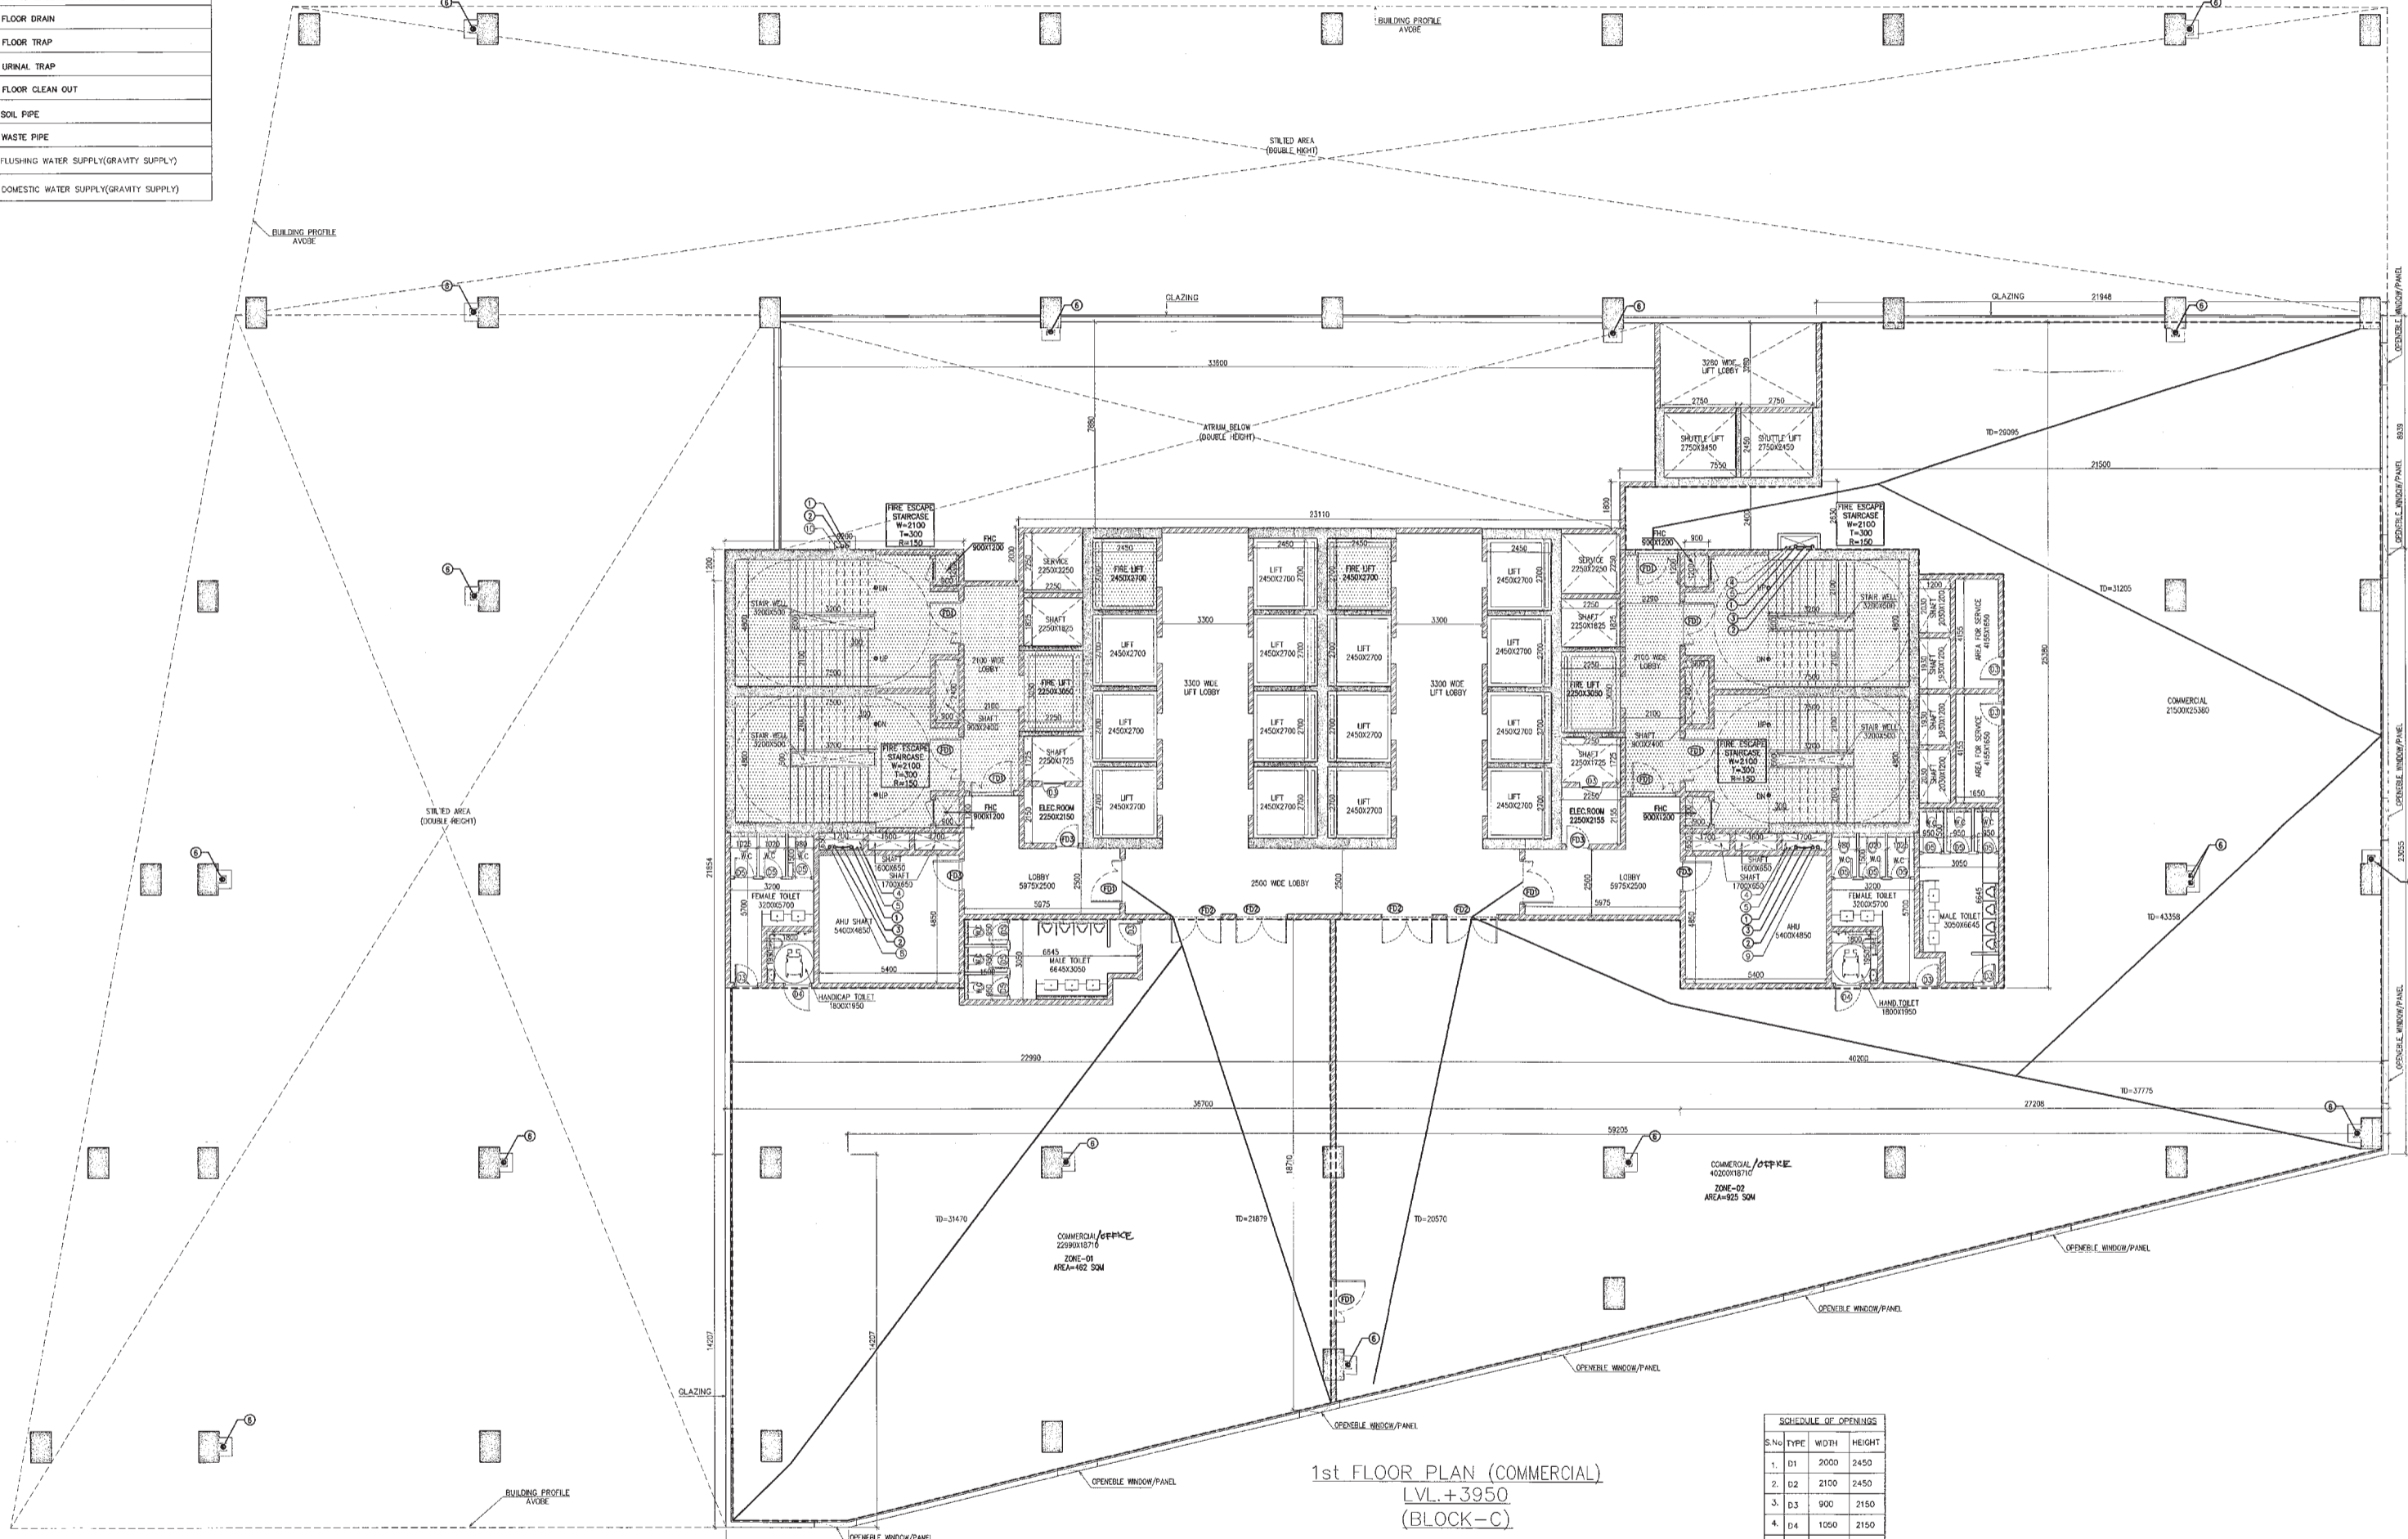


NOTE:-ALL OPENABLE WINDOW / PANEL ARE PROVIDED AT 10M DISTANCE.

S.No	TYPE	WIDTH	HEIGHT	FIRE RATING
1.	D1	2000	2450	
2.	D2	2100	2450	
3.	D3	900	2150	
4.	D4	1050	2150	
5.	D5	750	2150	
6.	D1	1200	2450	2 HRS
7.	FD	900	2450	2 HRS
8.	FD1	1700	2450	2 HRS
9.	FD2	2000	2450	2 HRS
9.	FD3	1200	2450	2 HRS

KEY PLAN

BUILDING - C

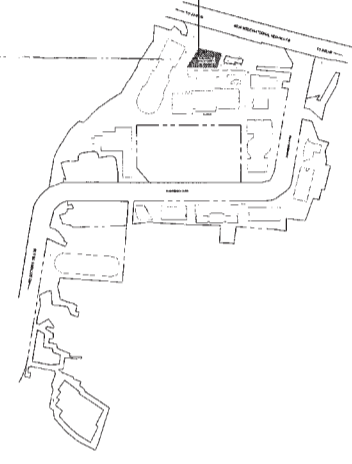

Architect
Hafeez
Contractor

29 Bunk Street, Bombay Ave E23 Tel:056/920

RISMS
ARCHITECTS

RSMS ARCHITECTS PVT. LTD.
69,Nora Niwas Bhawani Kunj
(Behind D2), Vasant Kunj,
New Delhi-110070.
Tel.: 011-26898616,26898617
www.rsms-arch.com

Project:
PROPOSED BUILDING PLANS OF BUILDING - B AND REVISED BUILDING PLANS OF BUILDING-C, D, E, & F IN CYBER CITY UNDER TRANSIT ORIENTED DEVELOPMENT (TOD) POLICY FOR MIX LAND USED COLONY(70% IT/ITES+30% COMMERCIAL) MEASURING 108.55922 ACRES IN SECTOR 24, 25 & 25-A, GURUGRAM MANESAR URBAN COMPLEX BEING DEVELOPED BY DLF CYBER CITY DEVELOPERS LIMITED

OWNER: DLF Cyber City Developers Ltd.
10th Floor DLF Gateway Tower,
DLF Cyber City,Gurugram,Haryana
Pin:122002

DRAWING TITLE: -
1st FLOOR PLAN
BLOCK-C

REVISION	JOB NO.:-	DRG NO.	NORTH
		BC-02	▲
	SCALE:- 1:100	DATE:- 01-04-2021	
FILE:-	DEALT BY:-	CHECKED BY:-	APPROVED BY:-
ARCHITECT'S SEAL & SIGNATURE		OWNER'S SEAL & SIGNATURE	

[Handwritten Signature]

