


This is a "PROVISIONAL BUILDING PLAN" approved only for the purpose of inviting objections from the general public.

[Signatures]
 Checked and found ok for Public Health Department of the Government of NCT of Delhi.
 DDF HOJ
 MHP
 BFC

[Signatures]
 MHP
 BFC

KEY PLAN

BUILDING - D

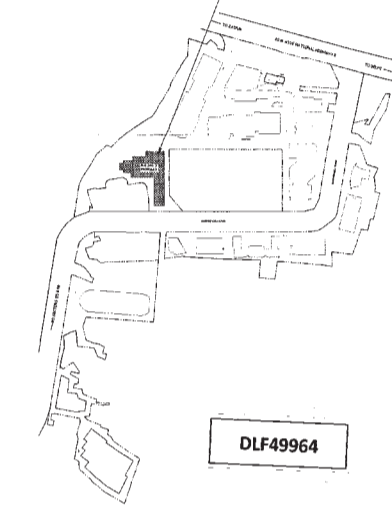

Architect
Hafeez
Contractor
 29 Bank Street, Bombay 400 023, Tel: 668926

RSIMS
 ARCHITECTS

RSMS ARCHITECTS PVT. LTD.
 69, Nora Niwas, Bhawani Kunj (Behind D2), Vasant Kunj, New Delhi-110070.
 Tel.: 011-26898616, 26898617
 www.rsms-arch.com

Project: PROPOSED BUILDING PLANS OF BUILDING - B AND REVISED BUILDING PLANS OF BUILDING - C, D, E, & F IN CYBER CITY UNDER TRANSIT ORIENTED DEVELOPMENT (TOD) POLICY FOR MIX LAND USED COLONY (70% IT/ITES / +30% COMMERCIAL) MEASURING 108.55922 ACRES IN SECTOR 24, 25 & 25-A, GURUGRAM MANESAR URBAN COMPLEX BEING DEVELOPED BY DLF CYBER CITY DEVELOPERS LIMITED

OWNER: DLF Cyber City Developers Ltd.
 10th Floor DLF Gateway Tower, DLF Cyber City, Gurugram, Haryana Pin: 122002


DRAWING TITLE: -

1st FLOOR PLAN
 BLOCK-D

REVISION	JOB NO. -	DRG NO. -	NORTH -
	SCALE: -	DATE: -	
	1:200	01-04-2021	

FILE: - DEALT BY: - CHECKED BY: - APPROVED BY: -

ARCHITECT'S SEAL & SIGNATURE
 OWNER'S SEAL & SIGNATURE

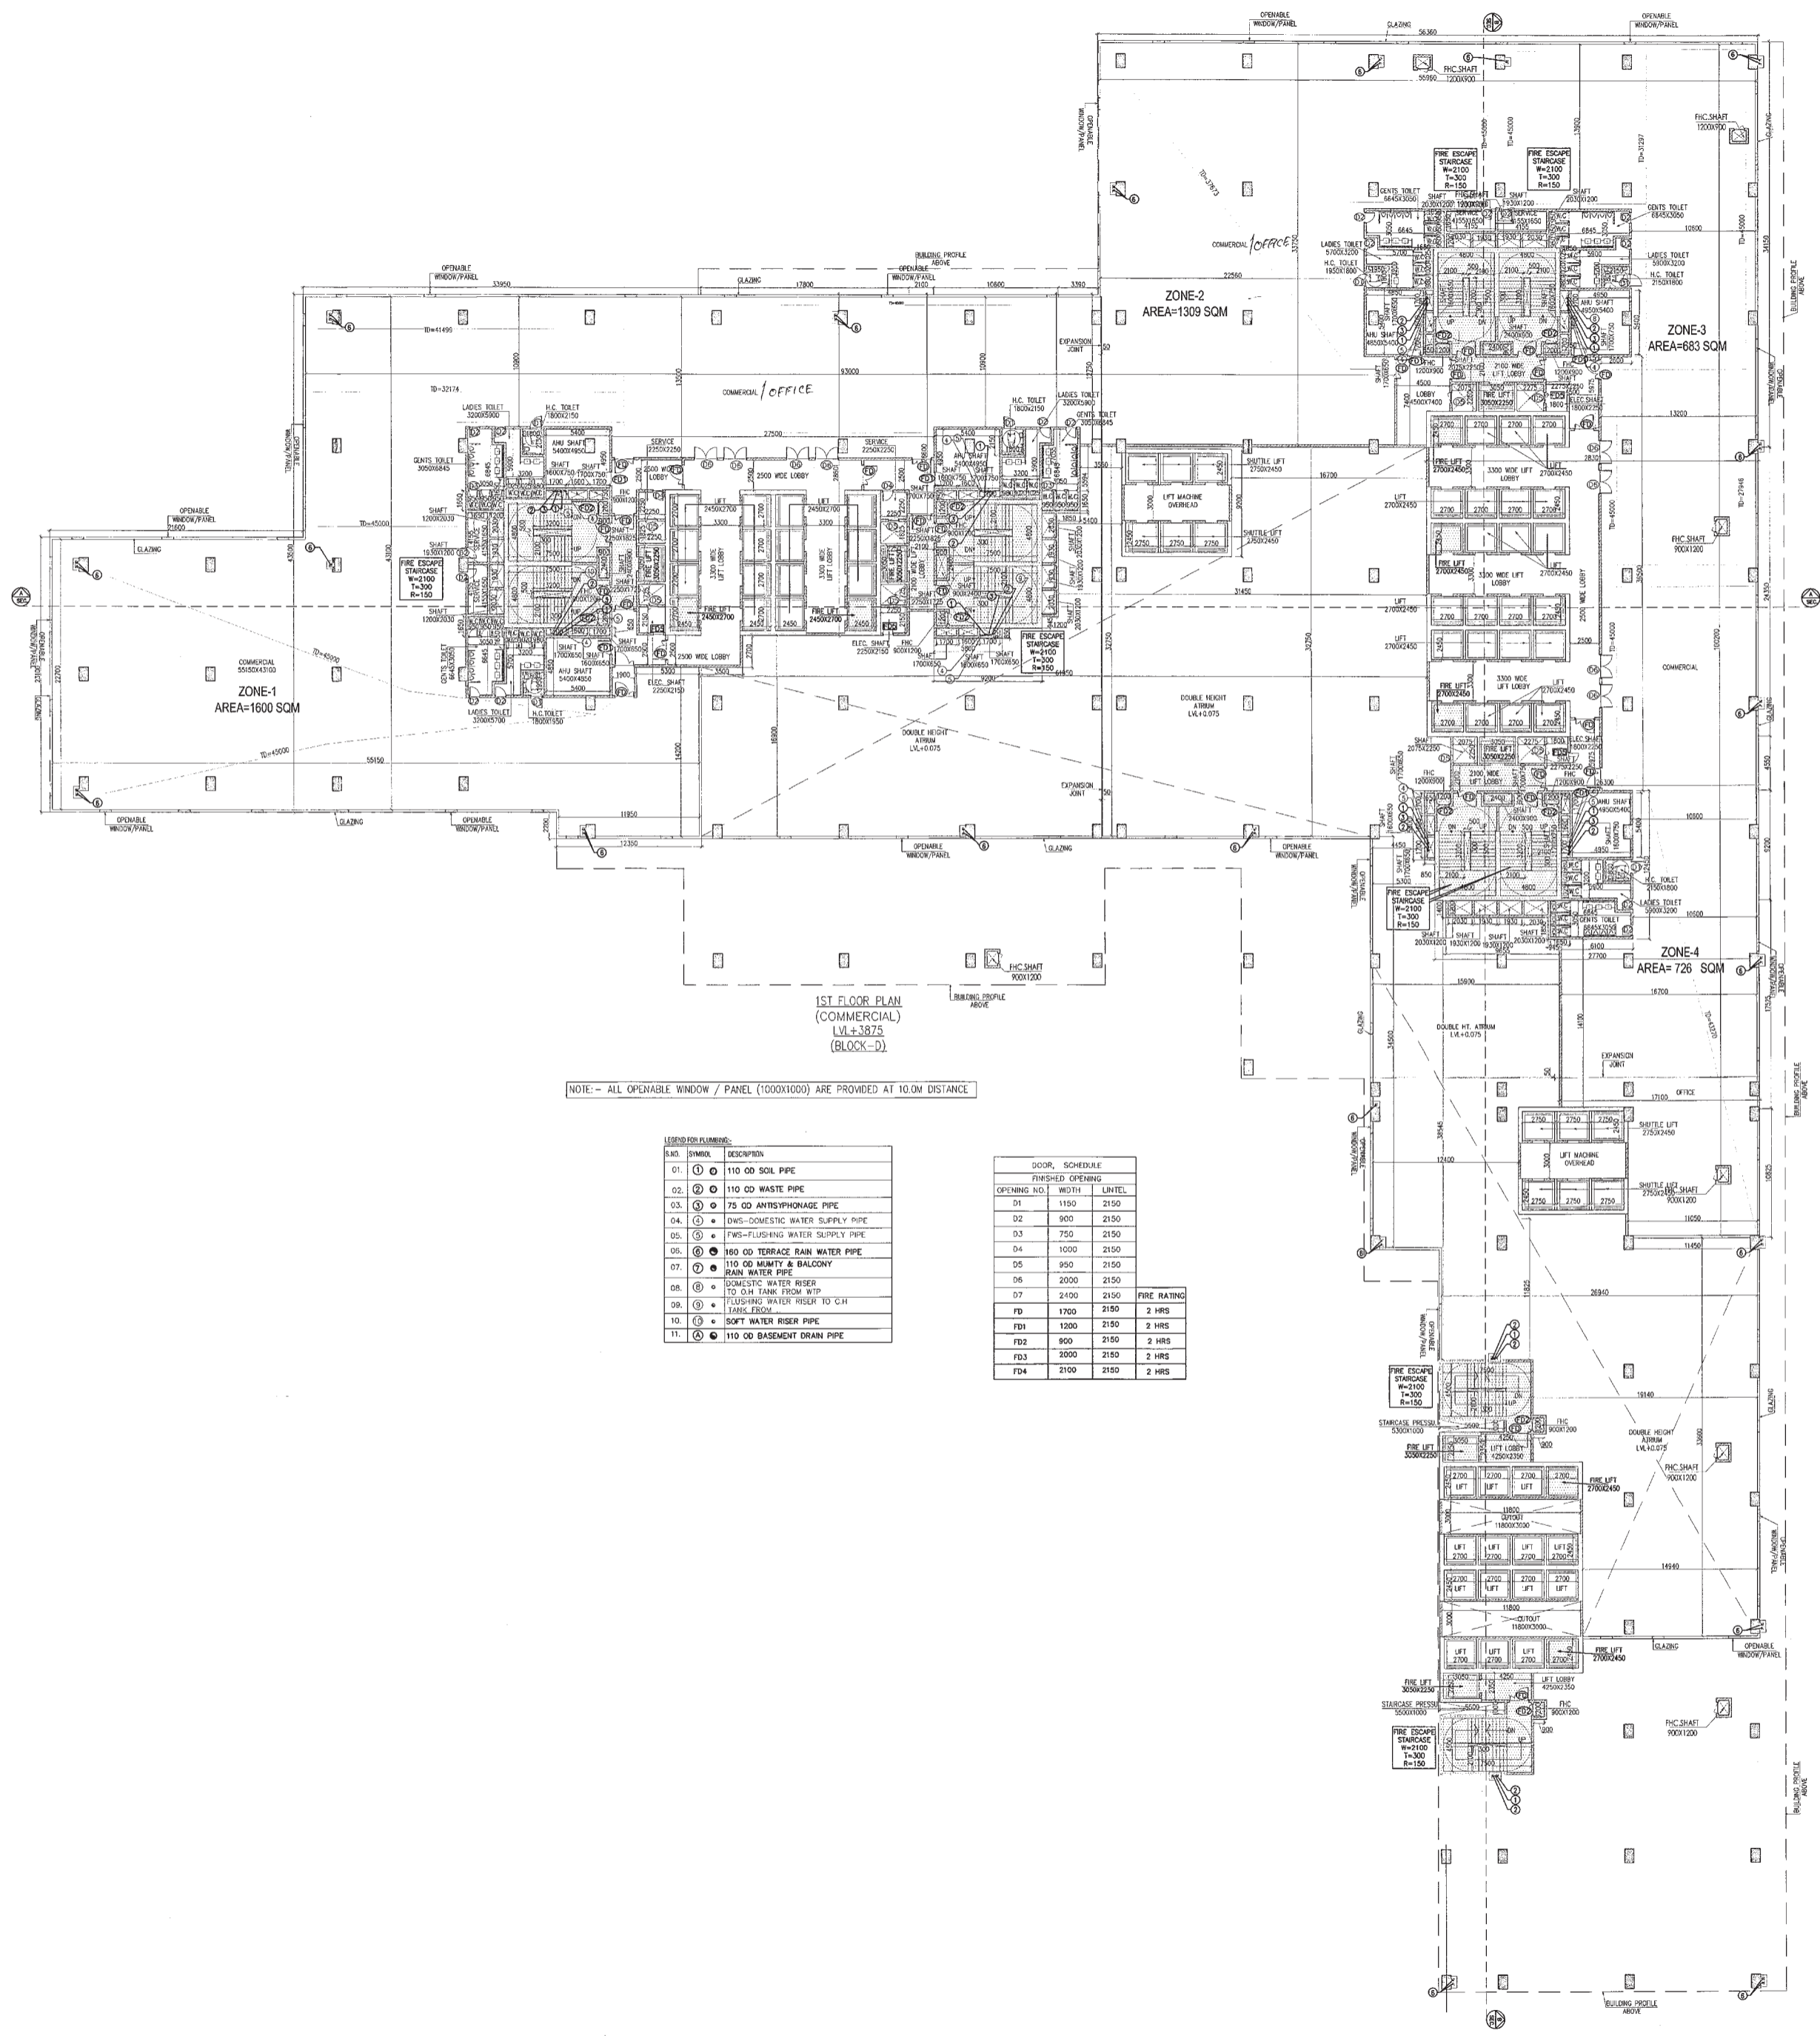

1ST FLOOR PLAN
 (COMMERCIAL)
 LVL +3875
 (BLOCK-D)

NOTE: - ALL OPENABLE WINDOW / PANEL (1000X1000) ARE PROVIDED AT 10.0M DISTANCE

LEGEND FOR FINISHES:

S.NO.	SYMBOL	DESCRIPTION
01	①	110 OD SOIL PIPE
02	②	110 OD WASTE PIPE
03	③	75 OD ANTISEPIONAGE PIPE
04	④	DWS-SOMESTIC WATER SUPPLY PIPE
05	⑤	PWS-FLUSHING WATER SUPPLY PIPE
06	⑥	160 OD TERRACE RAIN WATER PIPE
07	⑦	110 OD MURTY & BALCONY RAIN WATER PIPE
08	⑧	SOMESTIC WATER RISER TO O.H. TANK FROM WTP
09	⑨	FLUSHING WATER RISER TO C.H. TANK FROM
10	⑩	SOFT WATER RISER PIPE
11	⑪	110 OD BASEMENT DRAIN PIPE

DOOR SCHEDULE

FINISHED OPENING	DOOR	SCHEDULE
OPENING NO.	WIDTH	LENGTH
D1	1150	2150
D2	900	2150
D3	750	2150
D4	1000	2150
D5	950	2150
D6	2000	2150
D7	2400	2150
FD	1700	2150
FD1	1200	2150
FD2	900	2150
FD3	2000	2150
FD4	2100	2150

FIRE RATING

FD	1700	2150	2 HRS
FD1	1200	2150	2 HRS
FD2	900	2150	2 HRS
FD3	2000	2150	2 HRS
FD4	2100	2150	2 HRS