

This is a "PROVISIONAL BUILDING PLAN" approved only for the purpose of inviting objections from the general public.

DRG NO. BD-06


Planned by: Ram / Hiral Bansal AD(HO)  
 Architect: Hafeez Contractor  
 STP: Member Secretary BPC  
 M: Member BPC  
 C: Chairman BPC  
 DD (HO): Member BPC

100 SD  
 02 PA  
 01 AD

DLF49969

KEY PLAN

BUILDING - D

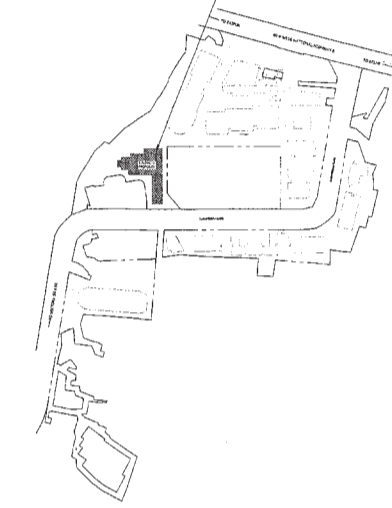

Architect  
 Hafeez  
 Contractor  
 29 North Street, Bombay 400 022, Tel: 2559320

RISIMS ARCHITECTS

RSMS ARCHITECTS PVT. LTD.  
 69, Nora Niwas, Bhowani Kunj (Behind D2), Vasant Kunj, New Delhi-110070.  
 Tel.: 011-26898616, 26898617  
 www.rsms-arch.com

Project:  
 PROPOSED BUILDING PLANS OF BUILDING - B AND REVISED BUILDING PLANS OF BUILDING - C, D, E, & F IN CYBER CITY UNDER TRANSIT ORIENTED DEVELOPMENT (TOD) POLICY FOR MIX LAND USED COLONY (70% IT/ITES/4-30% COMMERCIAL) MEASURING 108.55922 ACRES IN SECTOR 24, 25 & 25-A, GURUGRAM MANESAR URBAN COMPLEX BEING DEVELOPED BY DLF CYBER CITY DEVELOPERS LIMITED


OWNER: DLF Cyber City Developers Ltd.  
 10th Floor DLF Gateway Tower, DLF Cyber City, Gurugram, Haryana Pin: 122002

DRAWING TITLE: -  
 L.M.R FLOOR PLAN  
 BLOCK-D

REVISION	JOB NO: -	DRG NO. BD-06	NORTH: -
	SCALE: - 1:200	DATE: - 01-04-2021	

FILE: -	DEALT BY: -	CHECKED BY: -	APPROVED BY: -
ARCHITECT'S SEAL & SIGNATURE		OWNER'S SEAL & SIGNATURE	

Architect's Signature: Hafeez Contractor  
 Owner's Seal: DLF Cyber City Developers Ltd.

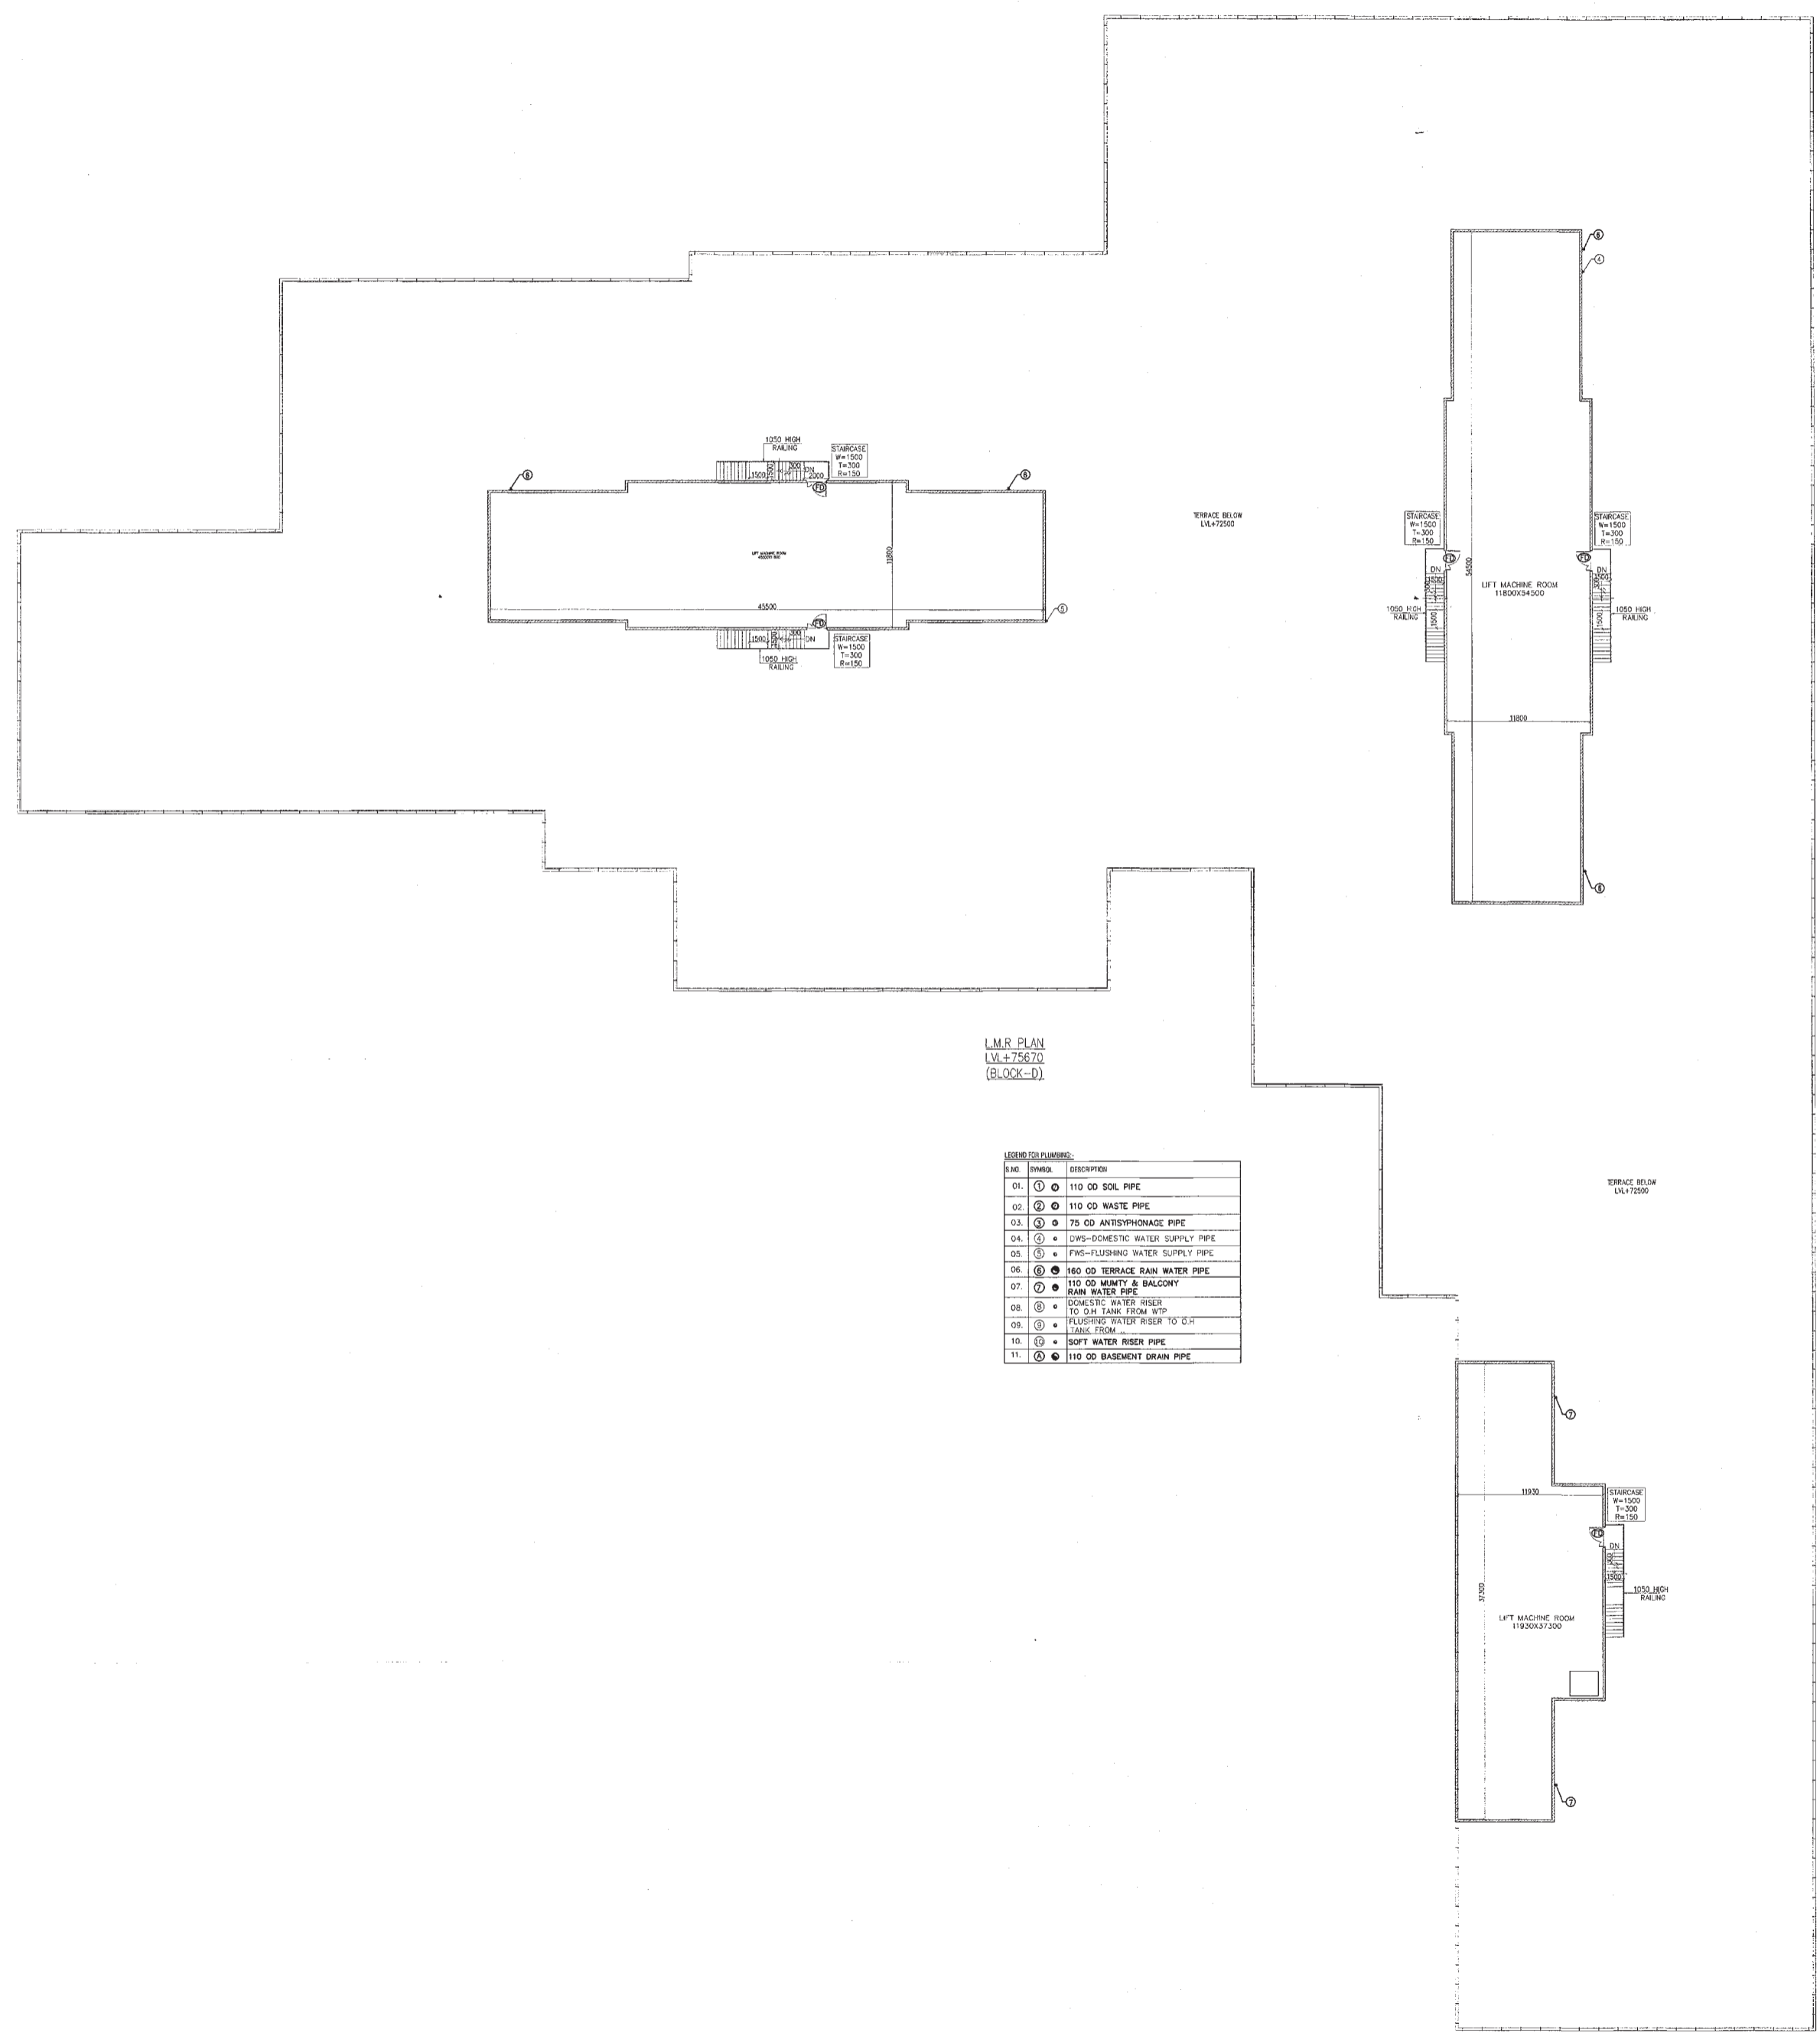

L.M.R. PLAN  
 LV-2-75670  
 (BLOCK-D)

LEGEND FOR PLUMBING:

SYMBOL	DESCRIPTION
01. (Symbol)	110 OD SOLE PIPE
02. (Symbol)	110 OD WASTE PIPE
03. (Symbol)	75 OD ANTISIPHONAGE PIPE
04. (Symbol)	DNF-DOMESTIC WATER SUPPLY PIPE
05. (Symbol)	DNF-FLUSHING WATER SUPPLY PIPE
06. (Symbol)	160 OD TERRACE RAIN WATER PIPE
07. (Symbol)	110 OD MURTY & BALCONY RAIN WATER PIPE
08. (Symbol)	DOMESTIC WATER RISER TO OH TANK FROM WTP
09. (Symbol)	FLUSHING WATER RISER TO OH TANK FROM WTP
10. (Symbol)	SOFT WATER RISER PIPE
11. (Symbol)	110 OD BASEMENT DRAIN PIPE