


A.D.F.O. (H.O)  
DFS PKL  
Member B.P.C.

DRG NO. BSD-01

KEY PLAN BUILDING - D

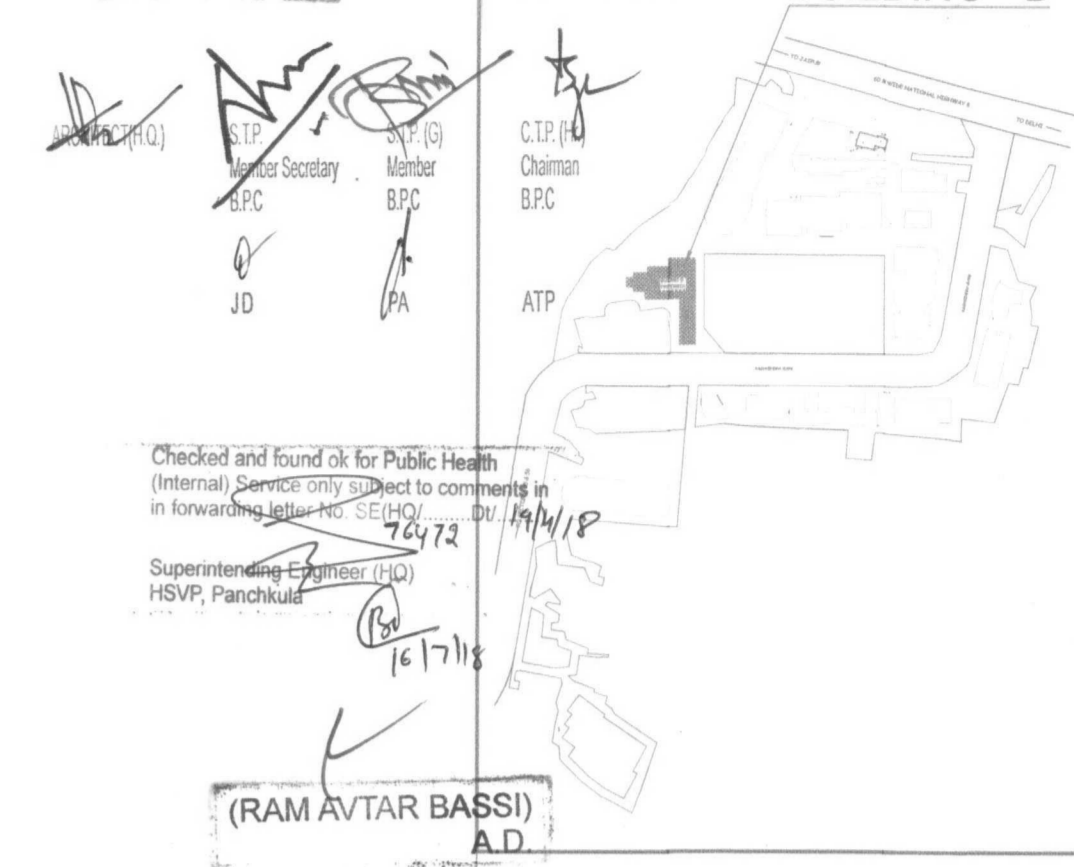

Checked and found ok for Public Health  
(Internal) Sewer only. Direct to combined in  
forwarding to M.P.C. S.E.I.C. DU/14/1/P  
72472  
Superintending Engineer (H.O)  
HSVP, Panchkaj  
16/7/18

(RAM AVTAR BASSI)  
A.D.

DLF45404

**DOOR WINDOW SCHEDULE**

D	3000X2450
D1	1540X2450
D2	1700X2450
D3	900X2450
D4	2500X2450
D5	2000X2450
D6	3040X2450
D7	880X2450
DB	1040X2450

**FIRE DOOR SCHEDULE**


DOOR NAME	SIZE	FIRE RATING
FD	1540X2450	2HR
FD1	1700X2450	2HR
FD2	1250X2450	2HR
FD3	3040X2450	2HR
FD4	1800X2450	2HR

**LEGEND**  
FD FIRE DOOR

**LEGEND FOR PLUMBING:-**

S.NO.	SYMBOL	DESCRIPTION
01.	①	110 OD SOIL PIPE
02.	②	110 OD WASTE PIPE
03.	③	75 OD ANTISIPHONAGE PIPE
04.	④	COLD WATER SUPPLY PIPE
05.	⑤	FLUSHING WATER SUPPLY PIPE
06.	⑥	160 OD TERRACE RAIN WATER PIPE
07.	⑦	DOMESTIC WATER RISER TO G.H. TANK FROM W.P. CONNECTION WATER TOWER TO G.H. TANK FROM S.H.
08.	⑧	FLUSHING WATER RISER TO G.H. TANK FROM S.H.
09.	Ⓐ	110 OD BASEMENT & PODIUM DRAIN PIPE
10.	⓪	FLOOR DRAIN
11.	Ⓜ	FLOOR TRAP
12.	Ⓤ	URINAL TRAP
13.	Ⓛ	FLOOR CLEAN OUT
14.	—	SOIL PIPE
15.	—	WASTE PIPE
16.	—	FLUSHING WATER SUPPLY(DRAVITY SUPPLY)
17.	—	DOMESTIC WATER SUPPLY(DRAVITY SUPPLY)

BASEMENT-01  
LVL-4050  
PARKING NO.=451  
(BUILDING-D)

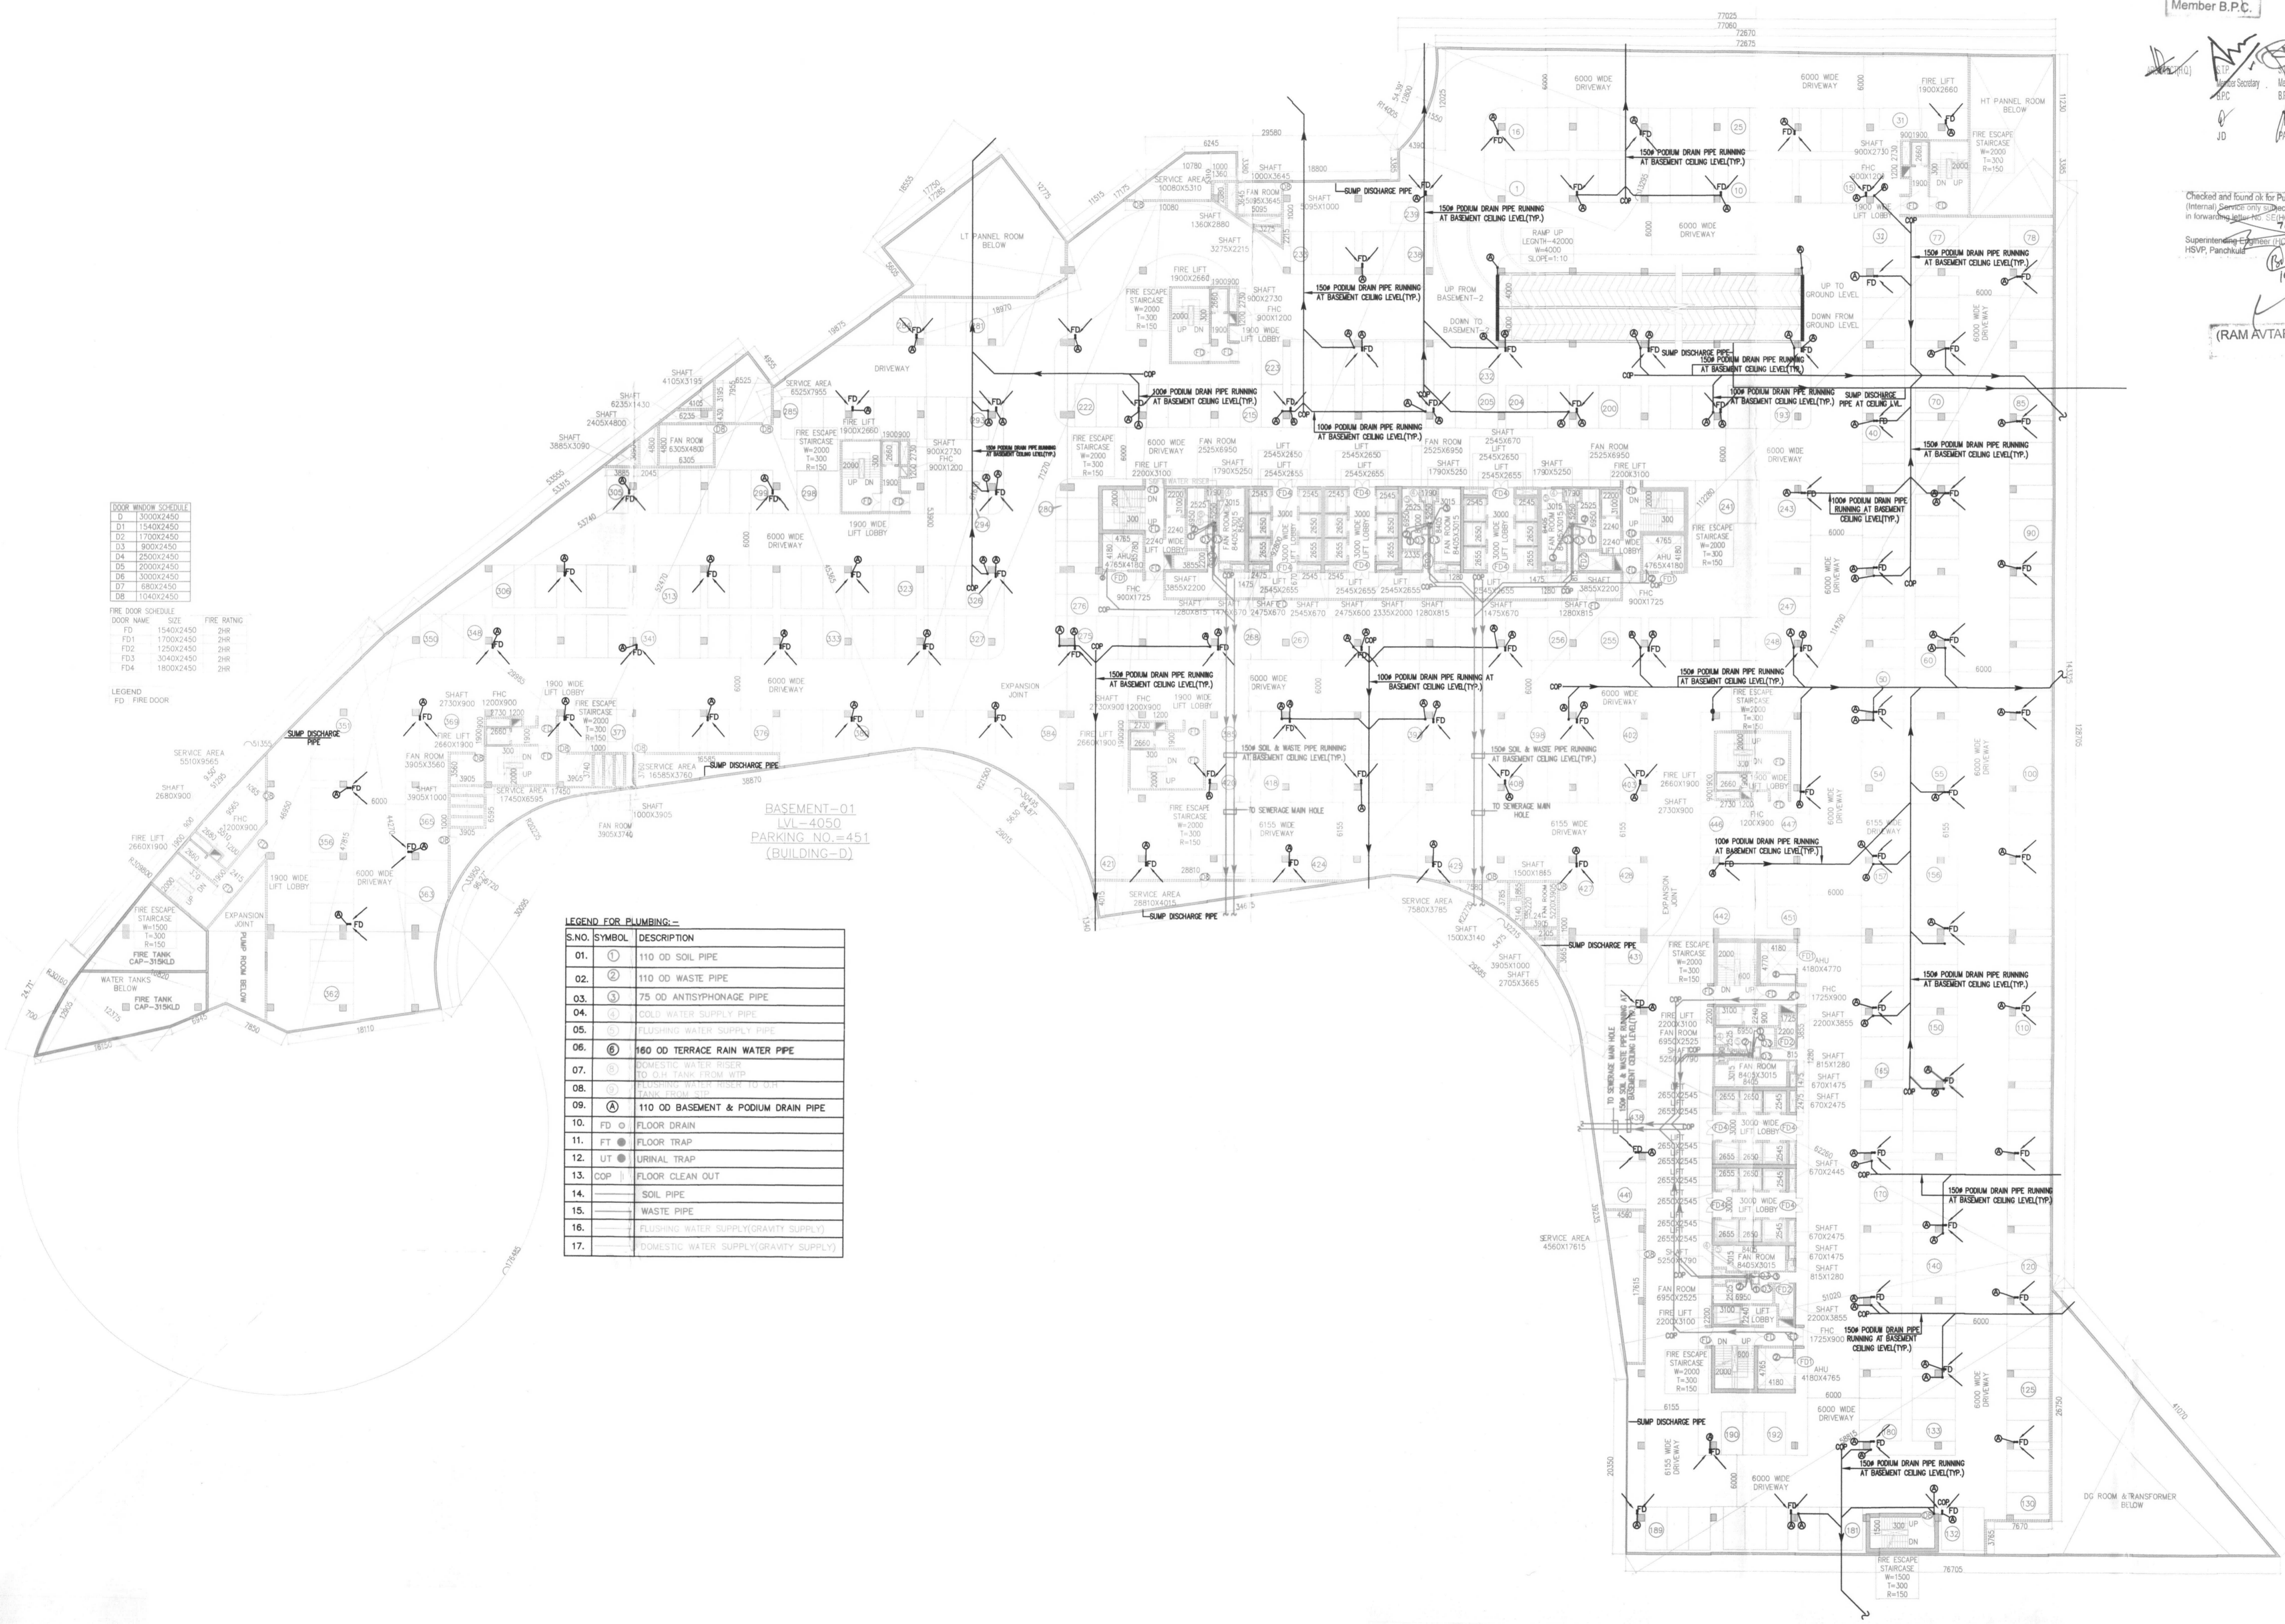

Architect  
Hafeez  
Contractor

**RSMS ARCHITECTS**

RSMS ARCHITECTS PVT. LTD.  
69, Nara Niwas Bhowani Kunj  
(Behind D2), Vasant Kunj,  
New Delhi-110070.  
Tel.: 011-26898616, 26898617  
www.rsms-arch.com

Project:  
PROPOSED BUILDING PLAN OF BUILDING  
- C, BUILDING -D, BUILDING -E AND  
BUILDING -F IN 94.57485 ACRES DLF  
CYBER CITY, SECTOR 24, 25 & 25A,  
GURGAON, HARYANA.

OWNER:  
DLF Cyber City Developers Ltd.  
10th Floor DLF Gateway Tower,  
DLF Cyber City, Gurugram, Haryana  
Pin: 122002

DRAWING TITLE:-  
BUILDING -D  
BASEMENT-01

REVISION	JOB NO.:-	DRG NO.	NORTH
		BSD-01	N
SCALE:-	DATE:-		
1:300	16-05-2018		
FILE:-	DEALT BY:-	CHECKED BY:-	APPROVED BY:-
ARCHITECT'S SEAL & SIGNATURE	OWNER'S SEAL & SIGNATURE		

