


A.D.F.O. (HQ)  
DFS PKL  
Member B.P.C.

DRG NO. BSD-02

KEY PLAN BUILDING - D

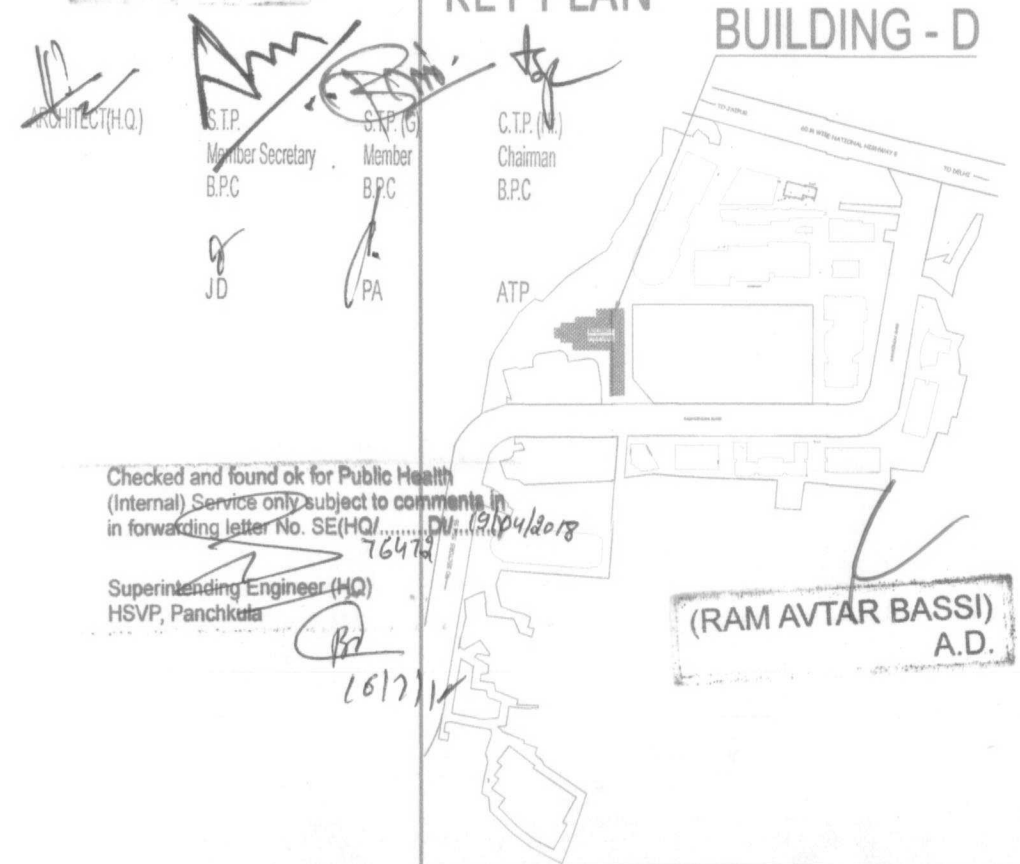

Checked and found ok for Public Health (Internal) Service (R) subject to comments in knowledge letter No. SE/HQ/...  
Supervising Engineer (H) HSWP, Panchnani

DLF45405

Architect  
**Hafeez Contractor**  
29, Park Street, Bombay 400 013, India

**RSMS ARCHITECTS**

RSMS ARCHITECTS PVT. LTD.  
69, Nara Niwas, Bhawani Kunj  
(Behind D2), Vasant Kunj,  
New Delhi-110070.  
Tel.: 011-26898616, 26898617  
www.rsms-arch.com

Project:  
PROPOSED BUILDING PLAN OF BUILDING - C, BUILDING -D, BUILDING -E AND BUILDING -F IN 94.57485 ACRES DLF CYBER CITY, SECTOR 24, 25 & 25A, GURGAON, HARYANA.


OWNER: DLF Cyber City Developers Ltd.  
10th Floor DLF Gateway Tower,  
DLF Cyber City, Gurugram, Haryana  
Pin: 122002

DRAWING TITLE:-  
**BUILDING-D  
BASEMENT-02**

REVISION	JOB NO.:-	DRG NO.:-	NORTH:-
		BSD-02	N
SCALE:-	DATE:-		
1:300	16-05-2018		

FILE:-	DEALT BY:-	CHECKED BY:-	APPROVED BY:-

ARCHITECT'S SEAL & SIGNATURE	OWNER'S SEAL & SIGNATURE

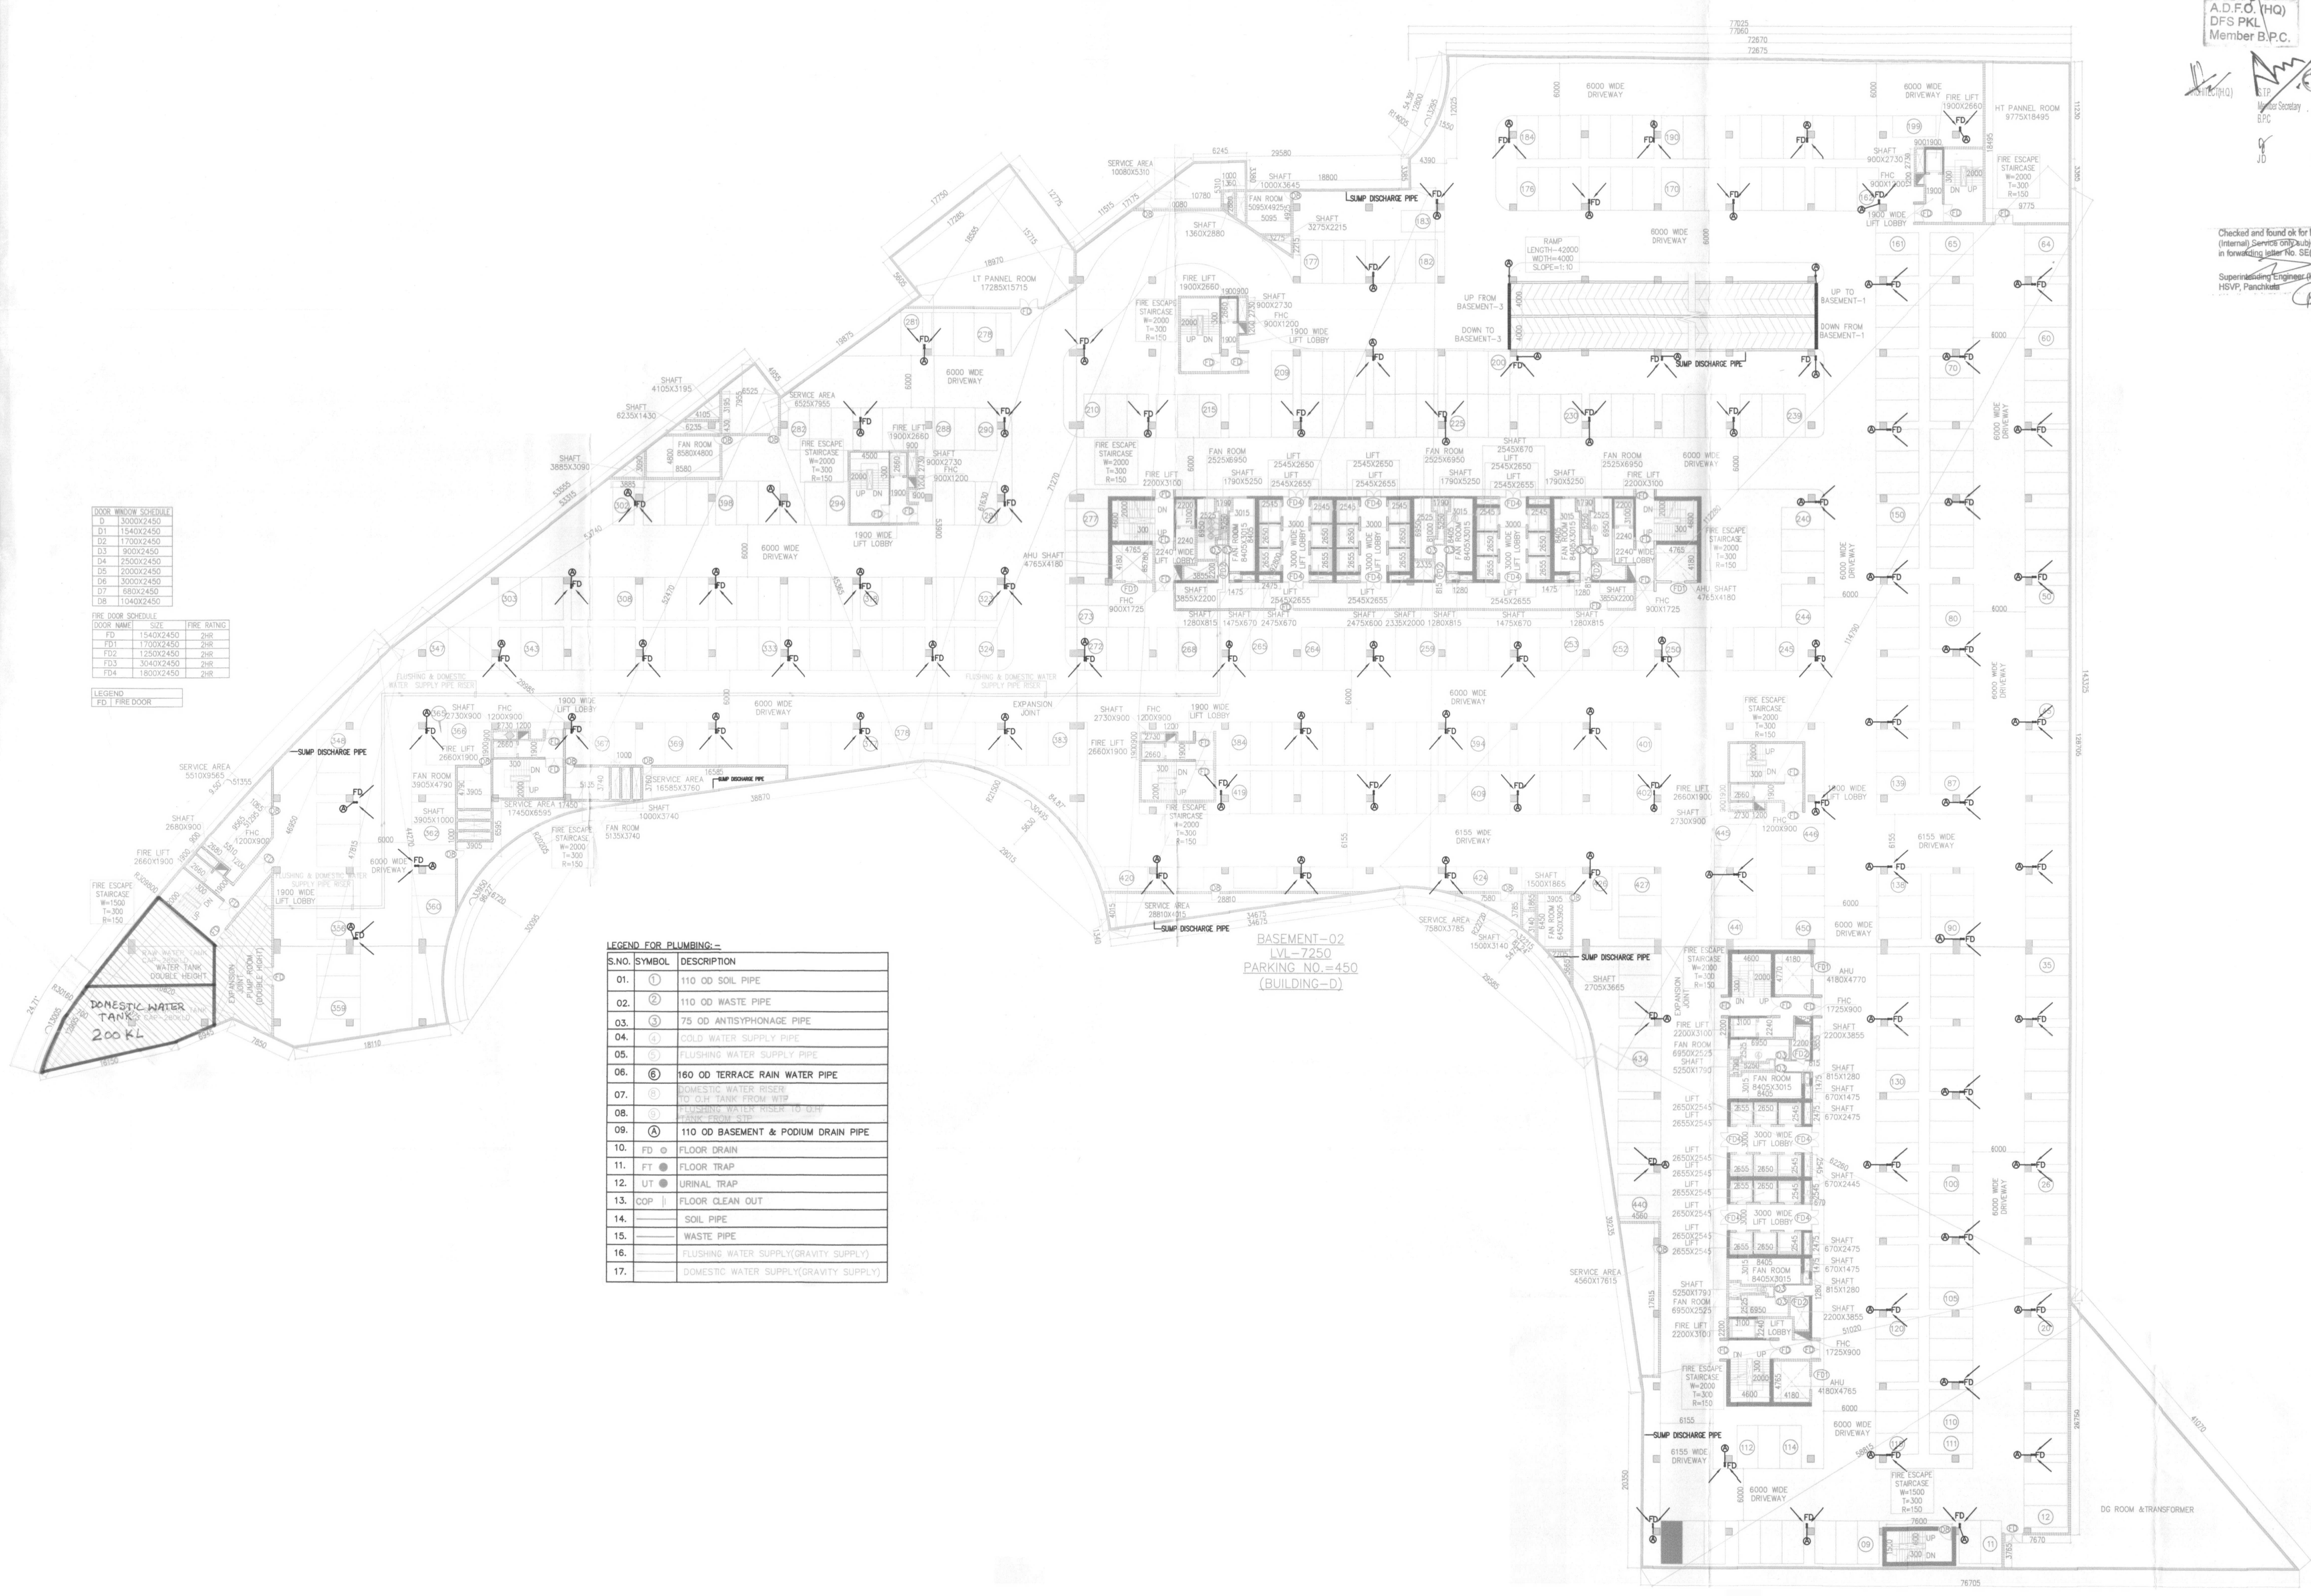

DOOR SCHEDULE

D1	1540X2450
D2	1700X2450
D3	1900X2450
D4	2500X2450
D5	2000X2450
D6	1500X2450
D7	680X2450
D8	1100X2450

FIRE DOOR SCHEDULE

FD	1540X2450	2HR
FD1	1700X2450	2HR
FD2	1250X2450	2HR
FD3	1040X2450	2HR
FD4	1800X2450	2HR

LEGEND  
FD | FIRE DOOR

LEGEND FOR PLUMBING:-

S.NO.	SYMBOL	DESCRIPTION
01.	①	110 OD SOIL PIPE
02.	②	110 OD WASTE PIPE
03.	③	75 OD ANTISYPHONAGE PIPE
04.	④	COLD WATER SUPPLY PIPE
05.	⑤	FLUSHING WATER SUPPLY PIPE
06.	⑥	160 OD TERRACE RAIN WATER PIPE
07.	⑦	DOMESTIC WATER RISER TO C.H. TANK FROM WTP
08.	⑧	FLUSHING WATER RISER TO C.H. TANK FROM WTP
09.	⑨	110 OD BASEMENT & PODIUM DRAIN PIPE
10.	FD	FLOOR DRAIN
11.	FT	FLOOR TRAP
12.	UT	URINAL TRAP
13.	COP	FLOOR CLEAN OUT
14.	—	SOIL PIPE
15.	—	WASTE PIPE
16.	—	FLUSHING WATER SUPPLY (GRAVITY SUPPLY)
17.	—	DOMESTIC WATER SUPPLY (GRAVITY SUPPLY)

BASEMENT-02  
LV-7250  
PARKING NO.=450  
(BUILDING-D)