

Checked and found ok for Public Health (Internal) Squares 0173 subject to comments in forwarding letter No. SE(15) D/L/4174  
 Superintending Engineer (H.O.) HVP, Panichkula  
 16/11/18

A.D.F.O. (H.O.) DFS PKL Member B.P.C.

Member Secretary BPC  
 Member B.P.C.  
 Chairman BPC  
 ATP

(RAMAVTAR BASSI) A.C.

DLF45406

Architect Hafeez Contractor  
 21 Park Street, Bombay 400 023, India

RISMS ARCHITECTS


RISMS ARCHITECTS PVT. LTD.  
 69, Nara Niwas Bhowani Kunj (Behind D2), Vasant Kunj, New Delhi-110070.  
 Tel.: 011-26898616, 26898617  
 www.risms-arch.com

Project: PROPOSED BUILDING PLAN OF BUILDING - C, BUILDING -D, BUILDING -E AND BUILDING -F IN 94.57485 ACRES DLF CYBER CITY, SECTOR 24, 25 & 25A, GURGAON, HARYANA.

OWNER: DLF Cyber City Developers Ltd. 10th Floor DLF Gateway Tower, DLF Cyber City, Gurugram, Haryana Pin: 122002

DRAWING TITLE: BUILDING -D BASEMENT-03

REVISION	JOB NO. -	DRG NO. -	NORTH -
		BSD-03	N
SCALE: -	DATE: -		
1:300	16-05-2018		
FILE: -	DEALT BY: -	CHECKED BY: -	APPROVED BY: -
ARCHITECT'S SEAL & SIGNATURE	OWNER'S SEAL & SIGNATURE		

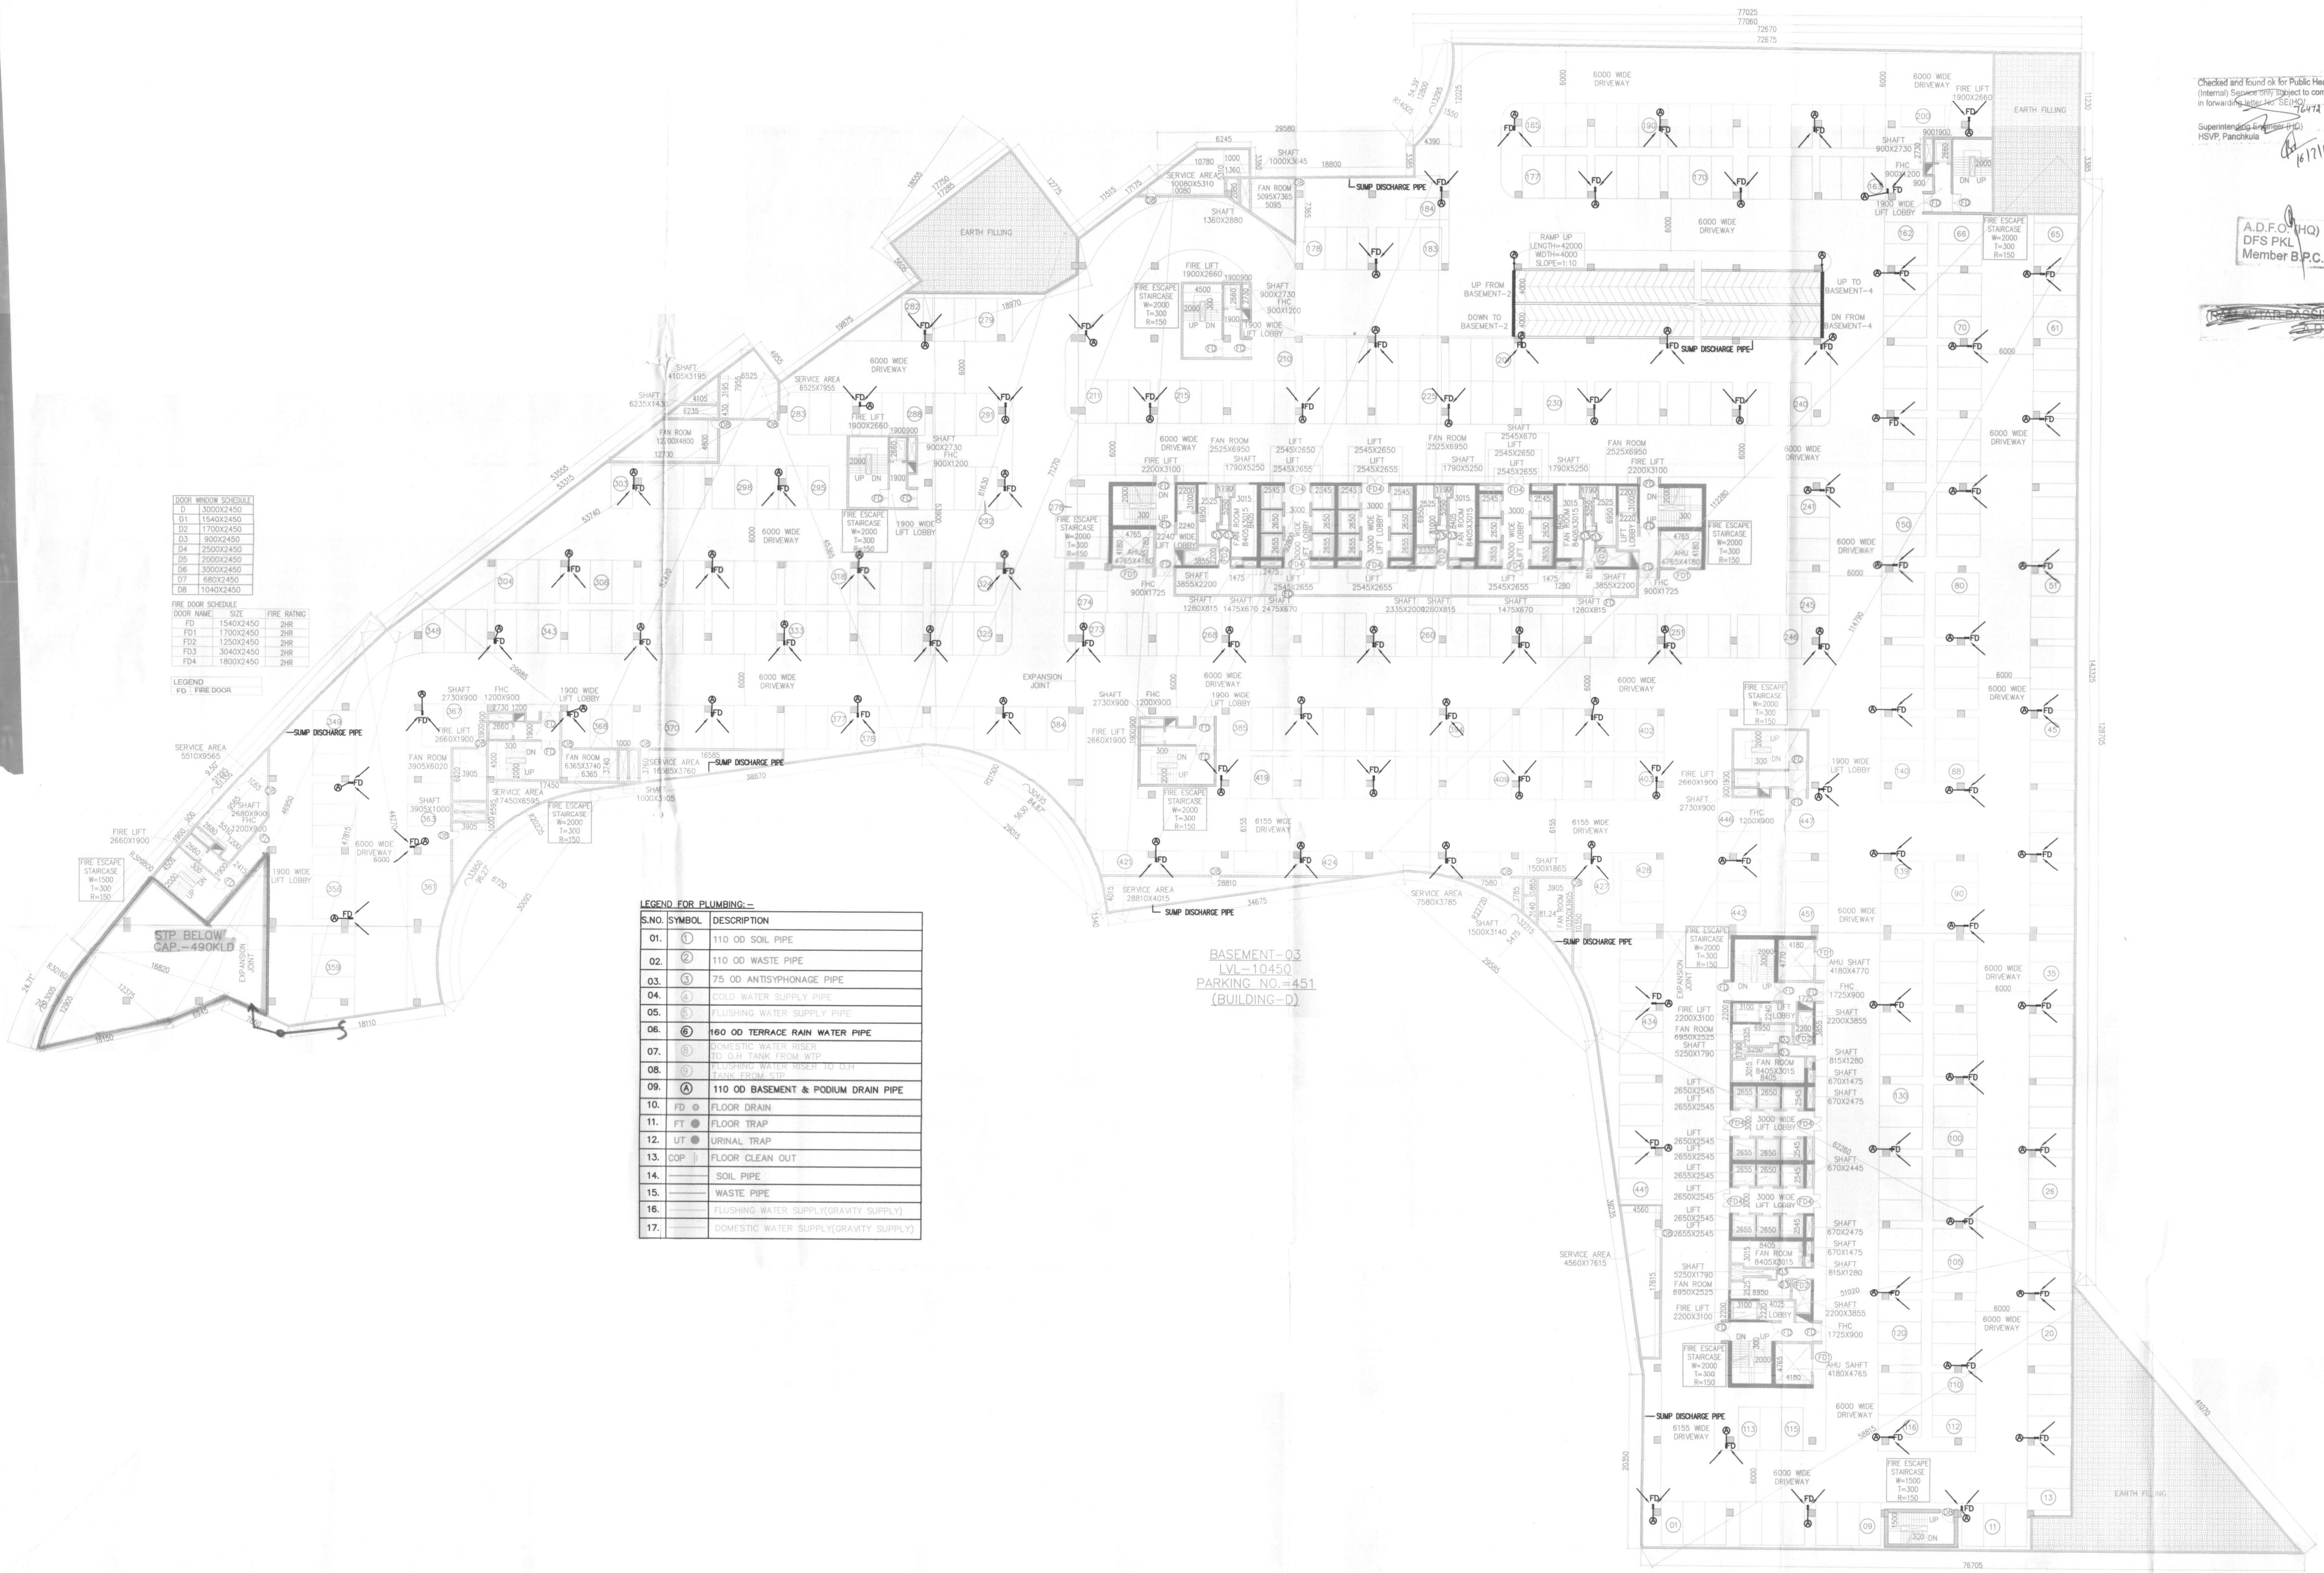

DOOR WINDOW SCHEDULE

D	3000X2450
D1	1540X2450
D2	1700X2450
D3	900X2450
D4	2500X2450
D5	2000X2450
D6	3000X2450
D7	6800X2450
D8	10400X2450

FIRE DOOR SCHEDULE

DOOR NAME	SIZE	FIRE RATING
FD	1540X2450	2HR
FD1	1700X2450	2HR
FD2	1250X2450	2HR
FD3	3040X2450	2HR
FD4	1800X2450	2HR

LEGEND  
 FD FIRE DOOR

LEGEND FOR PLUMBING:-

S.NO.	SYMBOL	DESCRIPTION
01.	①	110 OD SOIL PIPE
02.	②	110 OD WASTE PIPE
03.	③	75 OD ANTISYPHONAGE PIPE
04.	④	COLD WATER SUPPLY PIPE
05.	⑤	FLUSHING WATER SUPPLY PIPE
06.	⑥	160 OD TERRACE RAIN WATER PIPE
07.	⑦	DOMESTIC WATER RISER TO OH TANK FROM WTP
08.	⑧	FLUSHING WATER RISER TO OH TANK FROM STP
09.	Ⓐ	110 OD BASEMENT & PODIUM DRAIN PIPE
10.	FD	FLOOR DRAIN
11.	FT	FLOOR TRAP
12.	UT	URINAL TRAP
13.	COP	FLOOR CLEAN OUT
14.	○	SOIL PIPE
15.	—	WASTE PIPE
16.	—	FLUSHING WATER SUPPLY (GRAVITY SUPPLY)
17.	—	DOMESTIC WATER SUPPLY (GRAVITY SUPPLY)

BASEMENT-03  
 LVL - 10450  
 PARKING NO. = 451  
 (BUILDING-D)