

Checked and found ok for Public Health (Internal) Service only subject to comments in forwarding letter No. S/CP/10/13/14/197
 16/11/18
 Supervising Engineer (P.O.)
 HSVP, Panohala

A.D.F.O. (HQ)
 DFS PKL
 Member B.P.C.

DLF45407

Architect
Hafeez Contractor
 29 Bark Street, Bombay 400 023, India



RMS ARCHITECTS PVT. LTD.
 69, Nara Niwas Bhawani Kunj
 (Behind D2), Vasant Kunj,
 New Delhi-110070.
 Tel: 011-26898616, 26898617
 www.rms-arch.com

Project:
 PROPOSED BUILDING PLAN OF BUILDING - C, BUILDING - D, BUILDING - E AND BUILDING - F IN 94.57485 ACRES DLF CYBER CITY, SECTOR 24, 25 & 25A, GURGAON, HARYANA.


OWNER:
DLF DLF Cyber City Developers Ltd.
 10th Floor DLF Gateway Tower,
 DLF Cyber City, Gurugram, Haryana
 Pin: 122002

DRAWING TITLE: -
BUILDING-D BASEMENT-04

REVISION	JOB NO. -	DRG NO. -	NORTH
		BSD-04	↑
SCALE: -	DATE: -		
1:300	16-05-2018		
FILE: -	DEALT BY: -	CHECKED BY: -	APPROVED BY: -

ARCHITECT'S SEAL & SIGNATURE

OWNER'S SEAL & SIGNATURE

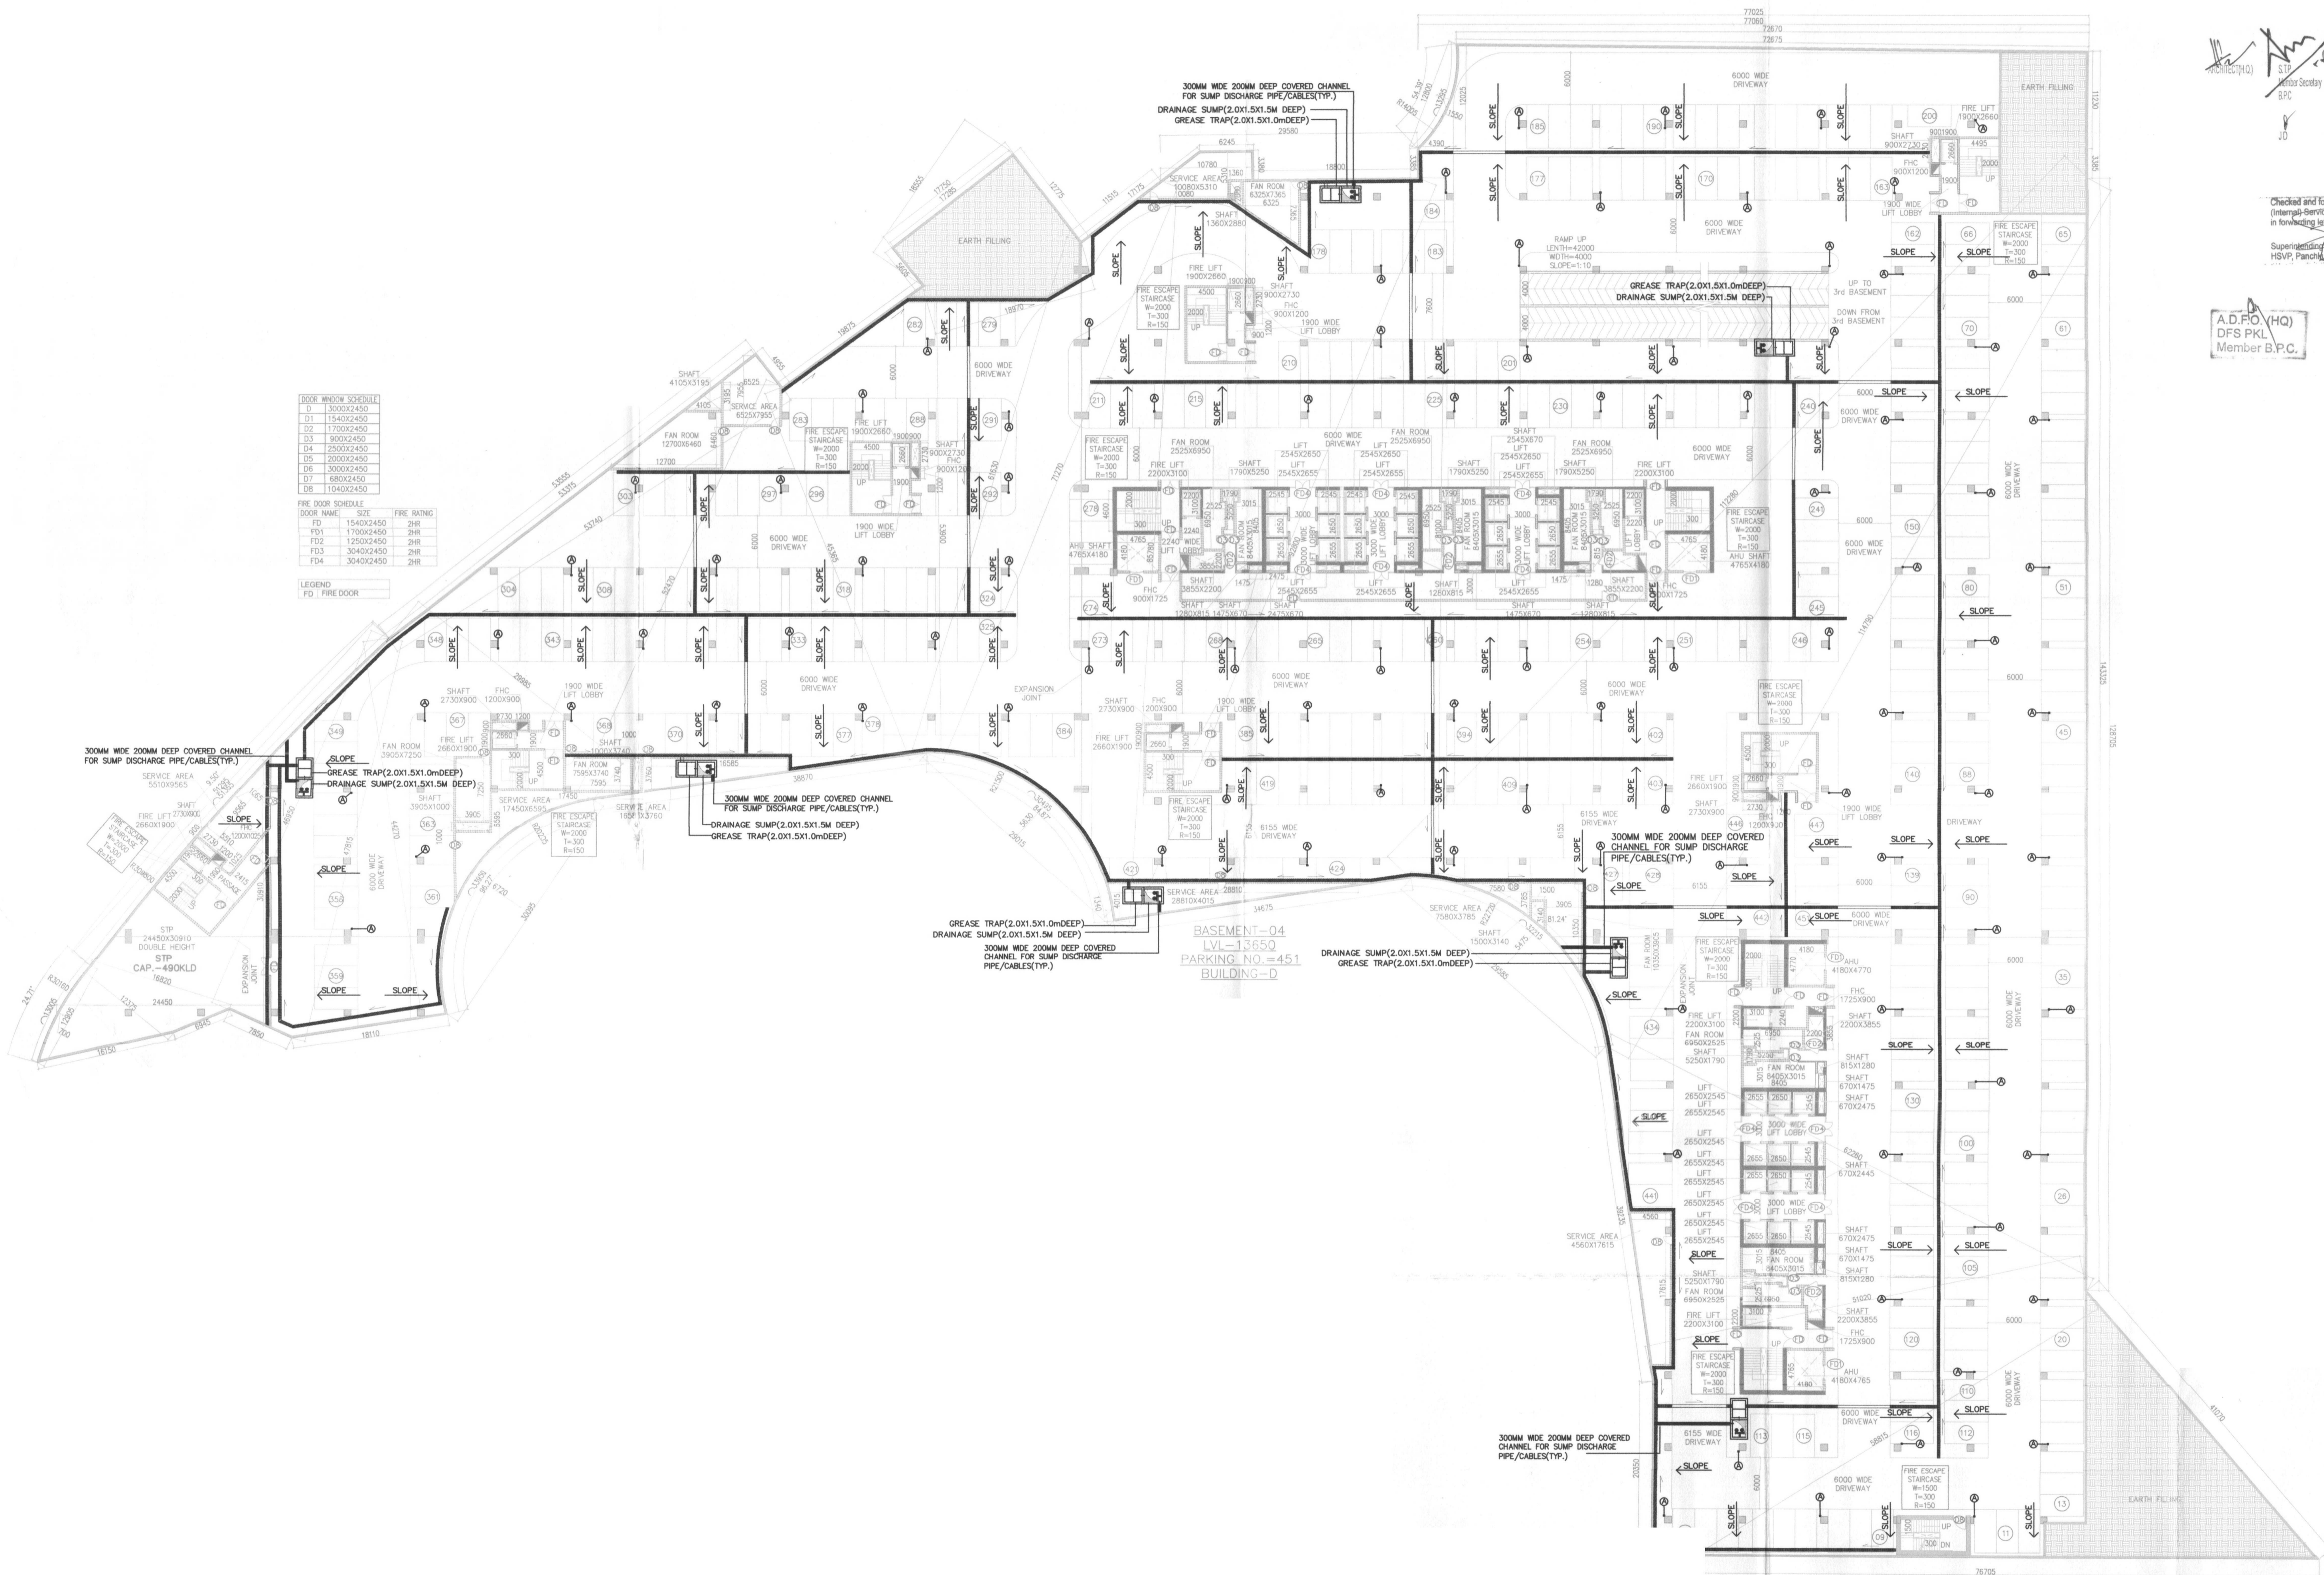

DOOR WINDOW SCHEDULE

D	3000X2450
D1	1540X2450
D2	1700X2450
D3	900X2450
D4	2500X2450
D5	2000X2450
D6	3000X2450
D7	6800X2450
D8	10400X2450

FIRE DOOR SCHEDULE

DOOR NAME	SIZE	FIRE RATING
FD	1540X2450	2HR
FD1	1700X2450	2HR
FD2	1250X2450	2HR
FD3	3040X2450	2HR
FD4	3040X2450	2HR

LEGEND
 FD FIRE DOOR