


KEY PLAN BUILDING - D



DLF45412

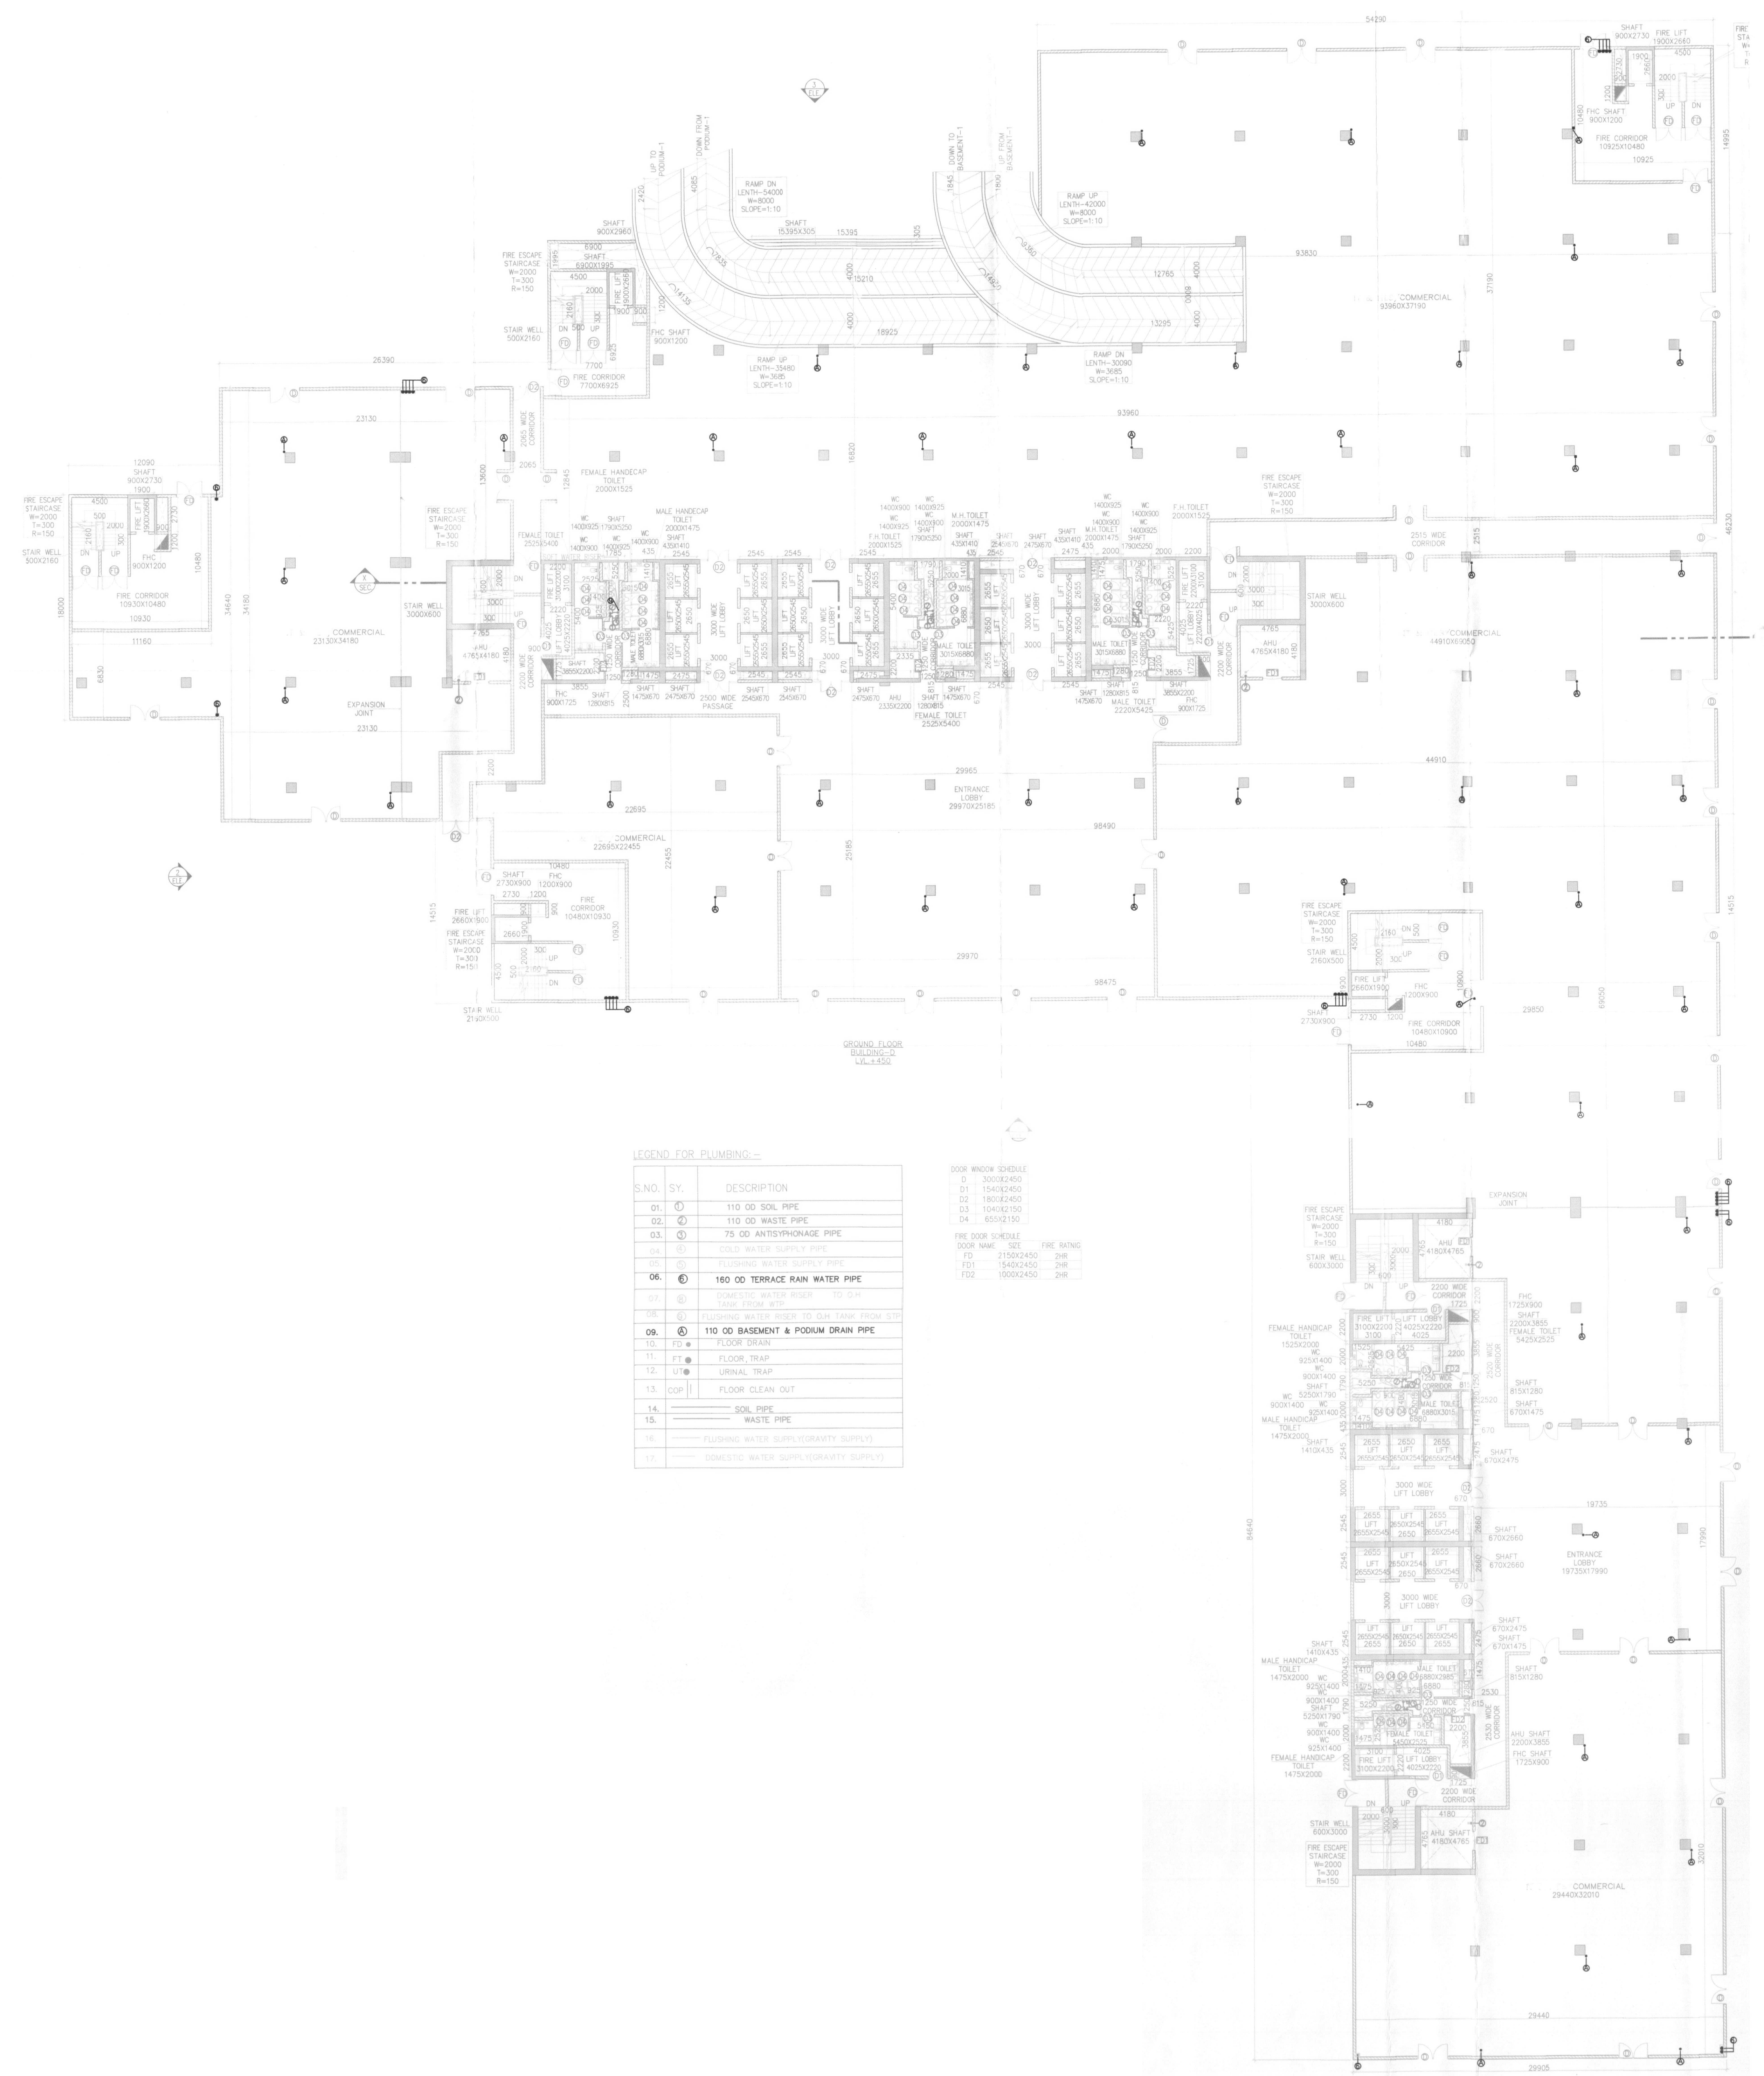

LEGEND FOR PLUMBING -

S.NO.	SY.	DESCRIPTION
01.	①	110 OD SOIL PIPE
02.	②	110 OD WASTE PIPE
03.	③	75 OD ANTISYPHONAGE PIPE
04.	④	COLD WATER SUPPLY PIPE
05.	⑤	FLUOROPOLYMER WASTE SUPPLY PIPE
06.	⑥	160 OD TERRACE RAIN WATER PIPE
07.	⑦	TRAPED HOT WATER RISER TO SH
08.	⑧	TRAPED HOT WATER RISER TO SH FROM RTD
09.	⑨	110 OD BASEMENT & PODIUM DRAIN PIPE
10.	⑩	FLOOR DRAIN
11.	⑪	FLOOR TRAP
12.	⑫	URINAL TRAP
13.	⑬	FLOOR CLEAN OUT
14.	⑭	SOIL PIPE
15.	⑮	WASTE PIPE
16.	⑯	FLUOROPOLYMER WASTE SUPPLY SUPPLY
17.	⑰	COLD WATER SUPPLY SUPPLY

DOOR NAME	SIZE	FINC FINISH
D1	3000x2400	2MR
D2	1800x2400	2MR
D3	1000x2100	2MR
D4	650x2150	2MR

Architect
Hafeez
Contractor
29 Bank Street, Barkey 400 823, Telangana

RSMS ARCHITECTS

RSMS ARCHITECTS PVT. LTD.
69, Nora Niwas, Bhawani Kunj
(Behind D2), Vasant Kunj,
New Delhi-110070.
Tel.: 011-26898616, 26898617
www.rsms-arch.com

Project:
PROPOSED BUILDING PLAN OF BUILDING - C, BUILDING -D, BUILDING -E AND BUILDING -F IN 94.57485 ACRES DLF CYBER CITY, SECTOR 24, 25 & 25A, GURGAON, HARYANA.

OWNER: DLF Cyber City Developers Ltd.
10th Floor DLF Gateway Tower,
DLF Cyber City, Gurugram, Haryana
Pin: 122002

**BUILDING-D
GROUND FLOOR PLAN**
(RAM AVTAR BASIS)

DRG NO. BD-01 NORTH

SCALE: 1:200 DATE: 16-05-2018

FILE: DEALT BY: CHECKED BY: APPROVED BY:

ARCHITECT'S SEAL & SIGNATURE OWNER'S SEAL & SIGNATURE

