



KEY PLAN BUILDING - D

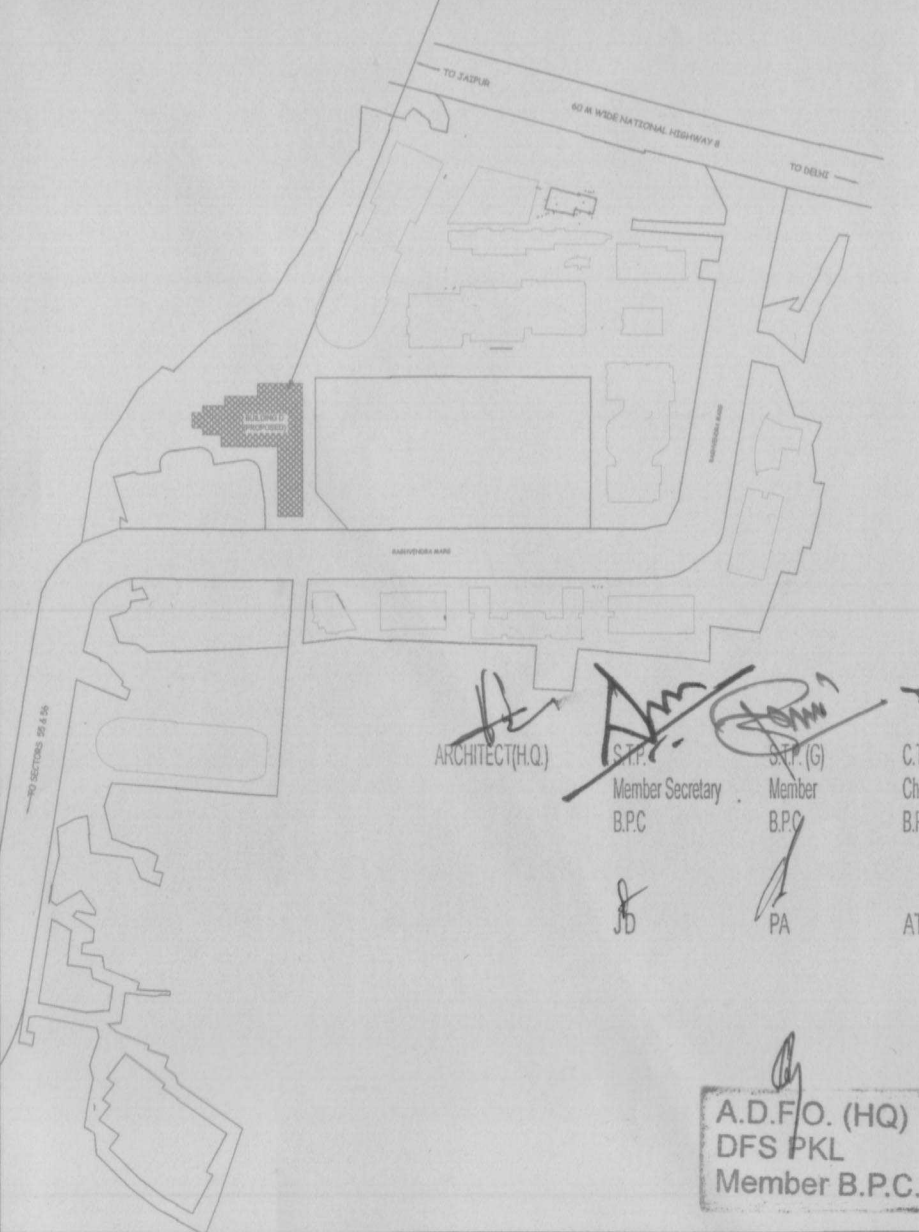

A.D.F.O. (HO)
D.F.S. P.K.L.
Member B.P.C.
(RAM AVTAR BAS)

DLF45414

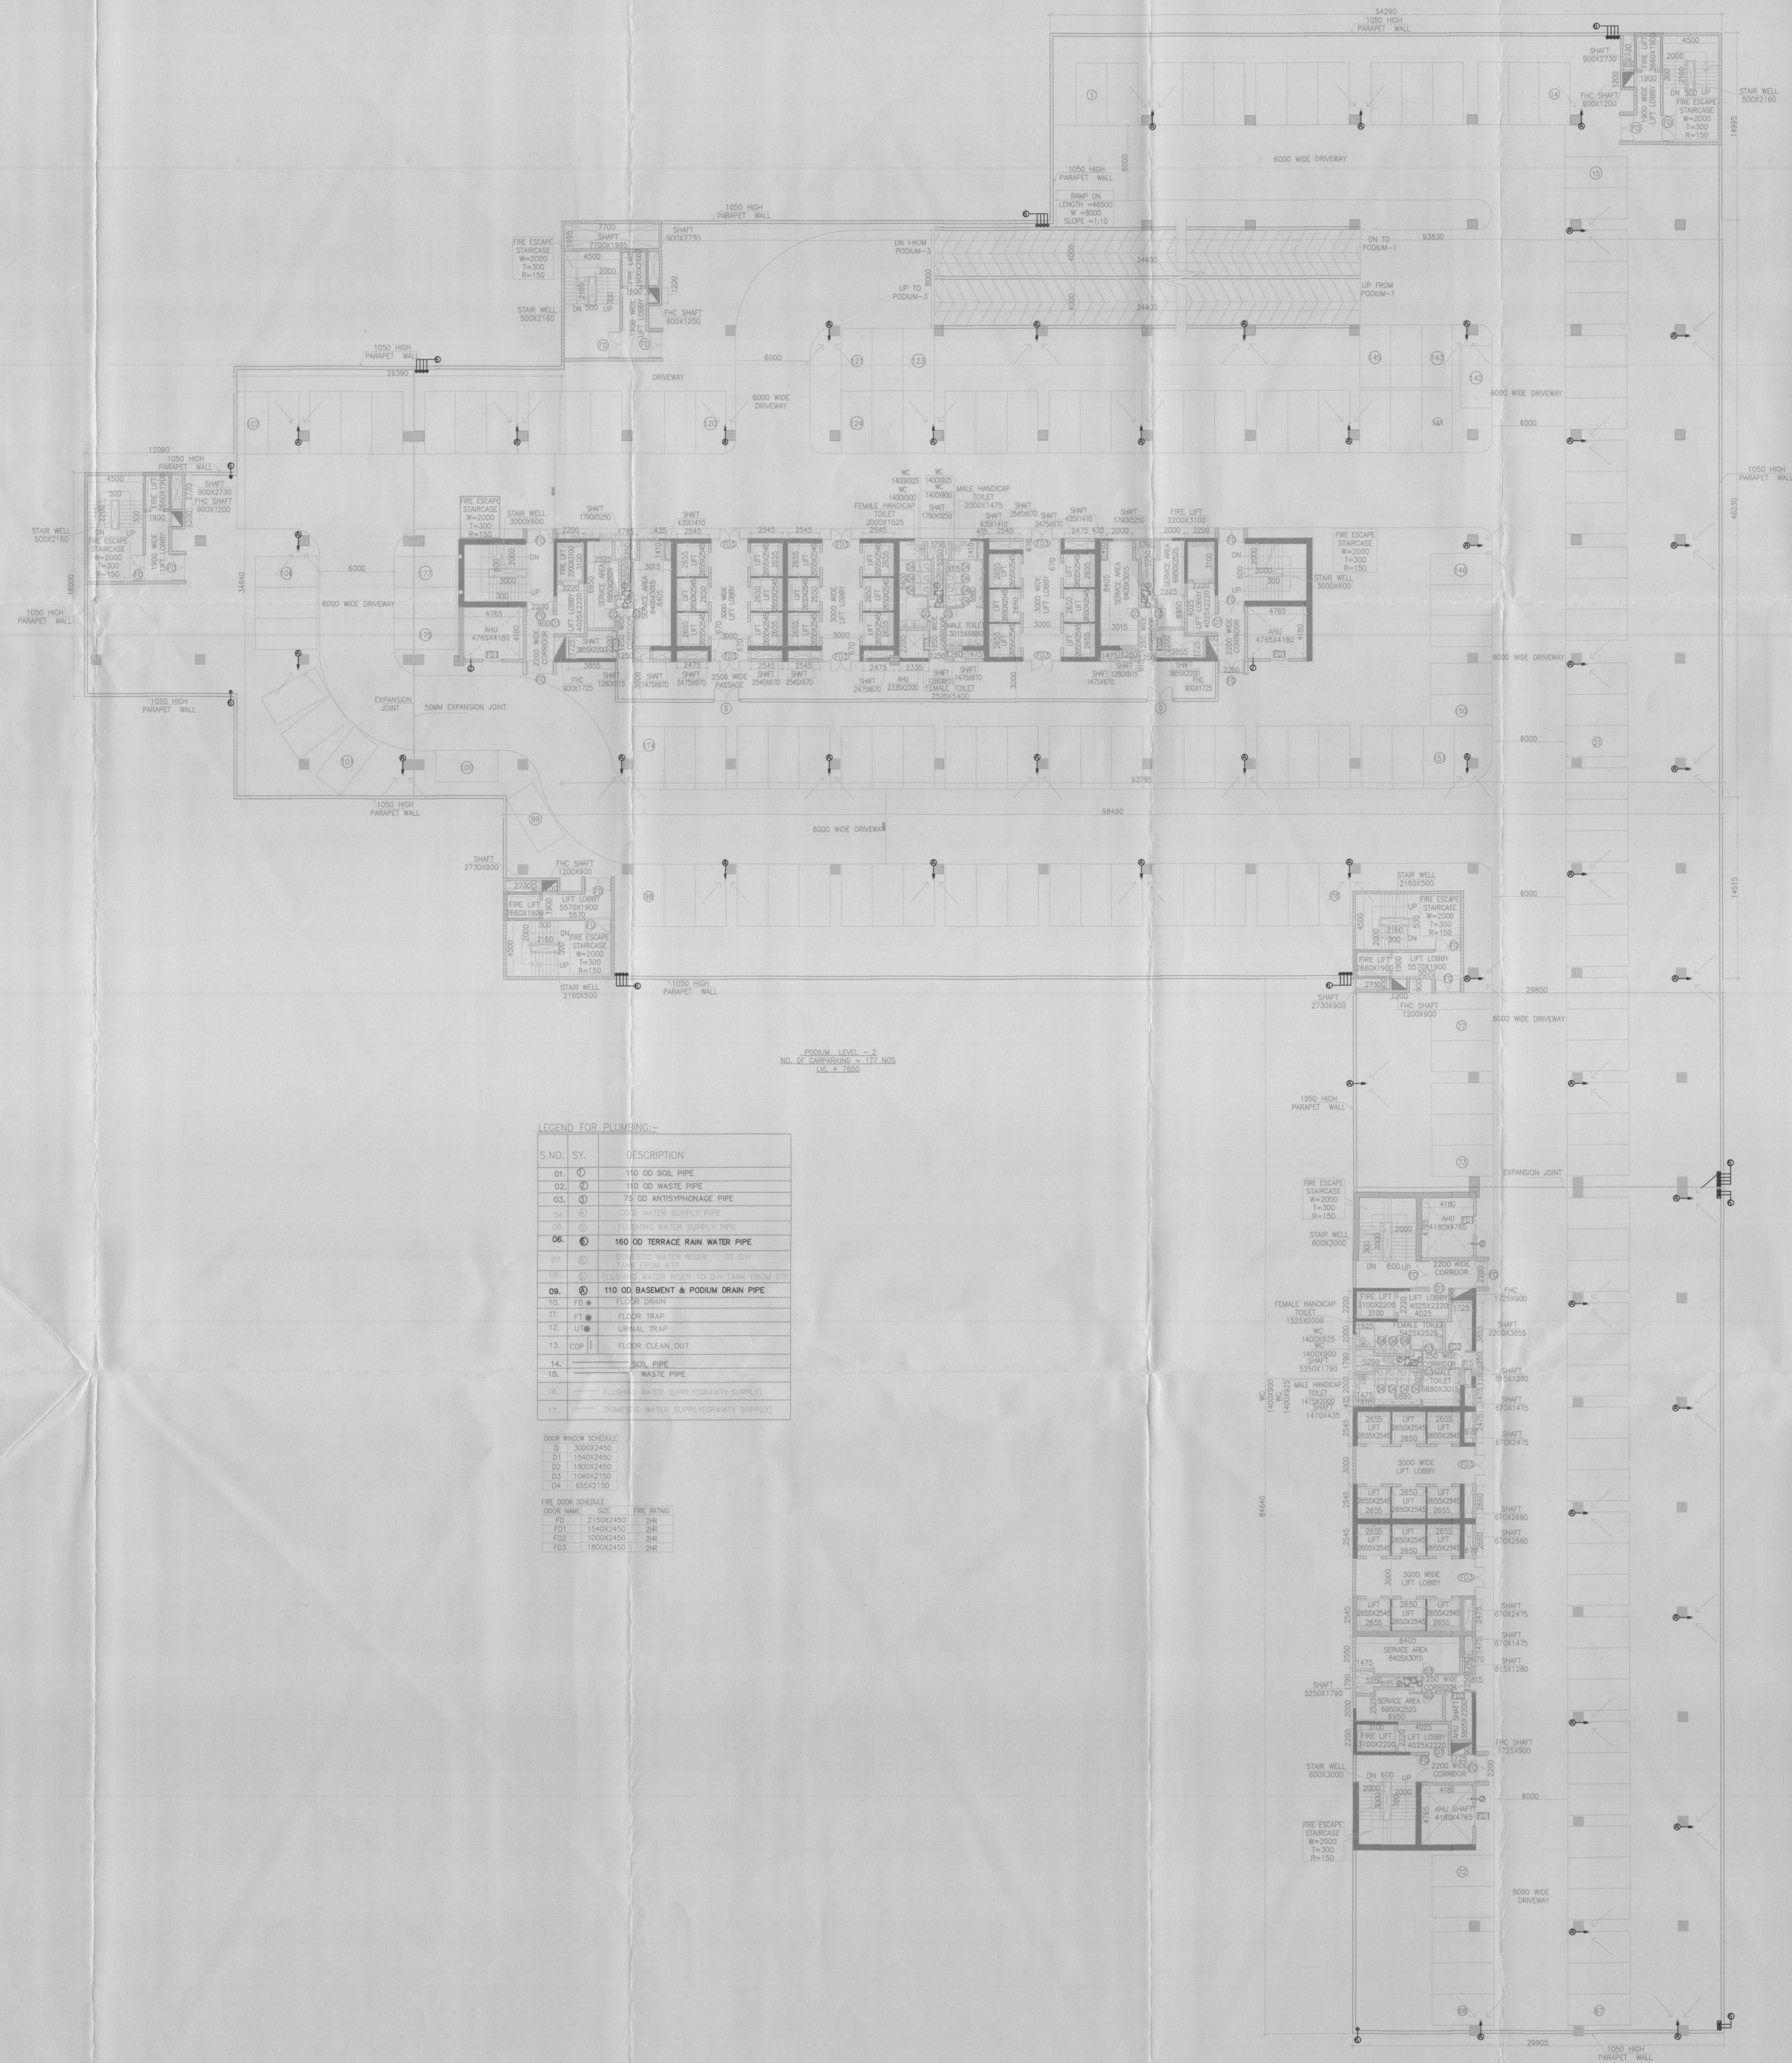

LEGEND FOR PLUMBING:-

S.NO.	SY.	DESCRIPTION
01.	Ø	110 ØØ SOL PIPE
02.	Ø	110 ØØ WASTE PIPE
03.	Ø	75 ØØ ANTI-SYRPHONAGE PIPE
04.	Ø	COLD WATER SUPPLY PIPE
05.	Ø	FLUSHING WATER SUPPLY PIPE
06.	Ø	160 ØØ TERRACE RAIN WATER PIPE
07.	Ø	ØØ ØØ WATER RISER TO BE ON SAME FLOOR FROM STP
08.	Ø	110 ØØ BASEMENT & PODIUM DRAIN PIPE
10.	FT	FLOOR TRAP
11.	UT	URNAL TRAP
13.	COP	FLOOR CLEAN OUT
14.	Ø	SOL PIPE
15.	Ø	WASTE PIPE
16.	Ø	FLUSHING WATER SUPPLY (GRAVITY SUPPLY)
17.	Ø	DRINKING WATER SUPPLY (GRAVITY SUPPLY)

DOOR WINDOW SCHEDULE
D 3000X2400
D1 1500X2400
D2 1800X2400
D3 1000X2150
D4 650X2150

DOOR SCHEDULE	DOOR NAME	DOOR SIZE	DOOR FINISH
FD	FD	2100X2400	2R
F2	F2	1500X2400	2R
F22	F22	1000X2400	2R
F23	F23	1800X2400	2R

Architect Hafeez Contractor
29 Bark Street, Bombay 401 023, India

R/S/M/S ARCHITECTS

R/S/M/S ARCHITECTS PVT. LTD.
69, Nora Niwas, Bhawani Kunj
(Behind D2), Vasant Kunj,
New Delhi-110070.
Tel.: 011-26898616, 26898617
www.rsms-arch.com

Project:
PROPOSED BUILDING PLAN OF BUILDING - C, BUILDING - D, BUILDING - E AND BUILDING - F IN 94.57485 ACRES DLF CYBER CITY, SECTOR 24, 25 & 25A, GURGAON, HARYANA.

OWNER: DLF Cyber City Developers Ltd.
DLF 10th Floor DLF Gateway Tower,
DLF Cyber City, Gurugram, Haryana
Pin: 122002

DRAWING TITLE:-
Detailed and Modified NOT FOR CONSTRUCTION
(owner's approval is subject to compliance with all applicable laws and regulations)
PODIUM PLAN-02

REVISION	JOB NO.:-	DRG NO. BD-03	NORTH:-
			N
	SCALE:- 1:100	DATE:- 16-05-2018	
FILE:-	DEALT BY:-	CHECKED BY:-	APPROVED BY:-
ARCHITECT'S SEAL & SIGNATURE		OWNER'S SEAL & SIGNATURE	

