


DLF45416

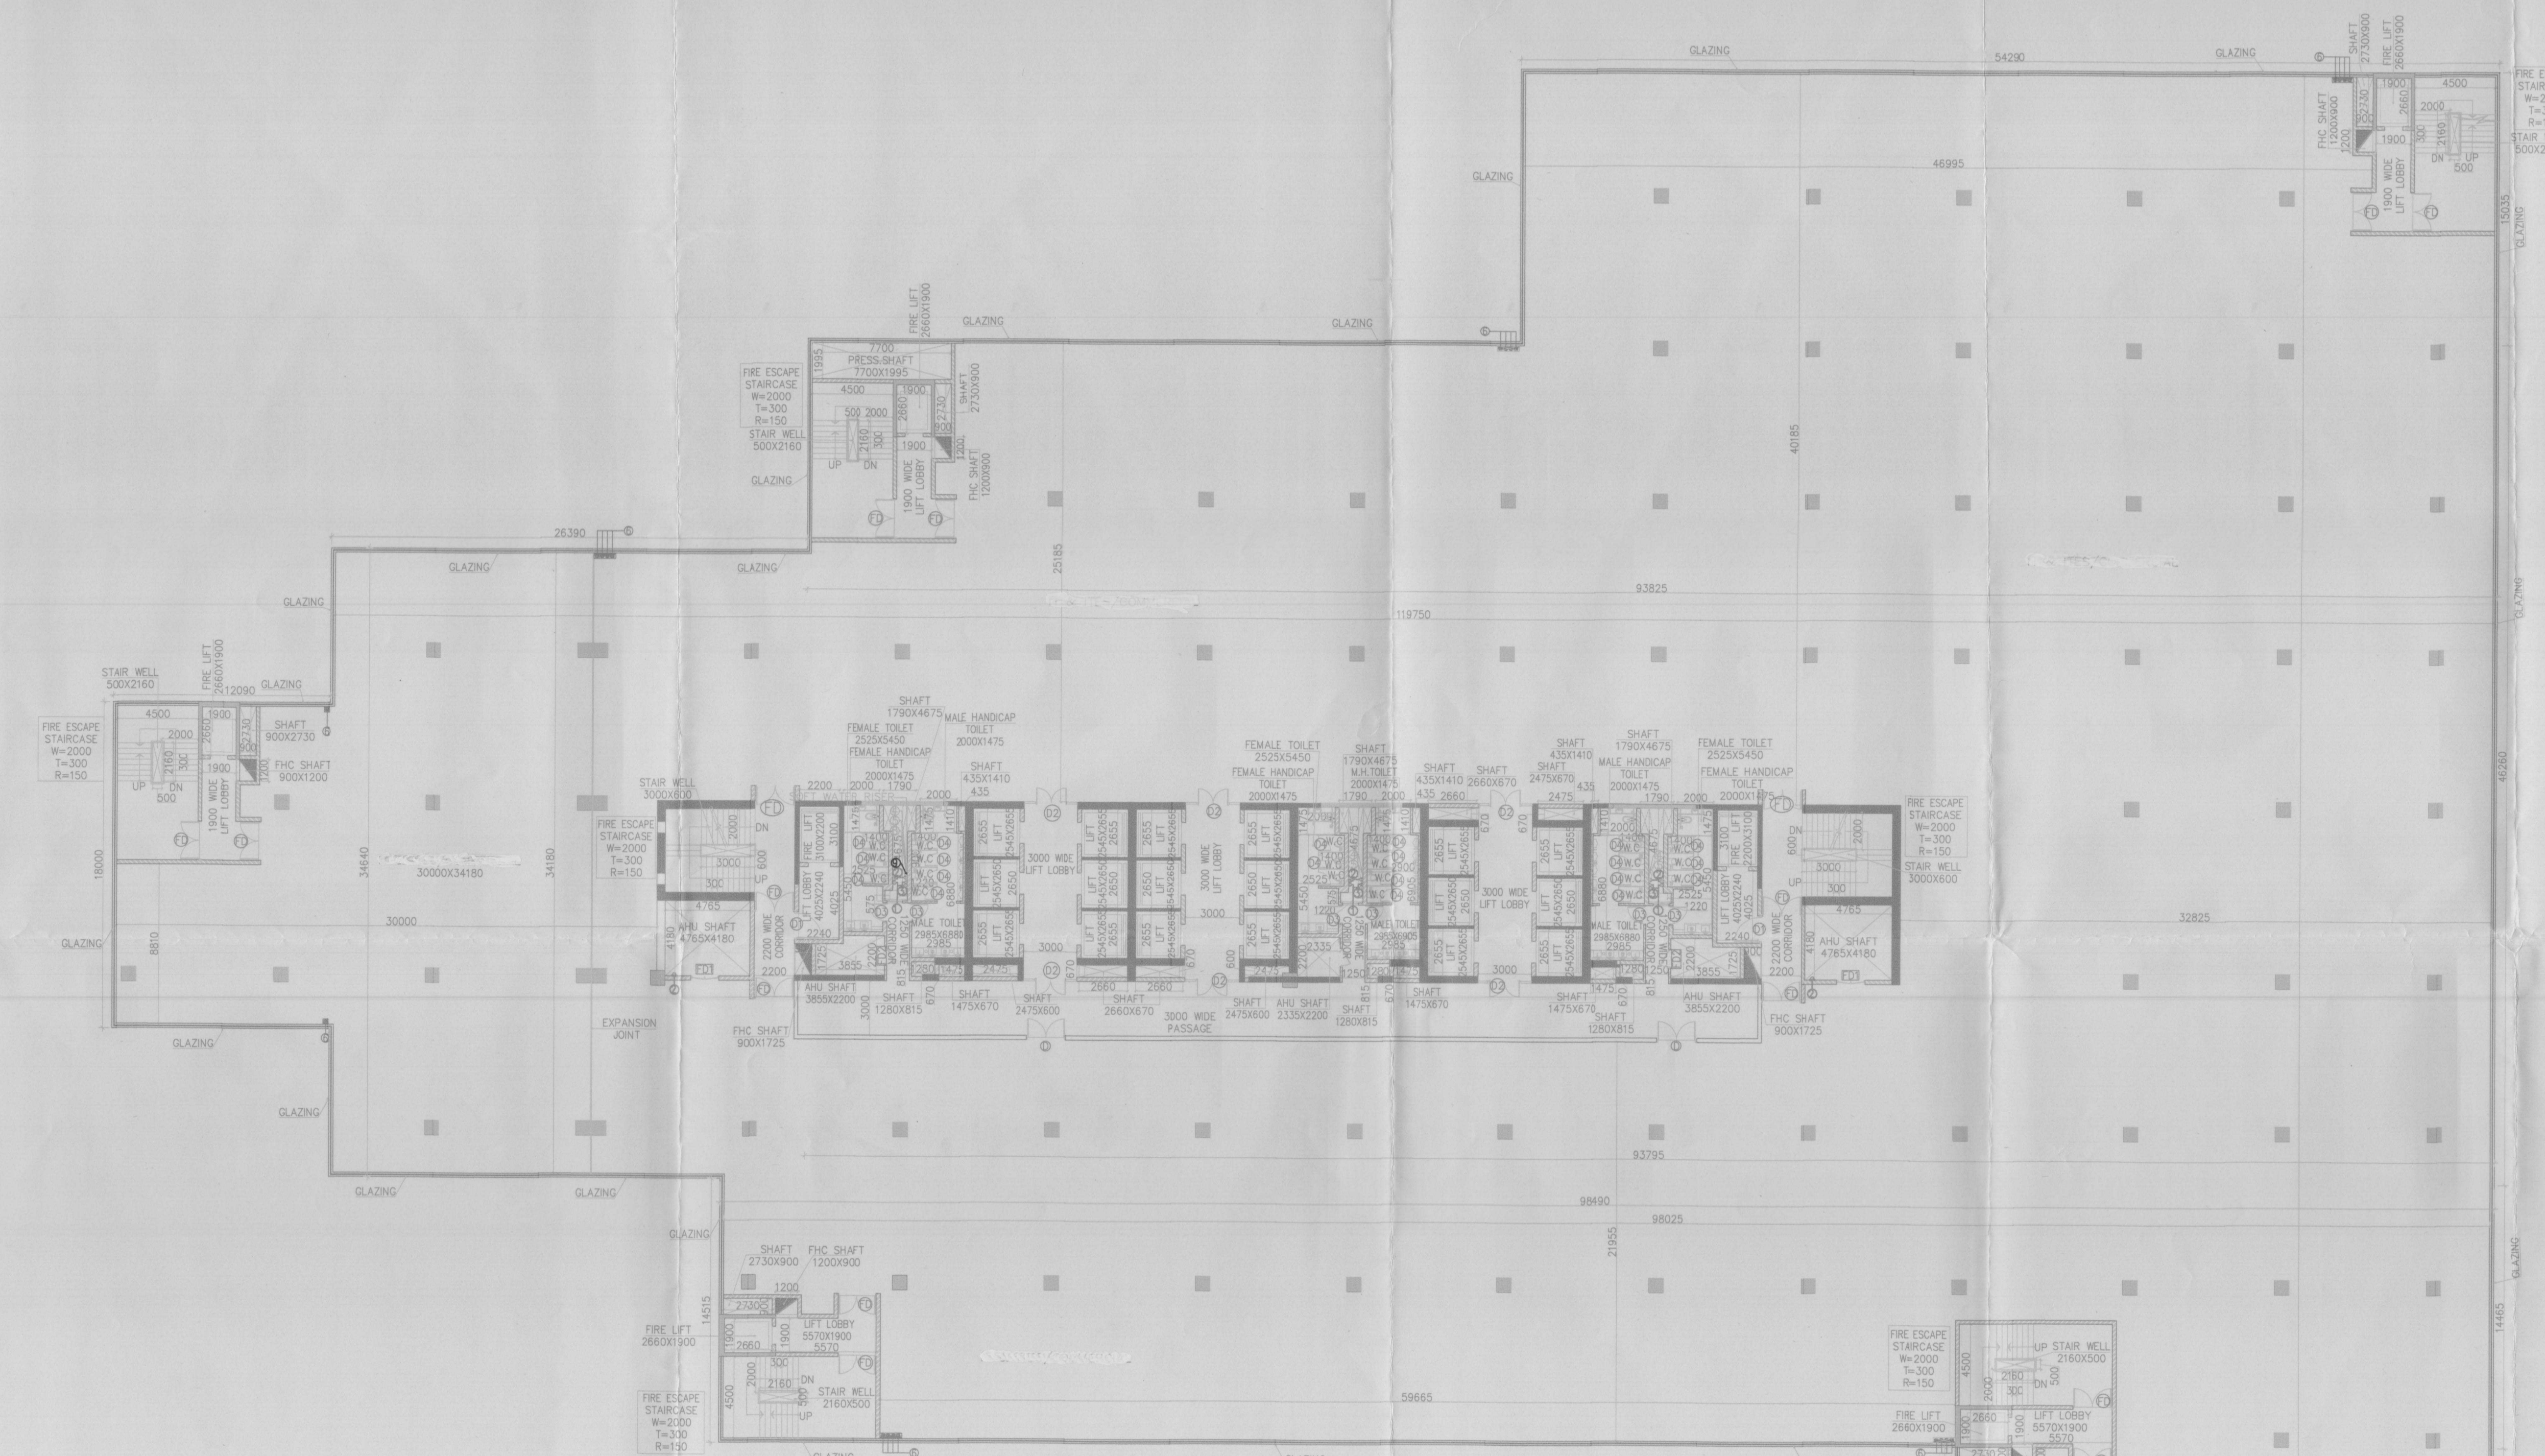

LEGEND FOR PLUMBING -

S.NO.	SY.	DESCRIPTION
01.	①	110 ØØ SOIL PIPE
02.	②	110 ØØ WASTE PIPE
03.	③	75 ØØ ANTI-SIPHONAGE PIPE
04.	④	COLD WATER SUPPLY PIPE
05.	⑤	FLOODING WATER SUPPLY PIPE
06.	⑥	150 ØØ TERRACE RAIN WATER PIPE
07.	⑦	DOMESTIC WATER RISER TO C.H. TANK FROM STD.
08.	⑧	FLOODING WATER RISER TO C.H. TANK FROM STD.
09.	⑨	110 ØØ BASEMENT & PODIUM DRAIN PIPE
10.	⑩	FLOOR DRAIN
11.	⑪	FLOOR TRAP
12.	⑫	URINAL TRAP
13.	⑬	FLOOR CLEAN OUT
14.	⑭	SOIL PIPE
15.	⑮	WASTE PIPE
16.	⑯	FLOODING WATER SUPPLY (GRAVITY SUPPLY)
17.	⑰	DOMESTIC WATER SUPPLY (GRAVITY SUPPLY)

(BUILDING-D)

FLOOR	LEVEL	USE
4th	+13.650	COMMERCIAL-1
5th	+17.850	COMMERCIAL-2
6th	+22.050	COMMERCIAL-3
8th	+34.850	COMMERCIAL-4
9th	+38.850	COMMERCIAL-5
10th	+42.250	COMMERCIAL-6
12th	+47.250	IT & RES/ COMMERCIAL-7

DOOR WINDOW SCHEDULE

DOOR NO.	DOOR SIZE	DOOR TYPE
D1	3000x2400	2DR
D2	1500x2400	2DR
D3	1000x2400	2DR
D4	600x1900	2DR

FIRE DOOR SCHEDULE

DOOR NO.	DOOR SIZE	FIRE RATING
FD1	2100x2400	2HR
FD2	1500x2400	2HR
FD3	1000x2400	2HR

Architect
Hafeez
Contractor
29 Bank Street, Bombay 400 023, India

RISMS ARCHITECTS

RSMS ARCHITECTS PVT. LTD.
69, Nara Niwas Bhawani Kunj
(Behind D2), Vasant Kunj,
New Delhi-110070.
Tel: 011-26898616, 26898617
www.rsms-arch.com

Project:
PROPOSED BUILDING PLAN OF BUILDING - C, BUILDING - D, BUILDING - E AND BUILDING - F IN 94.57485 ACRES DLF CYBER CITY, SECTOR 24, 25 & 25A, GURGAON, HARYANA.

OWNER: DLF Cyber City Developers Ltd.
DLF 10th Floor DLF Gateway Tower,
DLF Cyber City, Gurugram, Haryana
Pin: 122002

DRAWING TITLE: -
BUILDING-D
TYPICAL (4TH, 5TH, 6TH, 8TH, 9TH, 10TH & 12TH) FLOOR PLAN

REVISION	JOB NO. -	DRG NO. -	NORTH -
		BD-05	
	SCALE -	DATE -	
	1:200	16-05-2018	
FILE -	DEALT BY -	CHECKED BY -	APPROVED BY -
ARCHITECT'S SEAL & SIGNATURE	OWNER'S SEAL & SIGNATURE		

