



KEY PLAN BUILDING - D

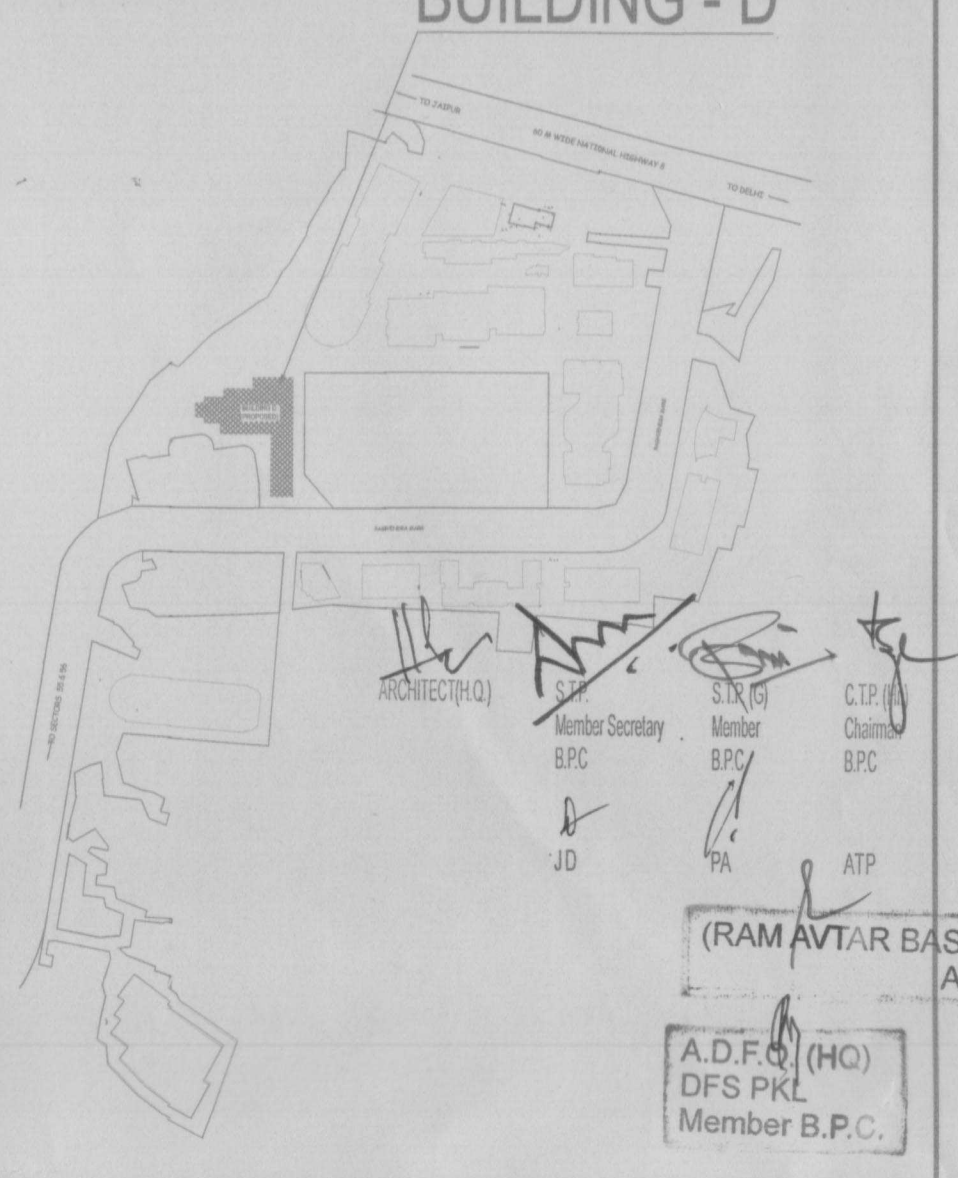

DLF45418

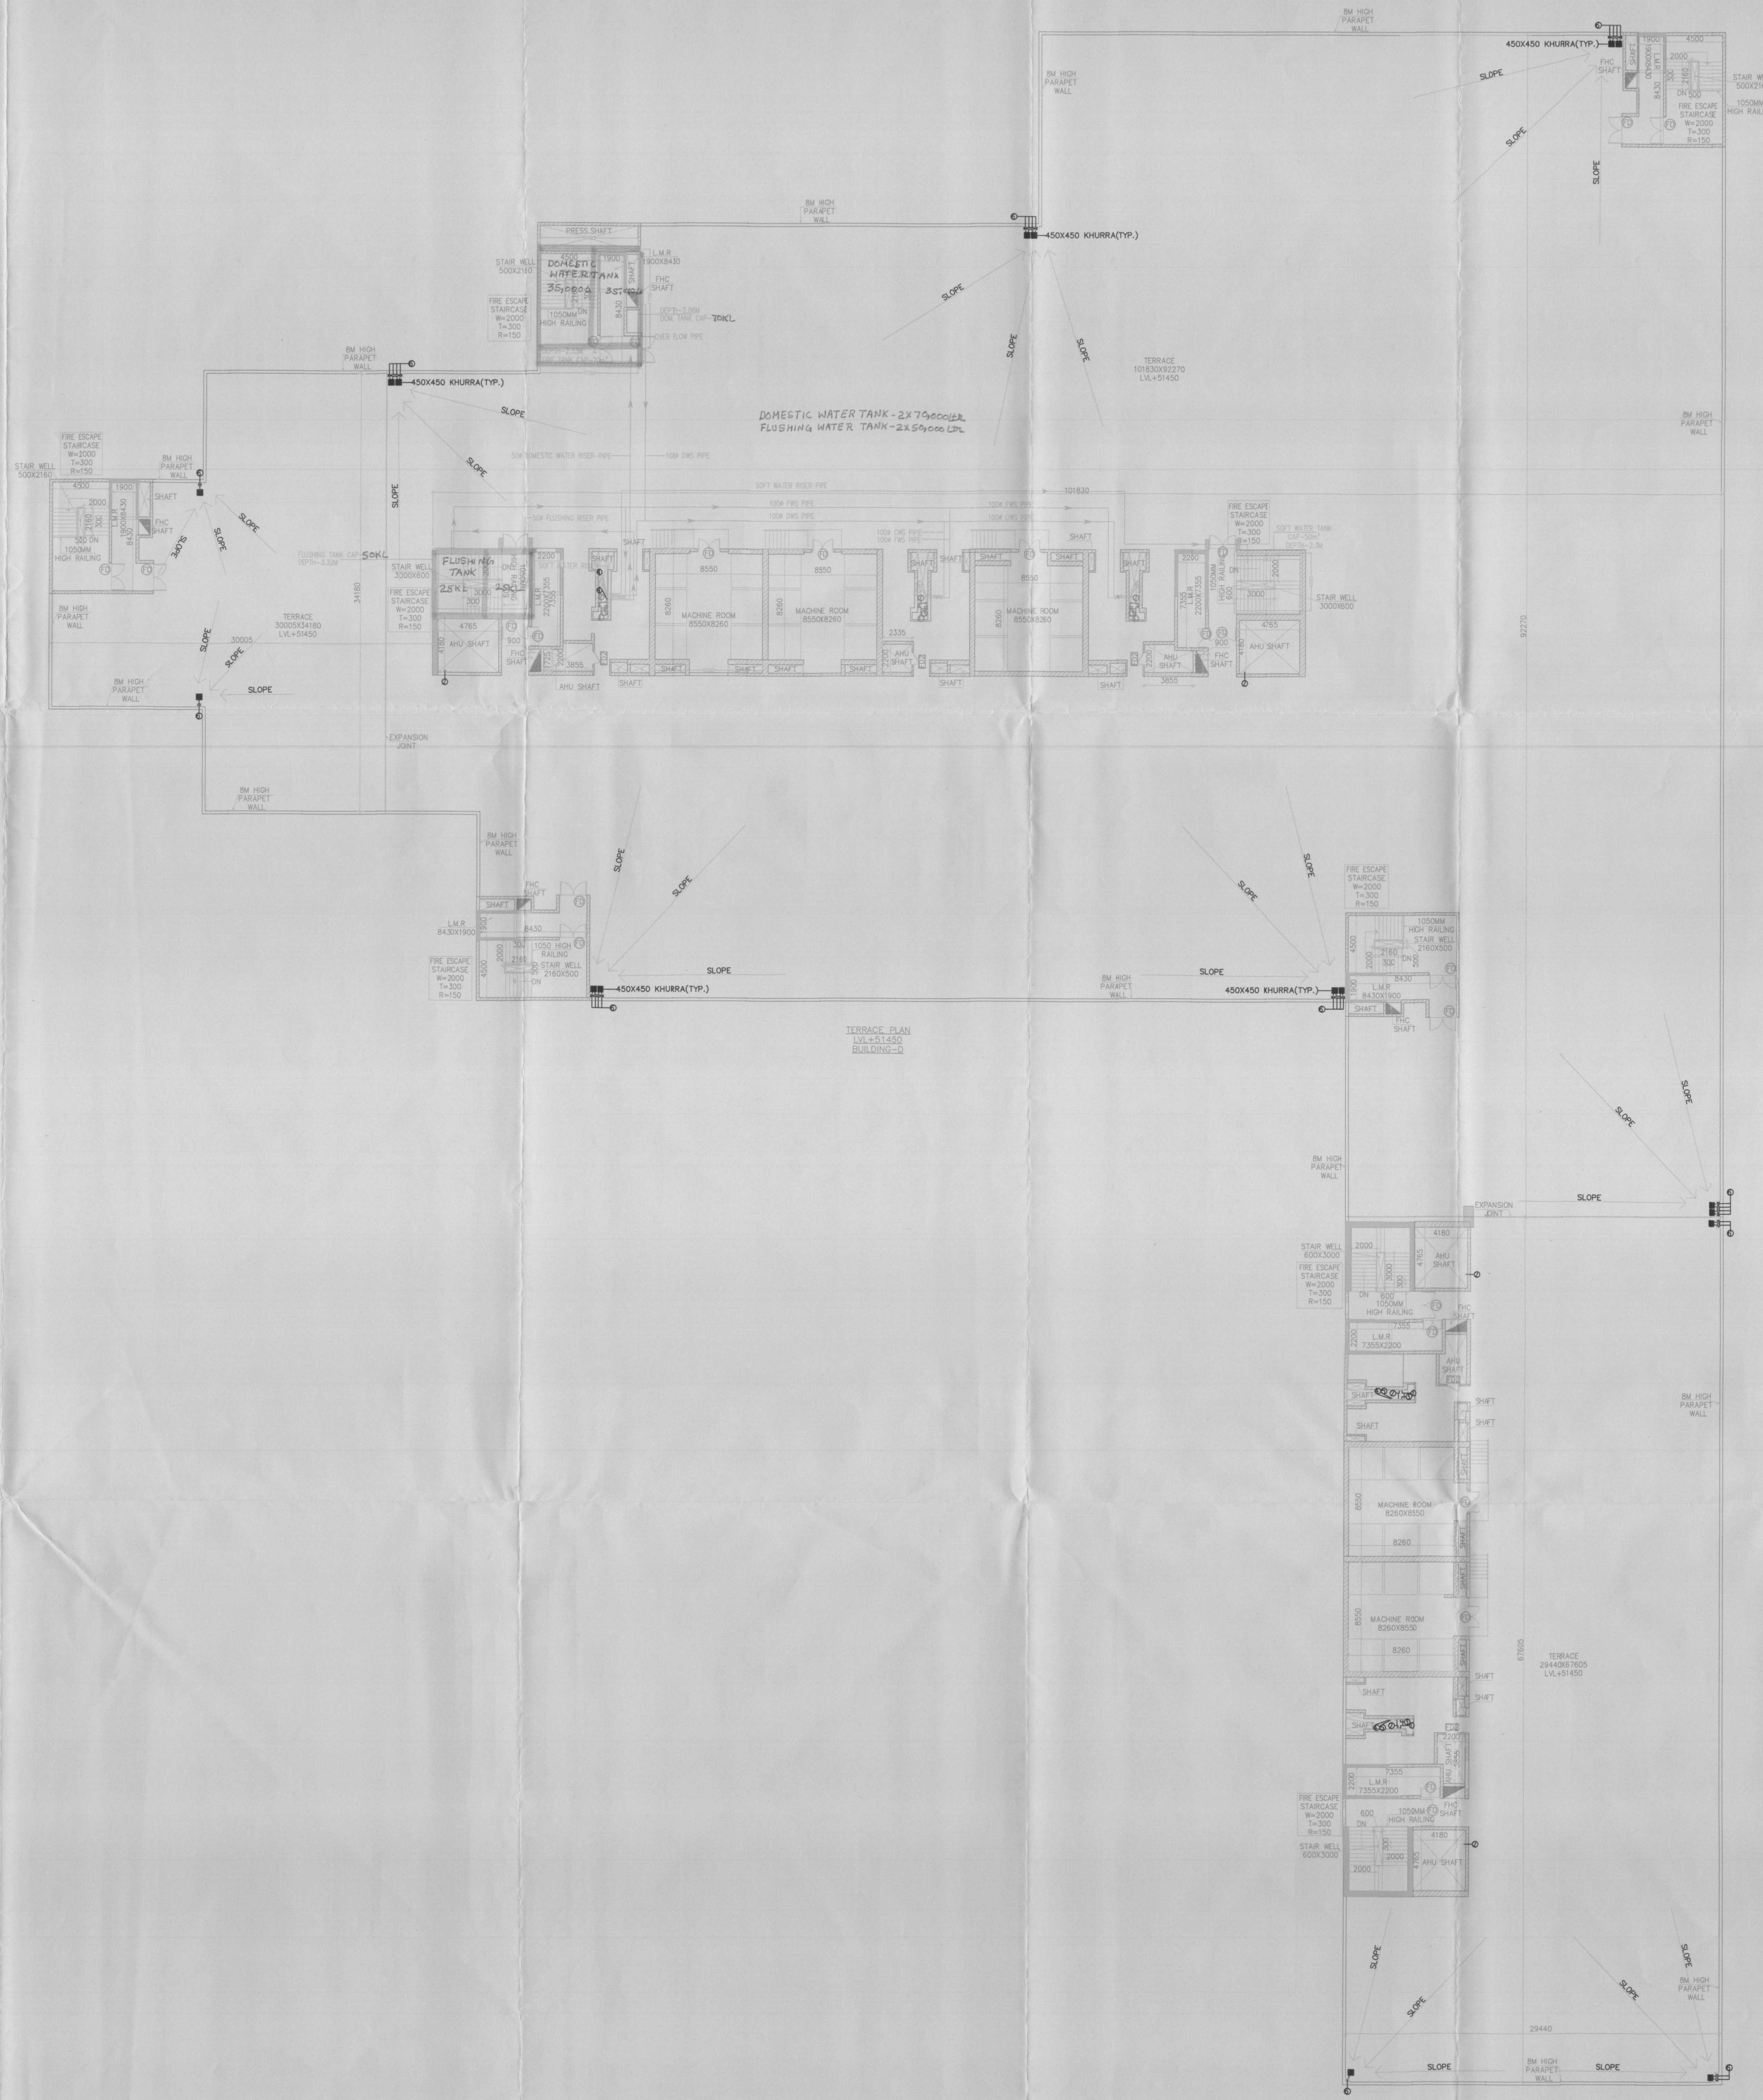

LEGEND FOR PLUMBING -

S.NO.	SY.	DESCRIPTION
01	⊙	110 OD SOIL PIPE
02	⊙	110 OD WASTE PIPE
03	⊙	75 OD ANTI-SIPHONAGE PIPE
04	⊙	COLD WATER SUPPLY PIPE
05	⊙	TERRACE RAIN WATER PIPE
06	⊙	160 OD TERRACE RAIN WATER PIPE
07	⊙	DOMESTIC WATER PRESS. TO DM TANK FROM WPT
08	⊙	FLUSHING WATER PRESS. TO DM TANK FROM WPT
09	⊙	110 OD BASEMENT & POCUM DRAIN PIPE
10	FD	FLOOR DRAIN
11	FT	FLOOR TRAP
12	UT	URINAL TRAP
13	CDP	FLOOR CLEAN OUT
14	—	SOIL PIPE
15	—	WASTE PIPE
16	—	FLUSHING WATER SUPPLY (GRAVITY SUPPLY)
17	—	DOMESTIC WATER SUPPLY (GRAVITY SUPPLY)

DOOR SCHEDULE

DOOR	W&E	FIN	REMARKS
FD	1500x2450	20R	
FD1	1500x2450	20R	
FD2	1000x2450	20R	

LEGEND
FD FIRE DOOR

Architect
Hafeez
Contractor
29 Bank Street, Bombay 400 023 Tel:266929



RSMS ARCHITECTS PVT. LTD.
69, Nara Niwas Bhawanij Kunj
(Behind D2), Vasant Kunj,
New Delhi-110070.
Tel.: 011-26898616, 26898617
www.rsms-arch.com

Project:
PROPOSED BUILDING PLAN OF BUILDING - C, BUILDING - D, BUILDING - E AND BUILDING - F IN 94.57485 ACRES DLF CYBER CITY, SECTOR 24, 25 & 25A, GURGAON, HARYANA.

OWNER: DLF Cyber City Developers Ltd.
10th Floor DLF Gateway Tower,
DLF Cyber City, Gurugram, Haryana
Pin: 122002

DRAWING TITLE: BUILDING-D TERRACE PLAN
Checked and signed as per P&E from
Owner's Service by Architect
16/12/18

REVISION	JOB NO. -	DRG NO.	NORTH -
		BD-07	N
	SCALE -	DATE -	
	1:200	16-05-2018	

FILE - DEALT BY - CHECKED BY - APPROVED BY -

ARCHITECT'S SEAL & SIGNATURE
OWNER'S SEAL & SIGNATURE

