


KEY PLAN

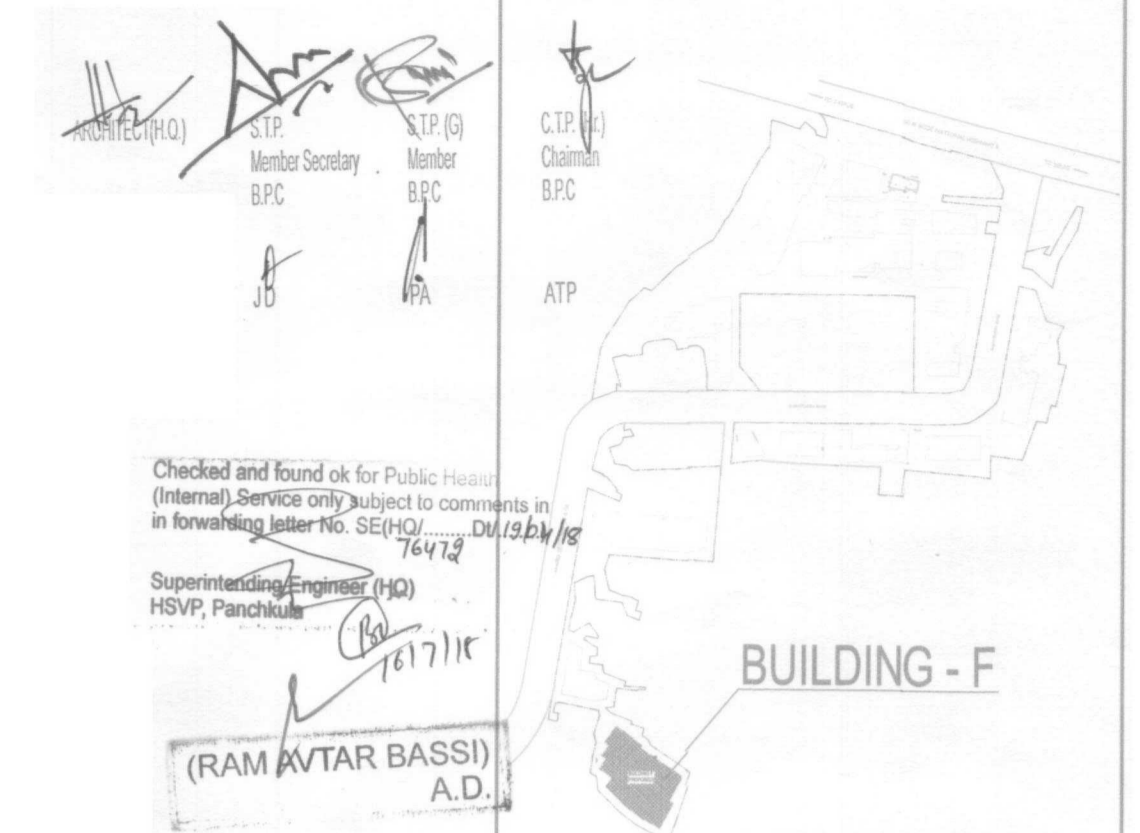

Checked and found ok for Public Health (Internal Services only) subject to comments in forvalting letter to SEPCO. DLF/2018/18  
 Supervising Engineer (H2) HSPV, Panchajanya  
 (RAM AVTAR BASSI) A.D.

BUILDING - F

A.D.F.O. (HQ) DFS PKL Member B.P.C.

DLF45445

Architect Hafeez Contractor  
 29 Bank Street, Bombay 400 023. Tel:2661920

RSMS ARCHITECTS

RSMS ARCHITECTS PVT. LTD.  
 69, Nara Niwas, Bhawani Kunj (Behind D2), Vasant Kunj, New Delhi-110070.  
 Tel.: 011-26898616, 26898617  
 www.rsms-arch.com


Project: PROPOSED BUILDING PLAN OF BUILDING - C, BUILDING -D, BUILDING -E AND BUILDING -F IN 94.57485 ACRES DLF CYBER CITY, SECTOR 24, 25 & 25A, GURGAON, HARYANA.

OWNER: DLF Cyber City Developers Ltd. 10th Floor DLF Gateway Tower, DLF Cyber City, Gurugram, Haryana Pin:122002

DRAWING TITLE: BUILDING-F SITE PLAN (IRRIGATION SCHEME & STORM SCHEME.)

REVISION	JOB NO. 1-900	DRG NO. BFST-02	NORTH
FILE	SCALE	DATE: 16-05-2018	
DEALT BY	CHECKED BY	APPROVED BY	

ARCHITECT'S SEAL & SIGNATURE  
 OWNER'S SEAL & SIGNATURE

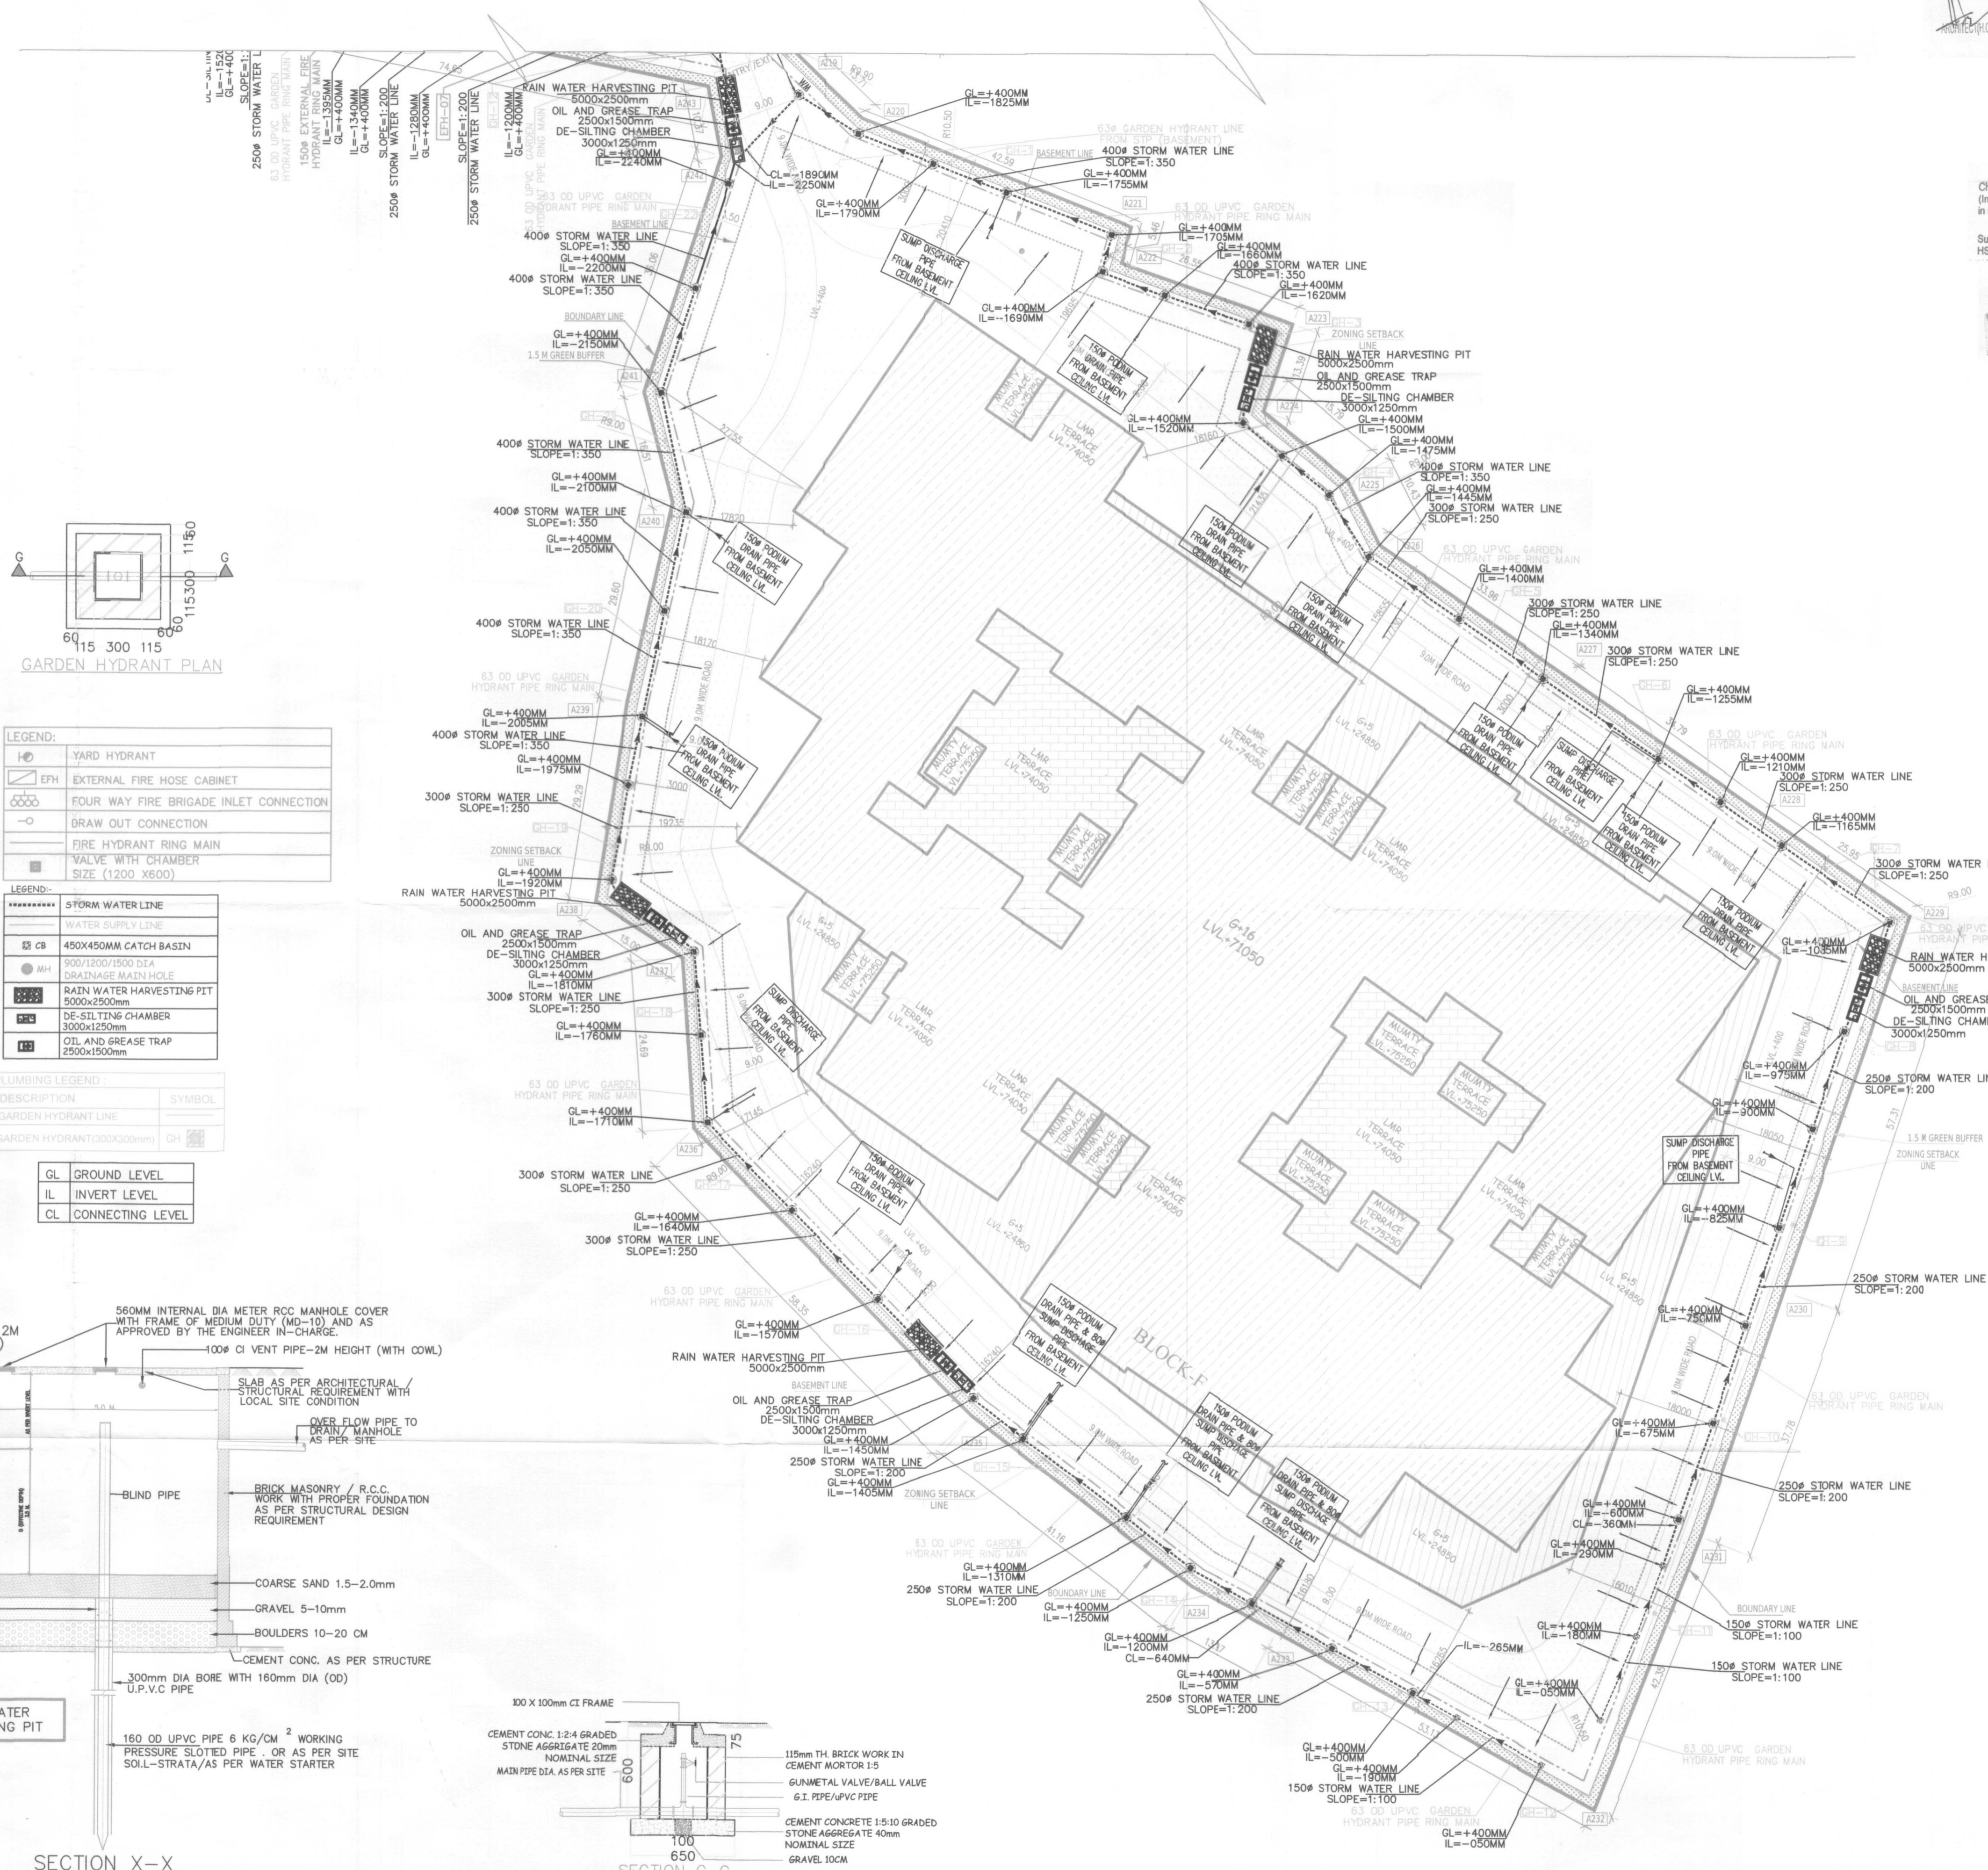

LEGEND:

	YARD HYDRANT
	EXTERNAL FIRE HOSE CABINET
	FOUR WAY FIRE BRIGADE INLET CONNECTION
	DRAW OUT CONNECTION
	FIRE HYDRANT RING MAIN
	VALVE WITH CHAMBER
	SIZE (1200 X 600)

LEGEND:

	STORM WATER LINE
	WATER SUPPLY LINE
	450X450MM CATCH BASIN
	900/1200/1500 DIA 1200x1200mm MANHOLE
	RAIN WATER HARVESTING PIT
	DE-SILTNG CHAMBER
	OIL AND GREASE TRAP

PLUMBING LEGEND

DESCRIPTION	SYMBOL
GARDEN HYDRANT LINE	
GARDEN HYDRANT(300x300mm)	

GL GROUND LEVEL  
 IL INVERT LEVEL  
 CL CONNECTING LEVEL

