


This is a PROFESSIONAL BUILDING PLAN approved only for the purpose of obtaining objections from the general public.

Handwritten signatures and stamps:
 Approved by: [Signature]
 Approved by: [Signature]
 Approved by: [Signature]

Note :-

- BUILDING HAS AUTOMATIC SPRINKLER SYSTEM AS REQUIRED BY NBC.
- BUILDING WILL BE DESIGNED (STRUCTURES) AS PER RELEVANT IS CODES FOR EARTH QUAKE RESISTANCE.
- BUILDING IS ARTIFICIALLY LIGHTED MECHANICALLY VENTILATED & CENTRALLY AIRCONDITIONED WITH 100% POWER BACKUP.

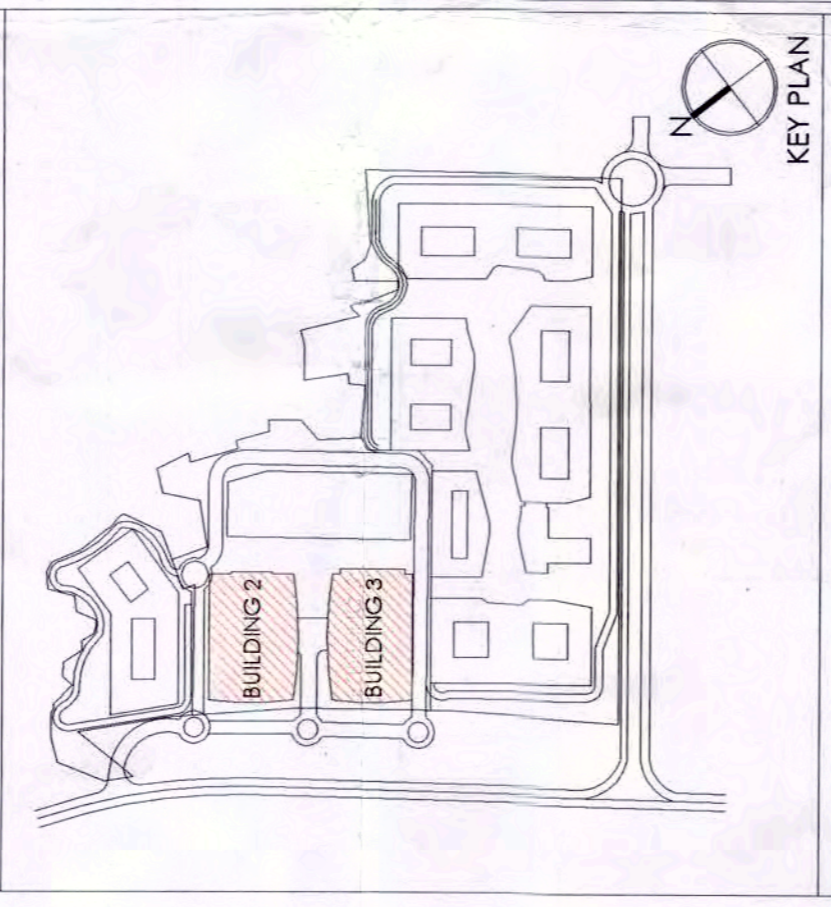

LEGEND FOR PLUMBING:

S.NO.	SYMBOL	DESCRIPTION
01	○	110 OD SOIL PIPE
02	○	110 OD WASTE PIPE
03	○	75 OD ANTISHOCK PIPE
04	○	DOMESTIC WATER SUPPLY HYDROPNAMATIC
05	○	DOMESTIC WATER SUPPLY HYDROPNAMATIC
06	○	FLUSHING WATER SUPPLY HYDROPNAMATIC
07	○	180 OD TERRACE RAIN WATER PIPE
08	○	110 OD BALCONY/BALCONY RAIN WATER PIPE
09	○	FLOOR DRAIN
10	○	FLOOR TRAP
11	○	URINAL TRAP
12	○	CLEAN OUT PLUG
13	○	SOIL PIPE
14	○	WASTE PIPE
15	○	RAIN WATER PIPE
16	○	DOMESTIC WATER PIPE
17	○	FLUSHING WATER PIPE

Architects:
Arcop Associates Pvt. Ltd.
 Plot- 36b, Sec-32, Gurgaon-122001
 Ph: +91-124-4955500 FAX: +91-124-4955500
 Montreal, Toronto, New-Delhi, Boston

Project:
 PROPOSED REVISED BUILDING PLAN OF COMMERCIAL COLONY AREA MEASURING 32.36 ACRES PART OF RESIDENTIAL PLOTTED COLONY NAMELY DLF CITY PHASE III AND INDEPENDENT COMMERCIAL COLONY 4.00 ACRES (LICENCE NO.59 OF 2018 DATED 07.08.2018) BY MAKING TOTAL AREA MEASURING 36 ACRES UNDER TOWN ZONE IN SECTOR 24 & 25A GURGRAM MANESAR URBAN COMPLEX BEING DEVELOPED BY DLF LIMITED AND OTHERS.

DRAWING TITLE:-
SITE PLAN
PLUMBING LAYOUT

DRG NO: PC-DLF-SITE-CO-PL-01
 DATE: -
 SCALE: 1:400
 FILE: -
 CHECKED BY: APPROVED
 ARCHITECT'S SEAL & SIGNATURE
 OWNER'S SEAL & SIGNATURE

PLUMBING & FIRE FIGHTING LEGEND:-

S.NO.	DESCRIPTION	SYMBOL
1.	EXTERNAL SEWER LINE	—
2.	EXTERNAL SURFACE DRAINAGE LINE	—
3.	EXTERNAL STORM WATER LINE	—
4.	EXTERNAL FIRE HYDRANT LINE	—
5.	EXTERNAL DOMESTIC WATER LINE	—
6.	EXTERNAL FLUSHING WATER LINE	—
7.	EXTERNAL GARDEN HYDRANT LINE	—
8.	100Ø HSPV/GMDA WATER LINE	—
9.	TANKER LINE	—
10.	FIRE HYDRANT (EFHC)	—
11.	GARDEN HYDRANT (GH)	—
12.	VALVE	—
13.	STORM WATER MANHOLE	—
14.	SEWER MANHOLE	—
15.	RAIN WATER HARVESTING PIT	—
16.	DE-SILTING CHAMBER	—
17.	OIL & GREASE SEPARATOR	—

S.NO.	PIPE SIZE	SLOPE OF PIPE
①	SURFACE STORM WATER LINE	1:100
②	SURFACE STORM WATER LINE	1:100
③	SURFACE STORM WATER LINE	1:100
④	SURFACE STORM WATER LINE	1:100
⑤	EXTERNAL STORM WATER LINE	1:100
⑥	EXTERNAL STORM WATER LINE	1:100
⑦	EXTERNAL STORM WATER LINE	1:100
⑧	200 Ø SEWERAGE LINE	1:150
⑨	230 Ø SEWERAGE LINE	1:200

