
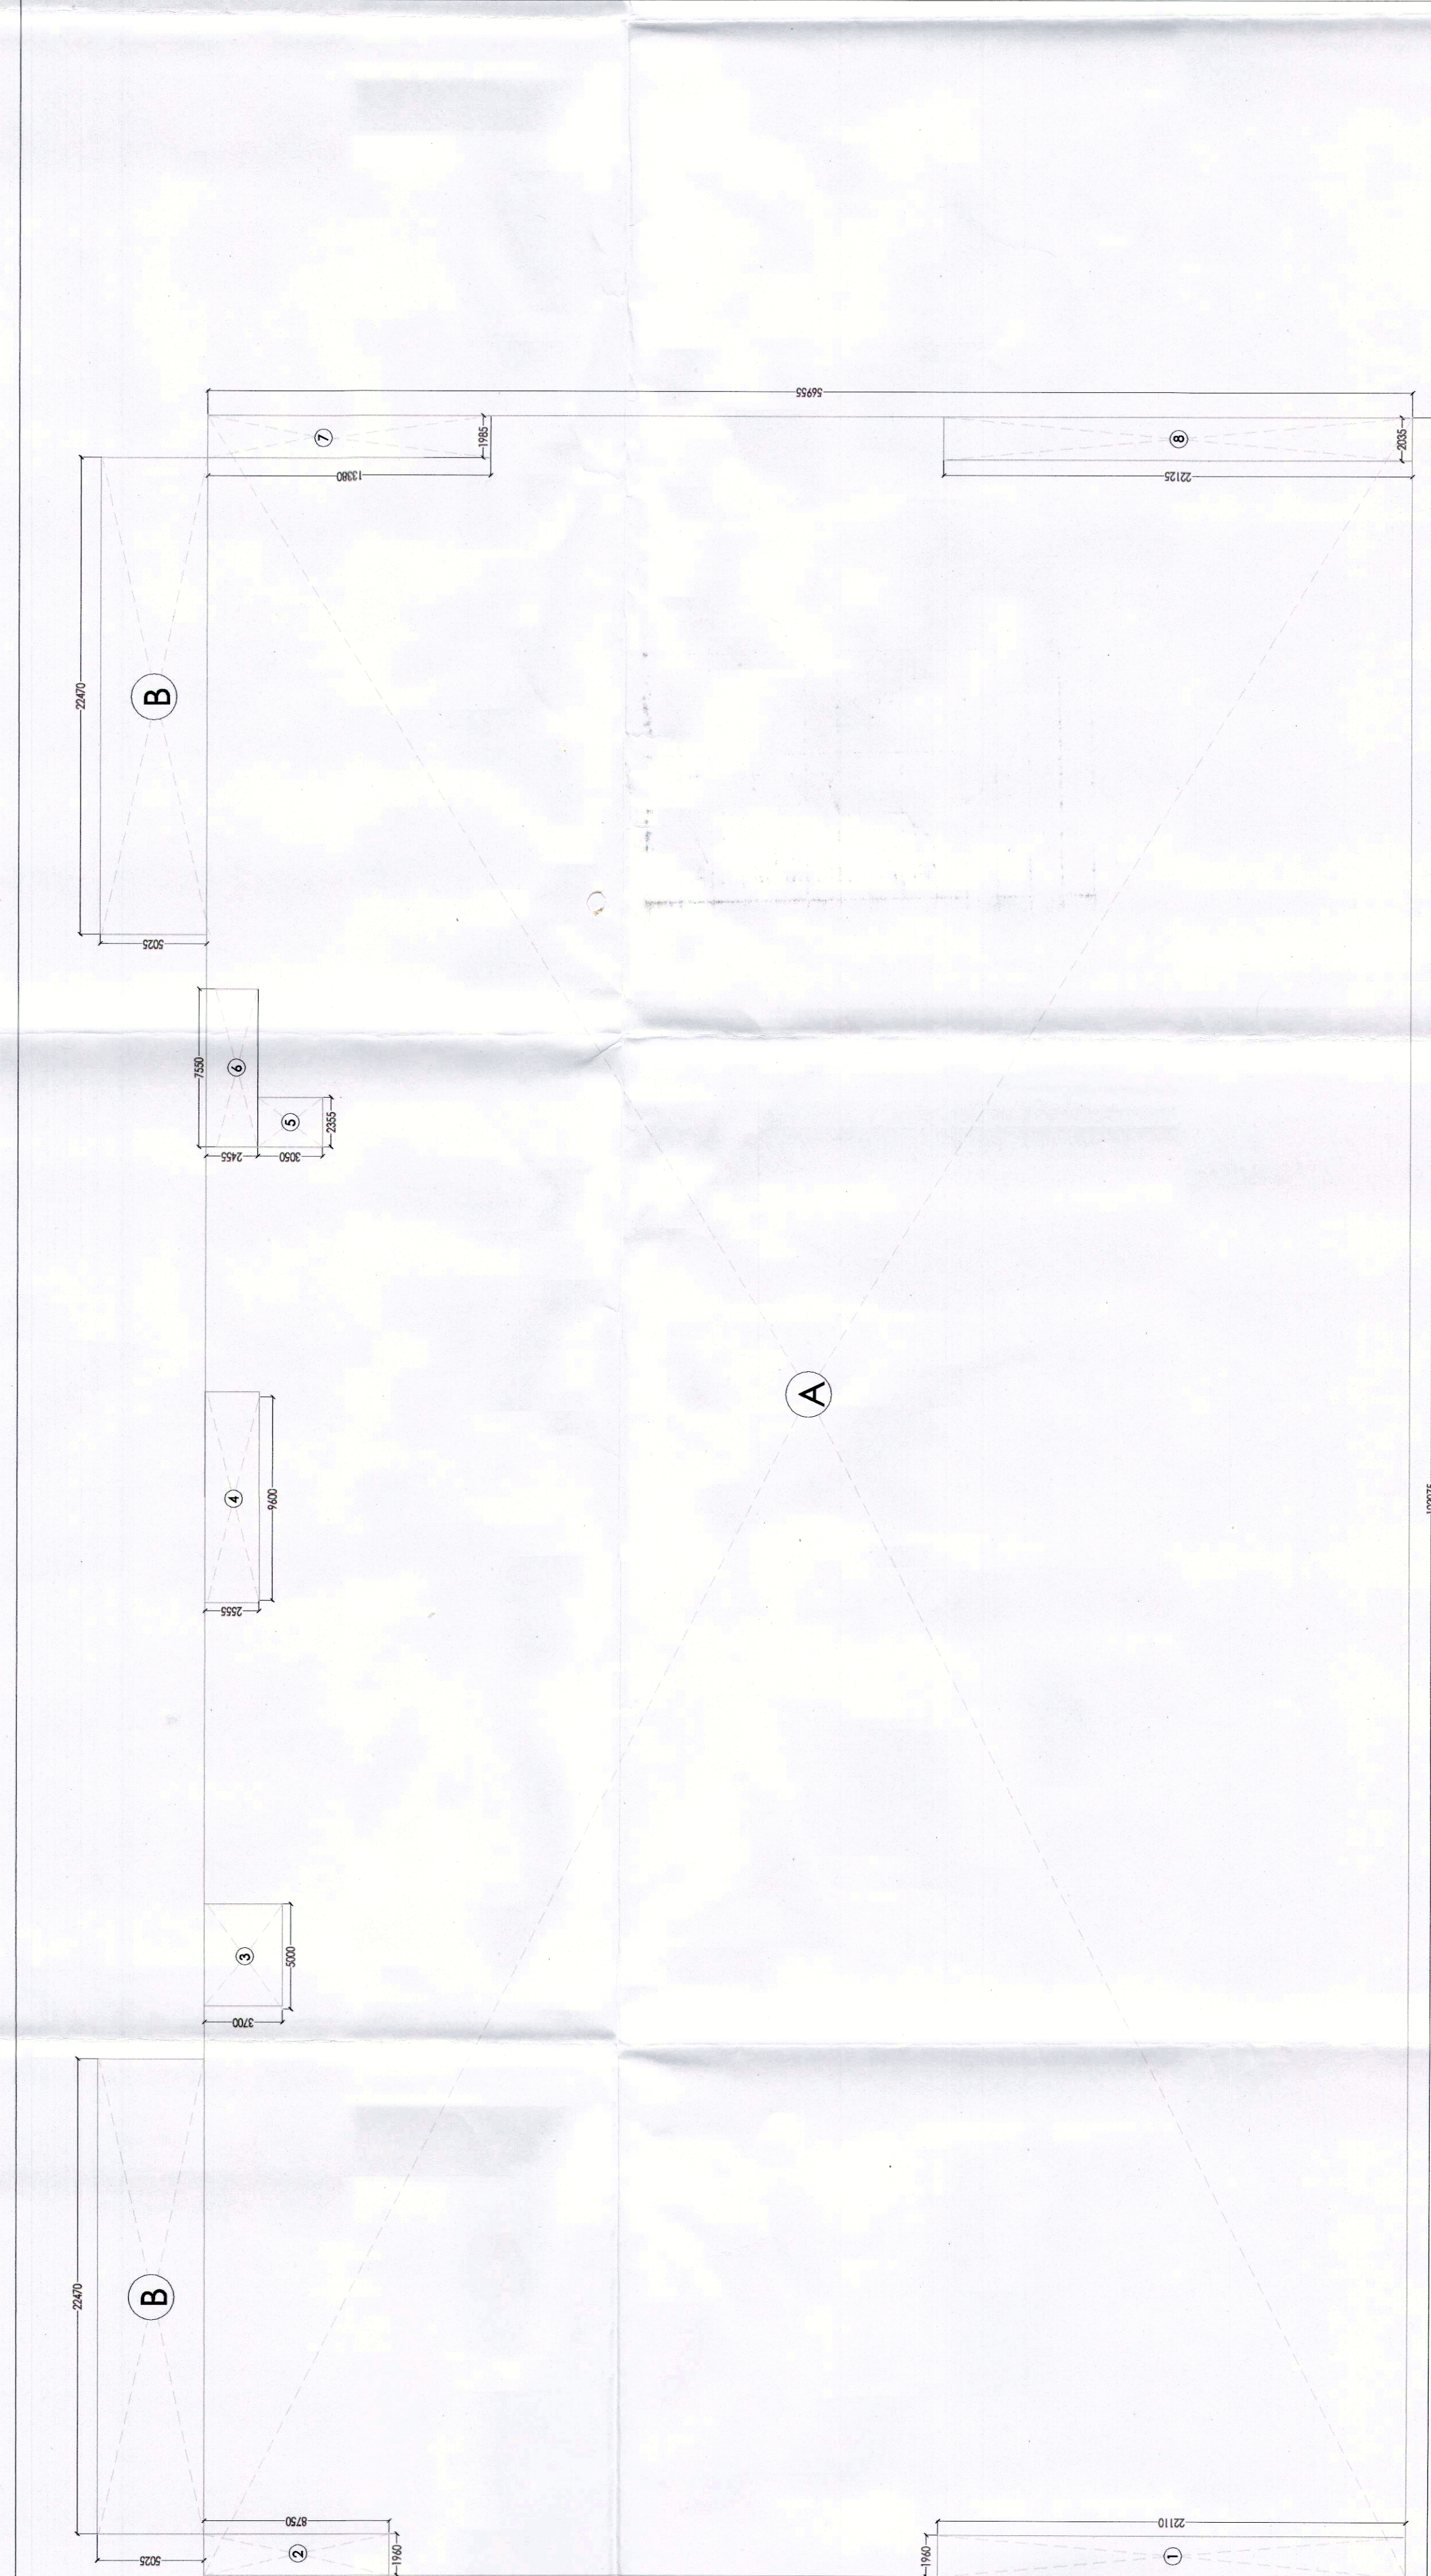


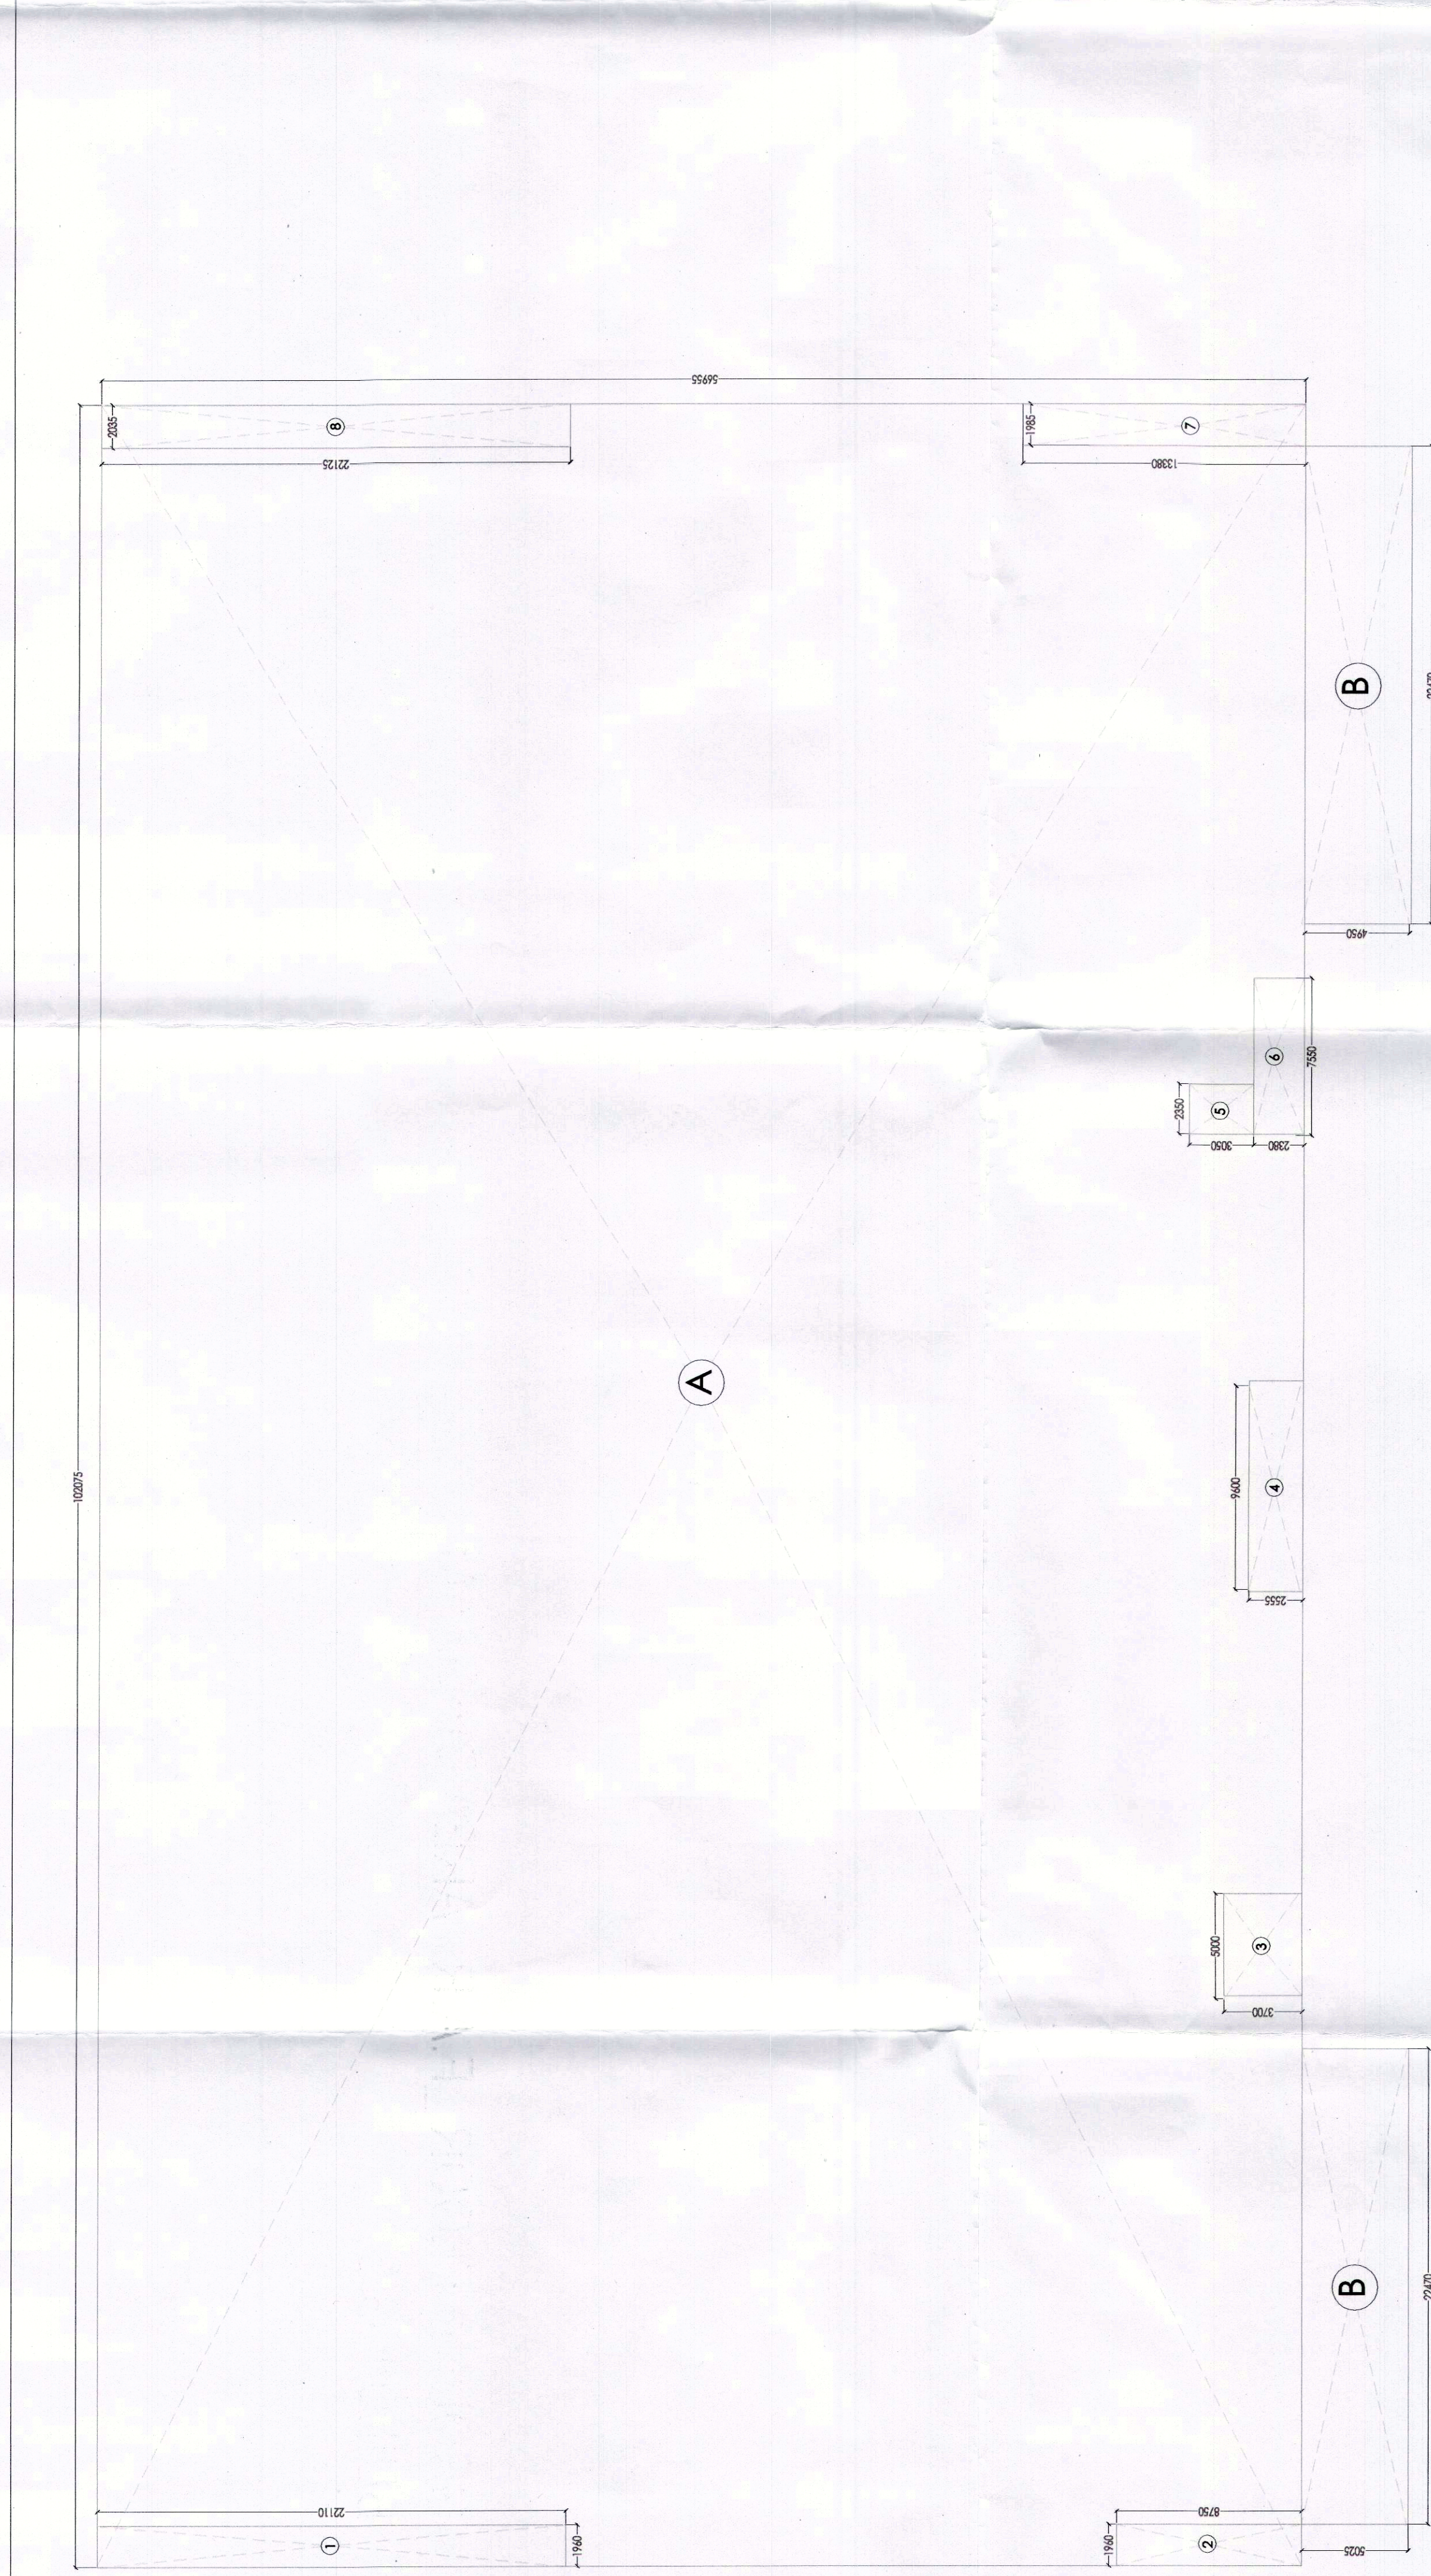

DOOR WINDOW SCHEDULE					FIRE RATING	
SNO	LEGEND	WIDTH(M)	HEIGHT(M)	CELLIT LITEL	REMARKS	LOCATION
1	D1	800	2100	0 2115	WOODEN DOOR	TARGET CUCINA
2	D2	1400	1000	0 2115	WOODEN DOOR	ANTER DOOR
3	D3	1050	2100	0 2115	WOODEN DOOR	ANTER DOOR
4	D3s	1050	2400	0 2415	WOODEN DOOR	TECHNICAL SERVICE
5	D3s	1050	2400	0 2415	WOODEN DOOR	LIBRARY MAIN CORE
6	D3s	1050	2100	0 2115	WOODEN DOOR	REST ROOM
7	D3s	1050	2100	0 2115	WOODEN DOOR	WASHROOM DOORS
8	D4	1600	2400	0 2415	WOODEN DOOR	PANTRY
9	D4	1600	2400	0 2415	WOODEN DOOR	CENTRE CORE (LIBRY)
10	D4	2000	2400	0 2415	WOODEN DOOR	CENTRE CORE (LIBRY)
11	D7	1350	2400	0 2415	WOODEN DOOR	CENTRE CORE (LIBRY)
12	D7	1350	2400	0 2415	WOODEN DOOR	CENTRE CORE (LIBRY)
13	D7	1350	2400	0 2415	WOODEN DOOR	CENTRE CORE (LIBRY)
14	D11	1050	2400	0 2415	WOODEN DOOR	CENTRE CORE (LIBRY)
15	D11	1050	2400	0 2415	WOODEN DOOR	CENTRE CORE (LIBRY)
16	D12	900	2100	0 2115	WOODEN DOOR	CENTRE CORE (LIBRY)
17	D2	750	2000	100 2315	GLASS DOOR	DOOR GLASS
18	F4D	750	2000	100 2315	GLASS DOOR	DOOR GLASS
19	F4D	750	2000	100 2315	GLASS DOOR	DOOR GLASS
20	F4D	750	2000	100 2315	GLASS DOOR	DOOR GLASS
21	F2D	1400	2400	0 2415	METAL FIRE DOOR	FLYING SHIRT
22	F2D	1400	2400	0 2415	METAL FIRE DOOR	FLYING SHIRT
23	F2D	1400	2400	0 2415	METAL FIRE DOOR	FLYING SHIRT
24	F2D	1400	2400	0 2415	METAL FIRE DOOR	FLYING SHIRT
25	F2D	1400	2400	0 2415	METAL FIRE DOOR	FLYING SHIRT
26	F2D	1400	2400	0 2415	METAL FIRE DOOR	FLYING SHIRT
27	F2D	1400	2400	0 2415	METAL FIRE DOOR	FLYING SHIRT
28	F2D	1400	2400	0 2415	METAL FIRE DOOR	FLYING SHIRT
29	F2D	1400	2400	0 2415	METAL FIRE DOOR	FLYING SHIRT
30	F2D	1400	2400	0 2415	METAL FIRE DOOR	FLYING SHIRT
31	F2D	1400	2400	0 2415	METAL FIRE DOOR	FLYING SHIRT
32	F2D	1400	2400	0 2415	METAL FIRE DOOR	FLYING SHIRT
33	F2D	1400	2400	0 2415	METAL FIRE DOOR	FLYING SHIRT
34	F2D	1400	2400	0 2415	METAL FIRE DOOR	FLYING SHIRT
35	F2D	1400	2400	0 2415	METAL FIRE DOOR	FLYING SHIRT

FAR(GROUND FLOOR BUILDING 2&3)						
ADDITION AREA						
T.NO.	TYPE	Nos.	Length	Breadth	Area(d)	Total Area
		a	b	c	b*c	a*d
A	RECTANGLE	1	102.075	56.95	5813.682	5813.681025
B	RECTANGLE	2	22.47	5.025	112.9118	225.8235
TOTAL ADDITION AREA IN SQM						6039.505125

T.NO.	TYPE	Nos.	Length			Breath	Area(d)		Total Area a*d	
			a	b	c		b*c	a*b		
1	RECTANGLE	1	1.96	22.11	43.3356	43.3356	17.15	17.15		
2	RECTANGLE	1	1.96	22.11	43.3356	43.3356	17.15	17.15		
3	RECTANGLE	1	5	3	37	18.5	18.5	18.5		
4	RECTANGLE	1	5	3.7	24.48	24.48	24.48	24.48		
5	RECTANGLE	1	2.35	3.08	7.1675	7.1675	7.1675	7.1675		
6	RECTANGLE	1	7.55	2.38	17.969	17.969	17.969	17.969		
7	RECTANGLE	1	13.38	1.985	26.5953	26.5953	26.5953	26.5953		
8	RECTANGLE	1	22.125	2.03	44.91375	44.91375	44.91375	44.91375		
			TOTAL SUBTRACTION AREA IN SQM							200.07515
			TOTAL AREA IN SQM							5839.429975

PIPE DIAS		
S.NO.	SYMBOL	DESCRIPTION
1	WB. TO FT	40 OD
2	URINAL TO UT	50 OD
3	FD. TO FT	63 OD
4	FT/UT TO VERTICAL STACK	110 OD
5	WC. TO VERTICAL STACK	110 OD

NOTE:
OPENABLE WINDOW PROVIDED AT 10 Meter
CENTER TO CENTER

NOTES: -


- ALL PIPE DIAMETERS ARE IN MM.
- ALL CONNECTIONS FLOW DRAIN TO FLOOR TRAP WILL BE 63 OD UPVC WASTE PIPE.
- ALL WASTE FROM WASH BASIN TO F.T WILL BE 40 OD UPVC WASTE PIPE.
- ALL WASTE FROM URINALS TO U.T WILL BE 50 OD UPVC SOIL PIPE.
- ALL PIPES FROM FT TO STACK WILL BE 110 OD UPVC PIPES OR/OTHERWISE SPECIFIED.
- ALL PIPES FROM WC/UT TO STACK WILL BE 110 OD UPVC PIPES OR/OTHERWISE SPECIFIED.

This is a "PROVISIONAL BUILDING PLAN" approved only for the purpose of inviting objections from the general public

W. J. Hines STP(HQ) Member Secretary
STP(S)
STP(MC) Chairman
SOLC
NSAC

Ram Avtar Bhatt
AD(HQ)

18/11/20
JF

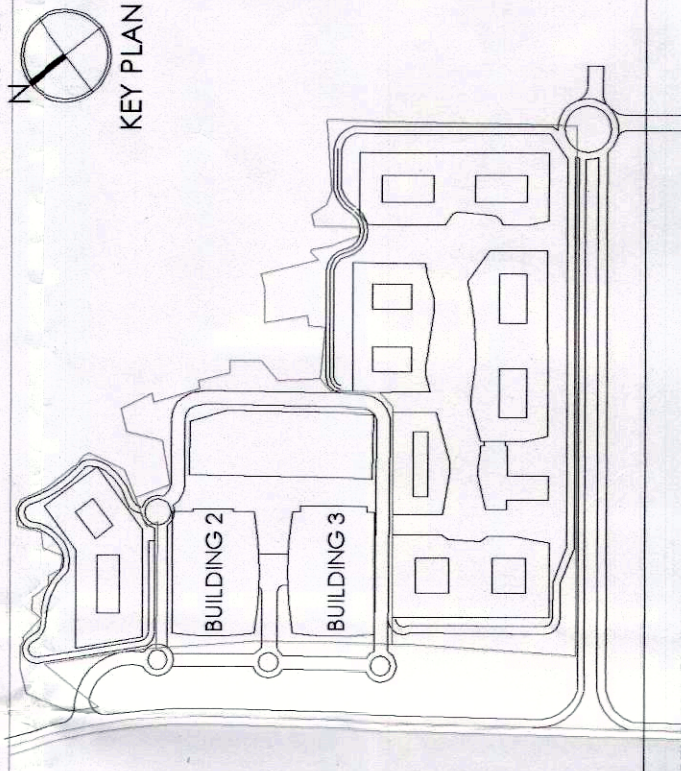

S.N.O.	SYMBOL	DESCRIPTION
01	110	110 Ø SOIL PIPE
02	110	110 Ø WASTE PIPE
03	75	75 Ø ANTISEPHOME PIPE
04	50	50 DOMESTIC WATER SUPPLY HYDROPHUMALATI
05	439	439 DOMESTIC WATER SUPPLY HYDROPHUMALATI
06	50	50 FLUSHING WATER SUPPLY HYDROPHUMALATI
07	63	63 Ø THERMAL RAIN WATER PIPE
08	75	75 Ø 110 Ø THERMAL RAIN WATER PIPE
09	FQ	FLOOR DRAIN
10	FQ	FLOOR TRAP
11	UT	URNAL TAP
12	CPP	CLEAN OUT PLUG
13		SOIL PIPE
14		WASTE PIPE
15		VENT PIPE
16		RAIN WATER PIPE
17		DOMESTIC WATER PIPE
18		FLUSHING WATER PIPE

Architects:

Arcop Associates Pvt. Ltd.

Plot-36b, Sec-32, Gurgaon-122001

Ph.: +91-124-4595500 FAX: +91-124-4595500
Montreal Toronto New Delhi Boston

Project: Montreal, Toronto, New-Delhi, BostonPROPOSED /REVISED BUILDING PLAN OF
COMMERCIAL

COLONY AREA MEASURING 32.36 ACRES PART
OF RESIDENTIAL PLOTTED COLONY NAMED V

DLF CITY, PHASE I, II & III AND INDEPENDENT COMMERCIAL COLONY 1.00 ACRES / LICENCE

COMMERCIAL COLON 4.00 ACRES (EIGEN
NO.59 OF 2018
DATED 07.08.2018) BY MAKING TOTAL AREA

MEASURING 36.36 ACRES UNDER TOD ZONE
DATED 07.09.2016) BY MARKING TOTAL AREA
IN SECTOR 24.8 25A CUBICGRAM MANEERAD

IN SECTOR -24 & 23A GURUGRAMI MANESAR
URBAN COMPLEX BEING DEVELOPED BY DLF
LIMITED AND OTHERS

LIMITED AND OTHERS.

DRAWING TITLE: -

GROUND FLOOR PLAN _ FAR
BUILDING 2&3

DTN/B2&3/04

SCALE: -
1:200
DATE: -
25-05-2021

DRAWING TITLE: -
GROUND FLOOR PLAN _FAR
BUILDING 2&3

JOB NO: —

DRG NO. DTN/BC83/04

NORTH: — N

SCALE: -	DATE: -
DIN/BZ&J/04	

FILED BY: -	DATE BY: -	25-05-2021	APPROVED BY: -
-------------	------------	------------	----------------

FILED	SEAL OF:	CHARGED BY:	BY:
	MALTI	VIKRAM	BY:VIKRA
ARCHITECT'S SEAL		OWNER'S SEAL	

 Vikram Singh Sahni, Architect
Council of Architecture

 Registrar
 Registration No.: CA/54/17100