



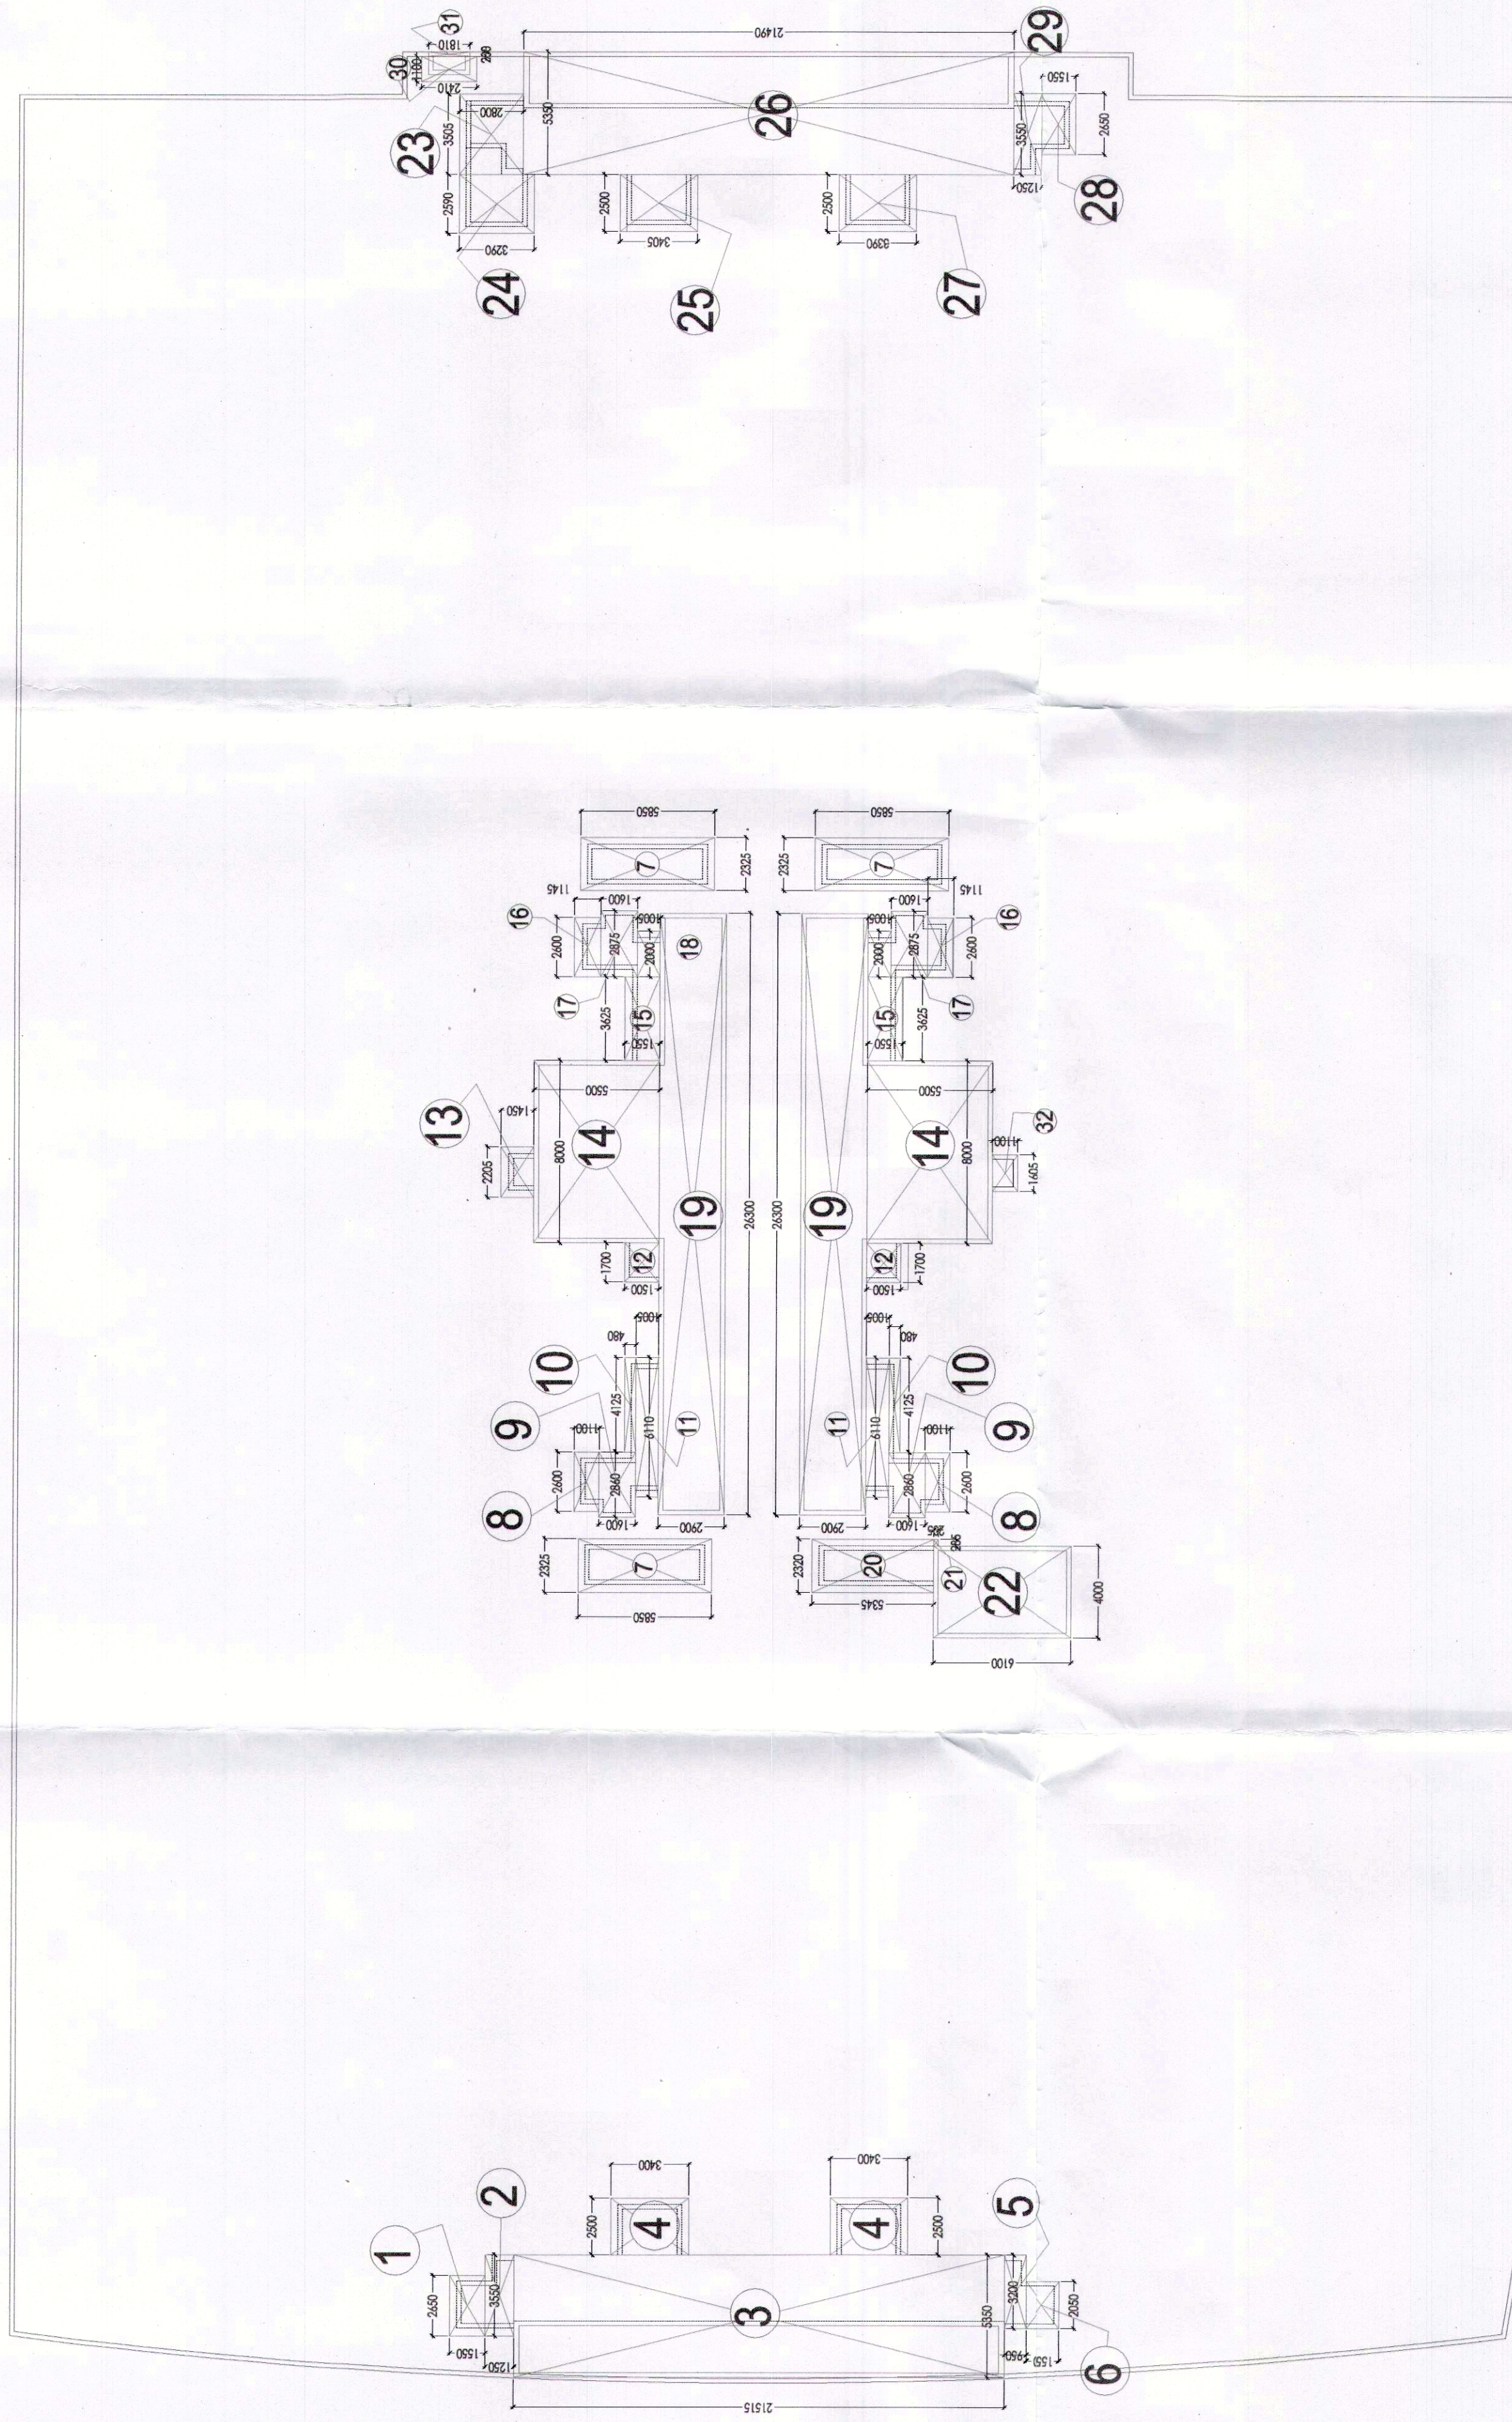

TERRACE FLOOR PLAN_BUILT UP AREA DIAGRAM
BUILDING 2

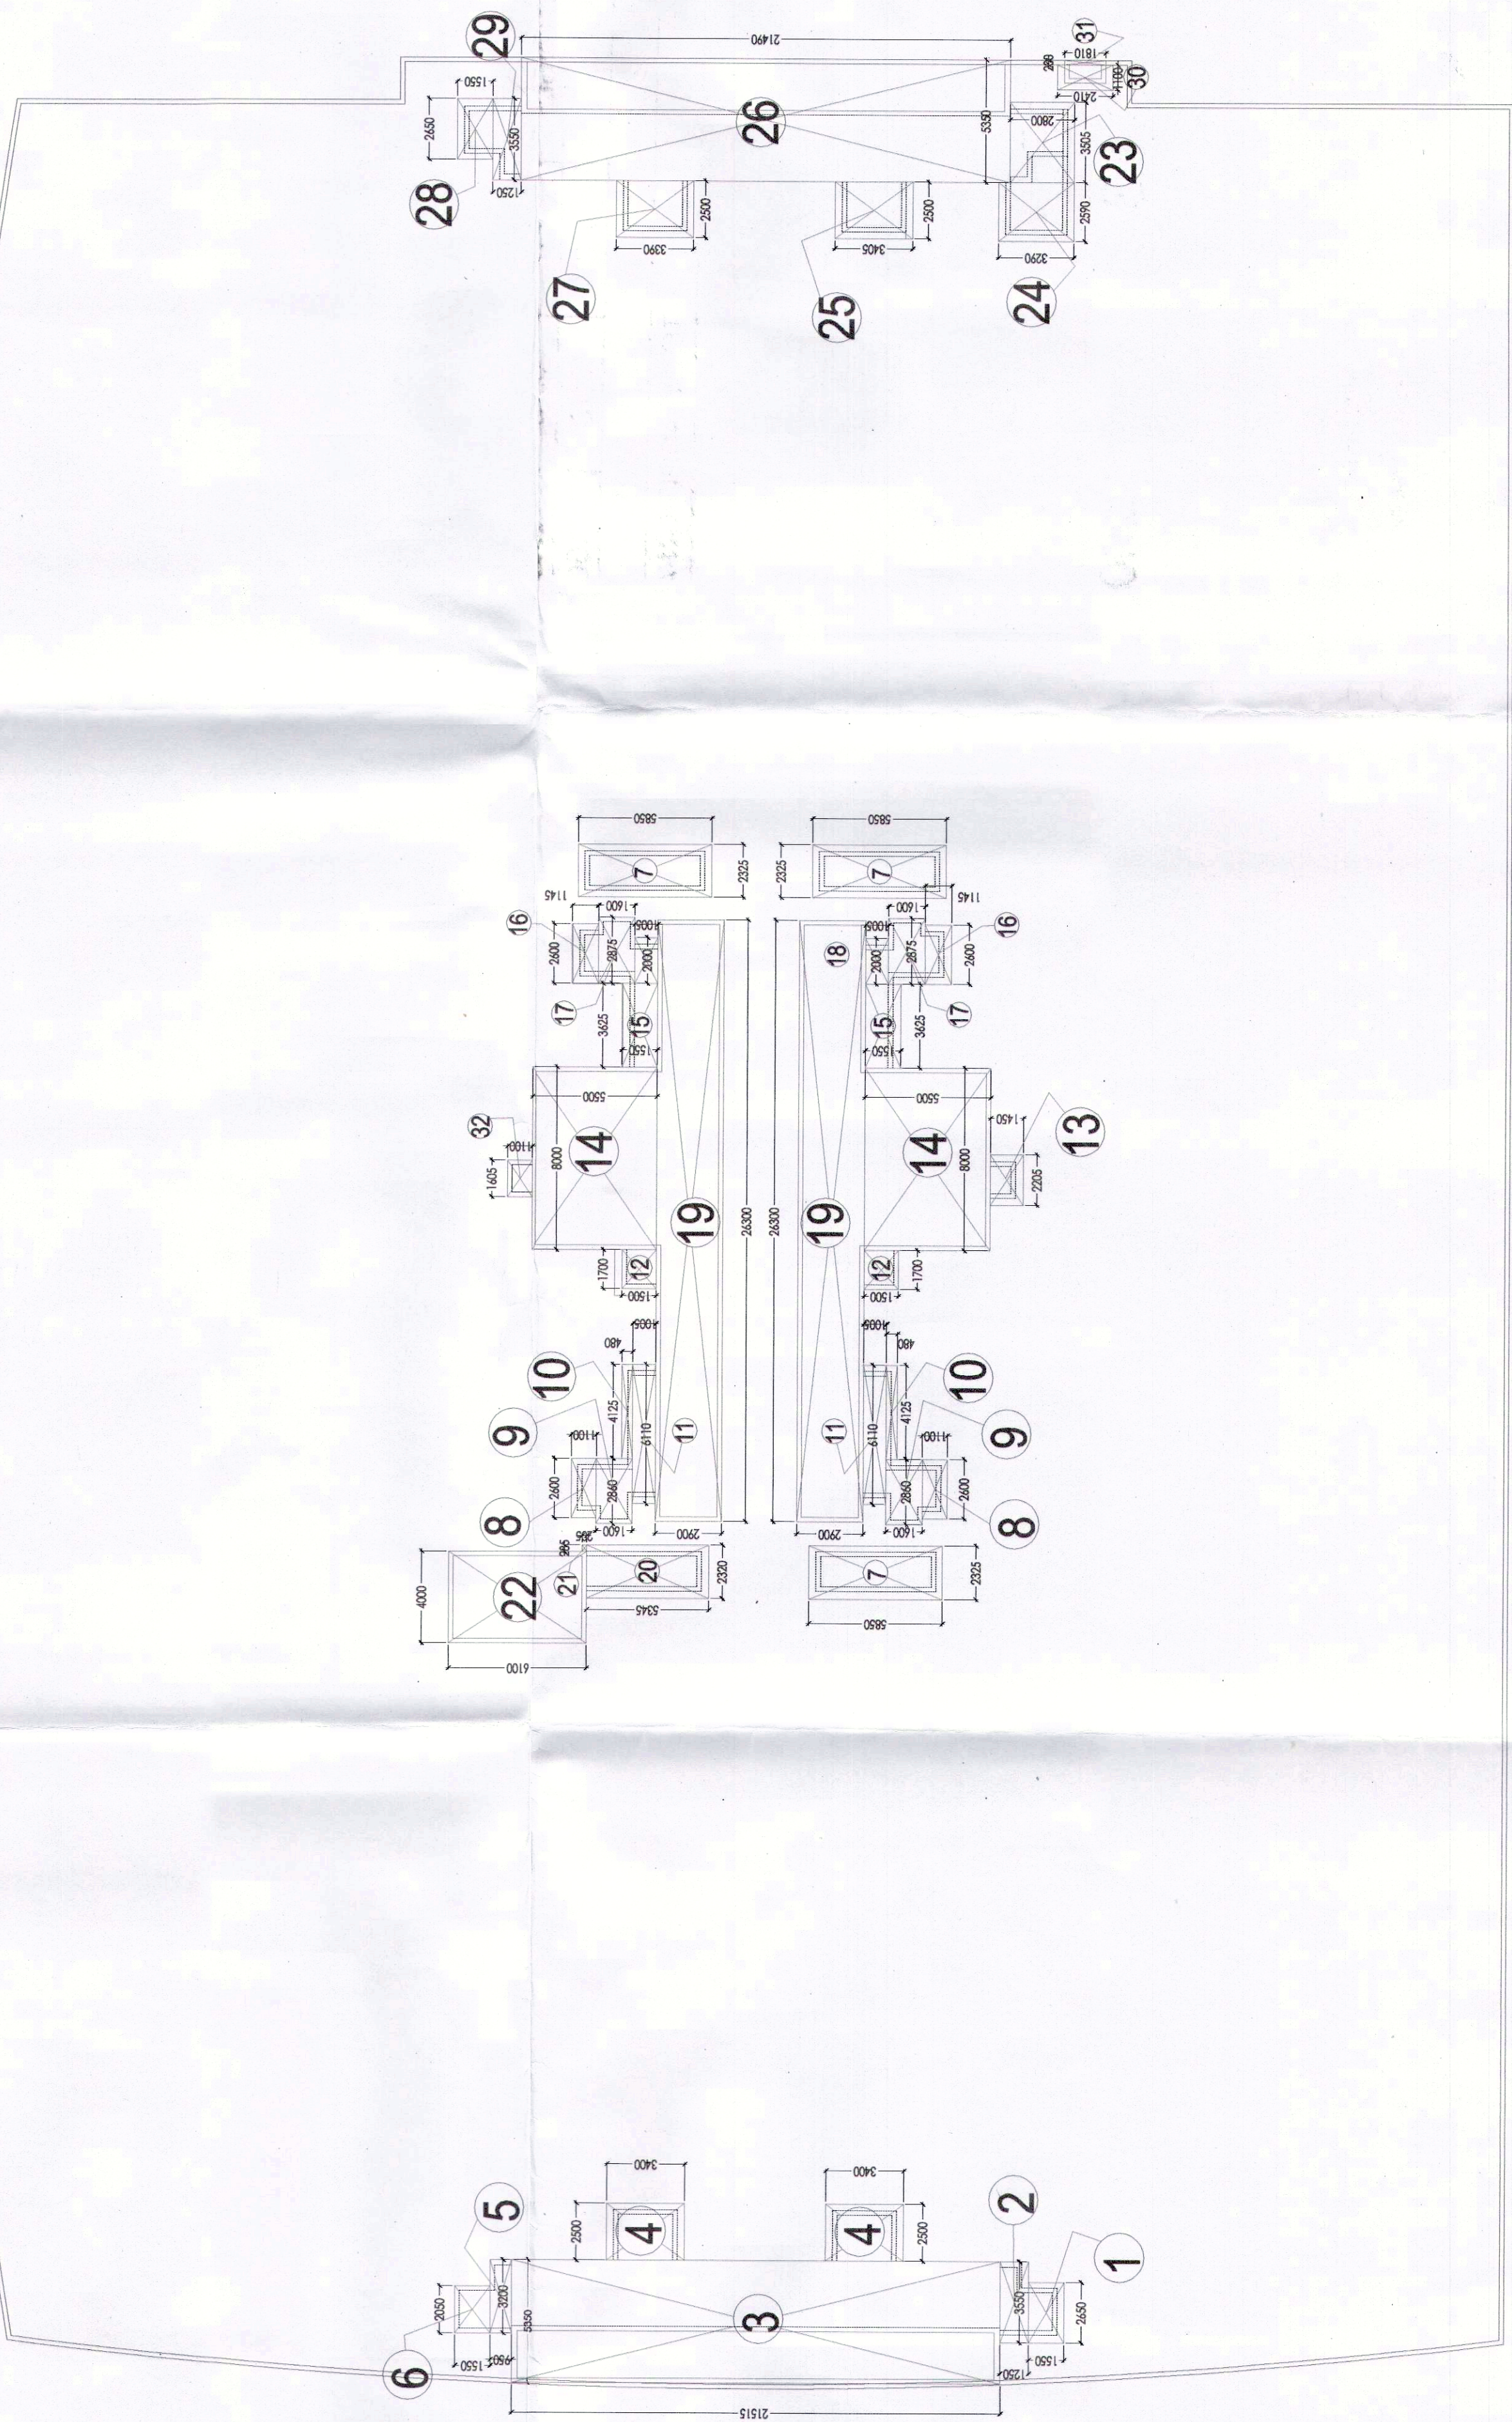

TERRACE FLOOR PLAN_BUILT UP AREA DIAGRAM
BUILDING 3

BUILDING 2 TERRACE						
ADDITION AREA						
T. NO.	TYPE	NOS.	LENGTH	BREADTH	AREA	TOTAL AREA
1	RECTANGLE	1.0	2.65	1.55	4.11	4.11
2	RECTANGLE	1.0	3.55	1.25	4.44	4.44
3	RECTANGLE	1.0	5.35	21.51	115.08	115.08
4	RECTANGLE	2.0	3.40	2.50	8.50	17.00
5	RECTANGLE	1.0	3.20	0.95	3.04	3.04
6	RECTANGLE	1.0	2.05	1055.00	2162.75	2162.75
7	RECTANGLE	3.0	2.32	5.85	13.57	40.72
8	RECTANGLE	2.0	2.60	1.10	2.86	5.72
9	RECTANGLE	2.0	2.86	1.60	4.58	9.15
10	RECTANGLE	2.0	4.12	0.48	1.98	3.96
11	RECTANGLE	2.0	6.11	1.00	6.11	12.22
12	RECTANGLE	2.0	1.70	1.50	2.55	5.10
13	RECTANGLE	1.0	2.20	1.45	3.19	3.19
14	RECTANGLE	2.0	8.00	5.50	44.00	88.00
15	RECTANGLE	2.0	1.55	3.62	5.61	11.22
16	RECTANGLE	2.0	2.60	1.14	2.96	5.93
17	RECTANGLE	2.0	2.87	1.60	4.59	9.18
18	RECTANGLE	2.0	2.00	1.00	2.00	4.00
19	RECTANGLE	2.0	26.30	2.90	76.27	152.54
20	RECTANGLE	1.0	2.32	5.34	12.39	12.39
21	RECTANGLE	1.0	0.20	0.28	0.06	0.06
22	RECTANGLE	1.0	6.10	4.00	24.40	24.40
23	RECTANGLE	1.0	2.80	2.50	7.00	7.00
24	RECTANGLE	1.0	2.59	3.29	8.52	8.52
25	RECTANGLE	1.0	2.50	3.40	8.50	8.50
26	RECTANGLE	1.0	5.35	21.49	114.97	114.97
27	RECTANGLE	1.0	2.50	3.39	8.48	8.48
28	RECTANGLE	1.0	2.65	1.55	4.11	4.11
29	RECTANGLE	1.0	3.55	1.25	4.44	4.44
30	RECTANGLE	1.0	1.10	2.41	2.65	2.65
31	RECTANGLE	1.0	0.20	1.81	0.36	0.36
32	RECTANGLE	1.0	1.10	1.60	1.76	1.76

TOTAL ADDITION AREA IN SQ. M

2854.97

TERRACE
BUILDING - 3
1:200

PIPE DIKS		DESCRIPTION
S.NO.	SYMBOL	
1	WB TO FT	40.00
2	URNAL TO UT	50.00
3	FD TO FT	63.00
4	FT/UT TO VERTICAL STACK	110.00
5	WC TO VERTICAL STACK	110.00


- NOTES:-
- ALL PIPE DIAMETERS ARE IN MM.
 - ALL CONNECTIONS FLOOR DRAIN TO FLOOR TRAP WILL BE 63 OD UPVC WASTE PIPE.
 - ALL WASTE FROM WASH BASIN TO F.T WILL BE 40 OD UPVC WASTE PIPE.
 - ALL WASTE FROM URINALS TO U.T WILL BE 50 OD UPVC SOIL PIPE.
 - ALL PIPES FROM F.T TO STACK WILL BE 110 OD UPVC PIPES OR OTHERWISE SPECIFIED.
 - ALL PIPES FROM WC OUT TO STACK WILL BE 110 OD UPVC PIPES OR OTHERWISE SPECIFIED.

This is a "PROFESSIONAL BUILDING PLAN" approved only for the use of the building owner and not for any other purpose. Any use for other purpose is at the owner's risk and the architect is not responsible for any damage or loss arising from the same.

Architect's Seal & Signature

1/11/2020
3D

1. BUILDING HAS AUTOMATIC SPRINKLER SYSTEM WHEREVER REQUIRED BY NBC.
2. BUILDING WILL BE DESIGNED (STRUCTURES) AS PER RELEVANT IS CODES FOR EARTH QUAKE RESISTANCE.
3. BUILDING IS ARTIFICIALLY LIGHTED MECHANICALLY VENTILATED & CENTRALLY AIR-CONDITIONED WITH 100% POWER BACKUP.

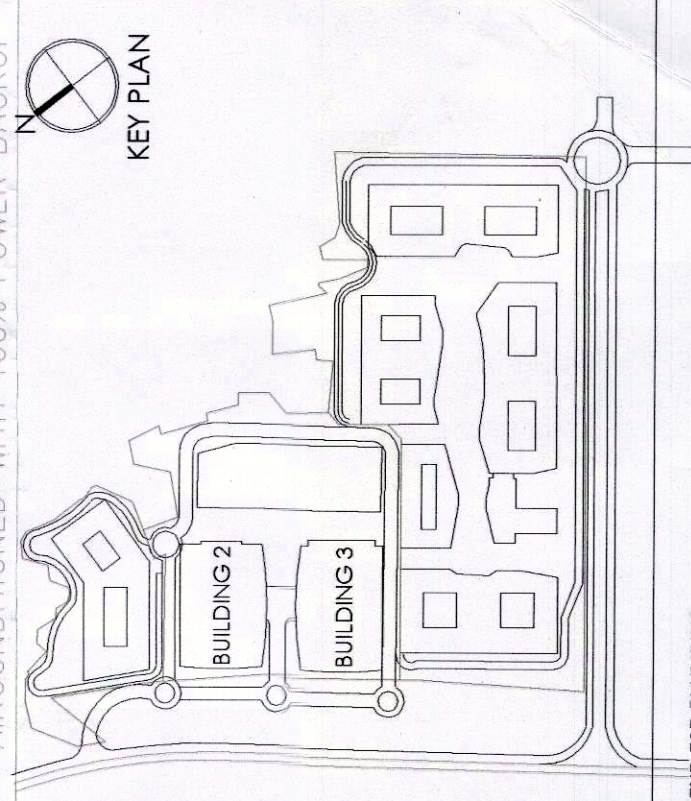

S.NO.	SYMBOL	DESCRIPTION
01.	1	110 OD SOIL PIPE
02.	2	110 OD WASTE PIPE
03.	3	75 OD ANTISIPHONAGE PIPE
04.	4	DOMESTIC WATER SUPPLY HYDROPAUMATIC
05.	5	DOMESTIC WATER SUPPLY HYDROPAUMATIC
06.	6	FLUSHING WATER SUPPLY HYDROPAUMATIC
07.	7	160 OD TERRACE RAIN WATER PIPE
08.	8	110 OD MUDTY/BALCONY RAIN WATER PIPE
09.	9	FLOOR DRAIN
10.	10	UT
11.	11	UT
12.	12	COP II CLEAN OUT PLUG
13.	13	SOIL PIPE
14.	14	WASTE PIPE
15.	15	VENT PIPE
16.	16	RAIN WATER PIPE
17.	17	DOMESTIC WATER PIPE
18.	18	FLUSHING WATER PIPE

Architects:

Arcop Associates Pvt. Ltd.
Plot- 36b, Sec-32, Gurgaon-122001
Ph: +91-124-4595500 FAX: +91-124-4595500
Montreal, Toronto, New-Delhi, Boston

PROPOSED REVISED BUILDING PLAN OF COMMERCIAL COLONY AREA MEASURING 32.38 ACRES PART OF RESIDENTIAL PLOTTED COLONY NAMEDLY DLF CITY PHASE III & III AND INDEPENDENT COMMERCIAL COLONY 4.00 ACRES (LICENCE NO.59 OF 2018 DATED 07.09.2018) BY MAKING TOTAL AREA MEASURING 36.38 ACRES UNDER TOD ZONE IN SECTOR-24 & 25A GURIGRAM MANESAR URBAN COMPLEX BEING DEVELOPED BY DLF LIMITED AND OTHERS.

DRAWING TITLE:-

TERRACE FLOOR_BUILDING2&3

DRG NO. DTN/B2&3/08
DATE: 25-05-2020
SCALE:-

FILE:-
PROJECT:-
ARCHITECT'S SEAL & SIGNATURE

Architect's Seal & Signature