


This is a "PROVISIONAL BUILDING PLAN" approved only for the purpose of inviting objections from the general public.

[Signatures and stamps]

[Handwritten notes]

1. BUILDING HAS AUTOMATIC SPRINKLER SYSTEM AS REQUIRED BY NSC.
2. BUILDING WILL BE DESIGNED (STRUCTURES) AS PER RELEVANT IS CODES FOR EARTH QUAKE RESISTANCE, FULLY LIGHTED, MECHANICALLY VENTILATED, CENTRALLY AIR-CONDITIONED WITH 100% POWER BACKUP.

KEY PLAN

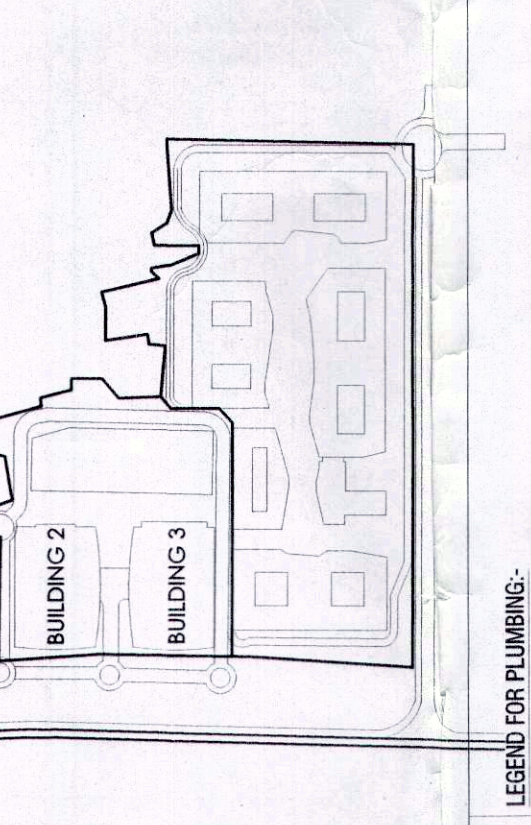

DATA	DESCRIPTION
01	110.00 SOIL PIPE
02	110.00 WASTE PIPE
03	75.00 ANTI-SIPHONAGE PIPE
04	DOMESTIC WATER SUPPLY HYDRO-PNEUMATIC
05	FLUSHING WATER SUPPLY HYDRO-PNEUMATIC
06	100.00 TERRACE RAIN WATER PIPE
07	100.00 MURTI/BALCONY RAIN WATER PIPE
08	FLOOR DRAIN
09	FLOOR TRAP
10	URINAL TRAP
11	CLEAN OUT PLUG
12	SOIL PIPE
13	WASTE PIPE
14	VENT PIPE
15	RAIN WATER PIPE
16	DOMESTIC WATER PIPE
17	FLUSHING WATER PIPE

Architects:


Arcop Associates Pvt. Ltd.
Plot- 36b, Sec-32, Gurgaon-122001
Ph: +91-124-4595500 FAX: +91-124-4595550
Montreal, Toronto, New-Delhi, Boston

PROPOSED/REVISED BUILDING PLAN OF COMMERCIAL COLONY AREA MEASURING 32.38 ACRES PART OF RESIDENTIAL PLOTTED COLONY NAMELY DLF CITY PHASE III & II AND INDEPENDENT COMMERCIAL COLONY 4.00 ACRES (LICENCE NO. 59 OF 2018) DATED 07.09.2018 BY MAKING TOTAL AREA MEASURING 36.38 ACRES UNDER TOD ZONE IN SECTOR-24 & 25A GURUGRAM MANESAR URBAN COMPLEX BEING DEVELOPED BY DLF LIMITED AND OTHERS.

DRAWING TITLE: GROUND FLOOR PLAN - BUILDING 2

JOB NO. -	DTN/B2/04
SCALE: -	1:100
FILE: -	CHECKED BY: VIKRAM BY VIKRAM
ARCHITECT'S SEAL & SIGNATURE	OWNER'S SEAL & SIGNATURE

For DLF Limited
[Signature]

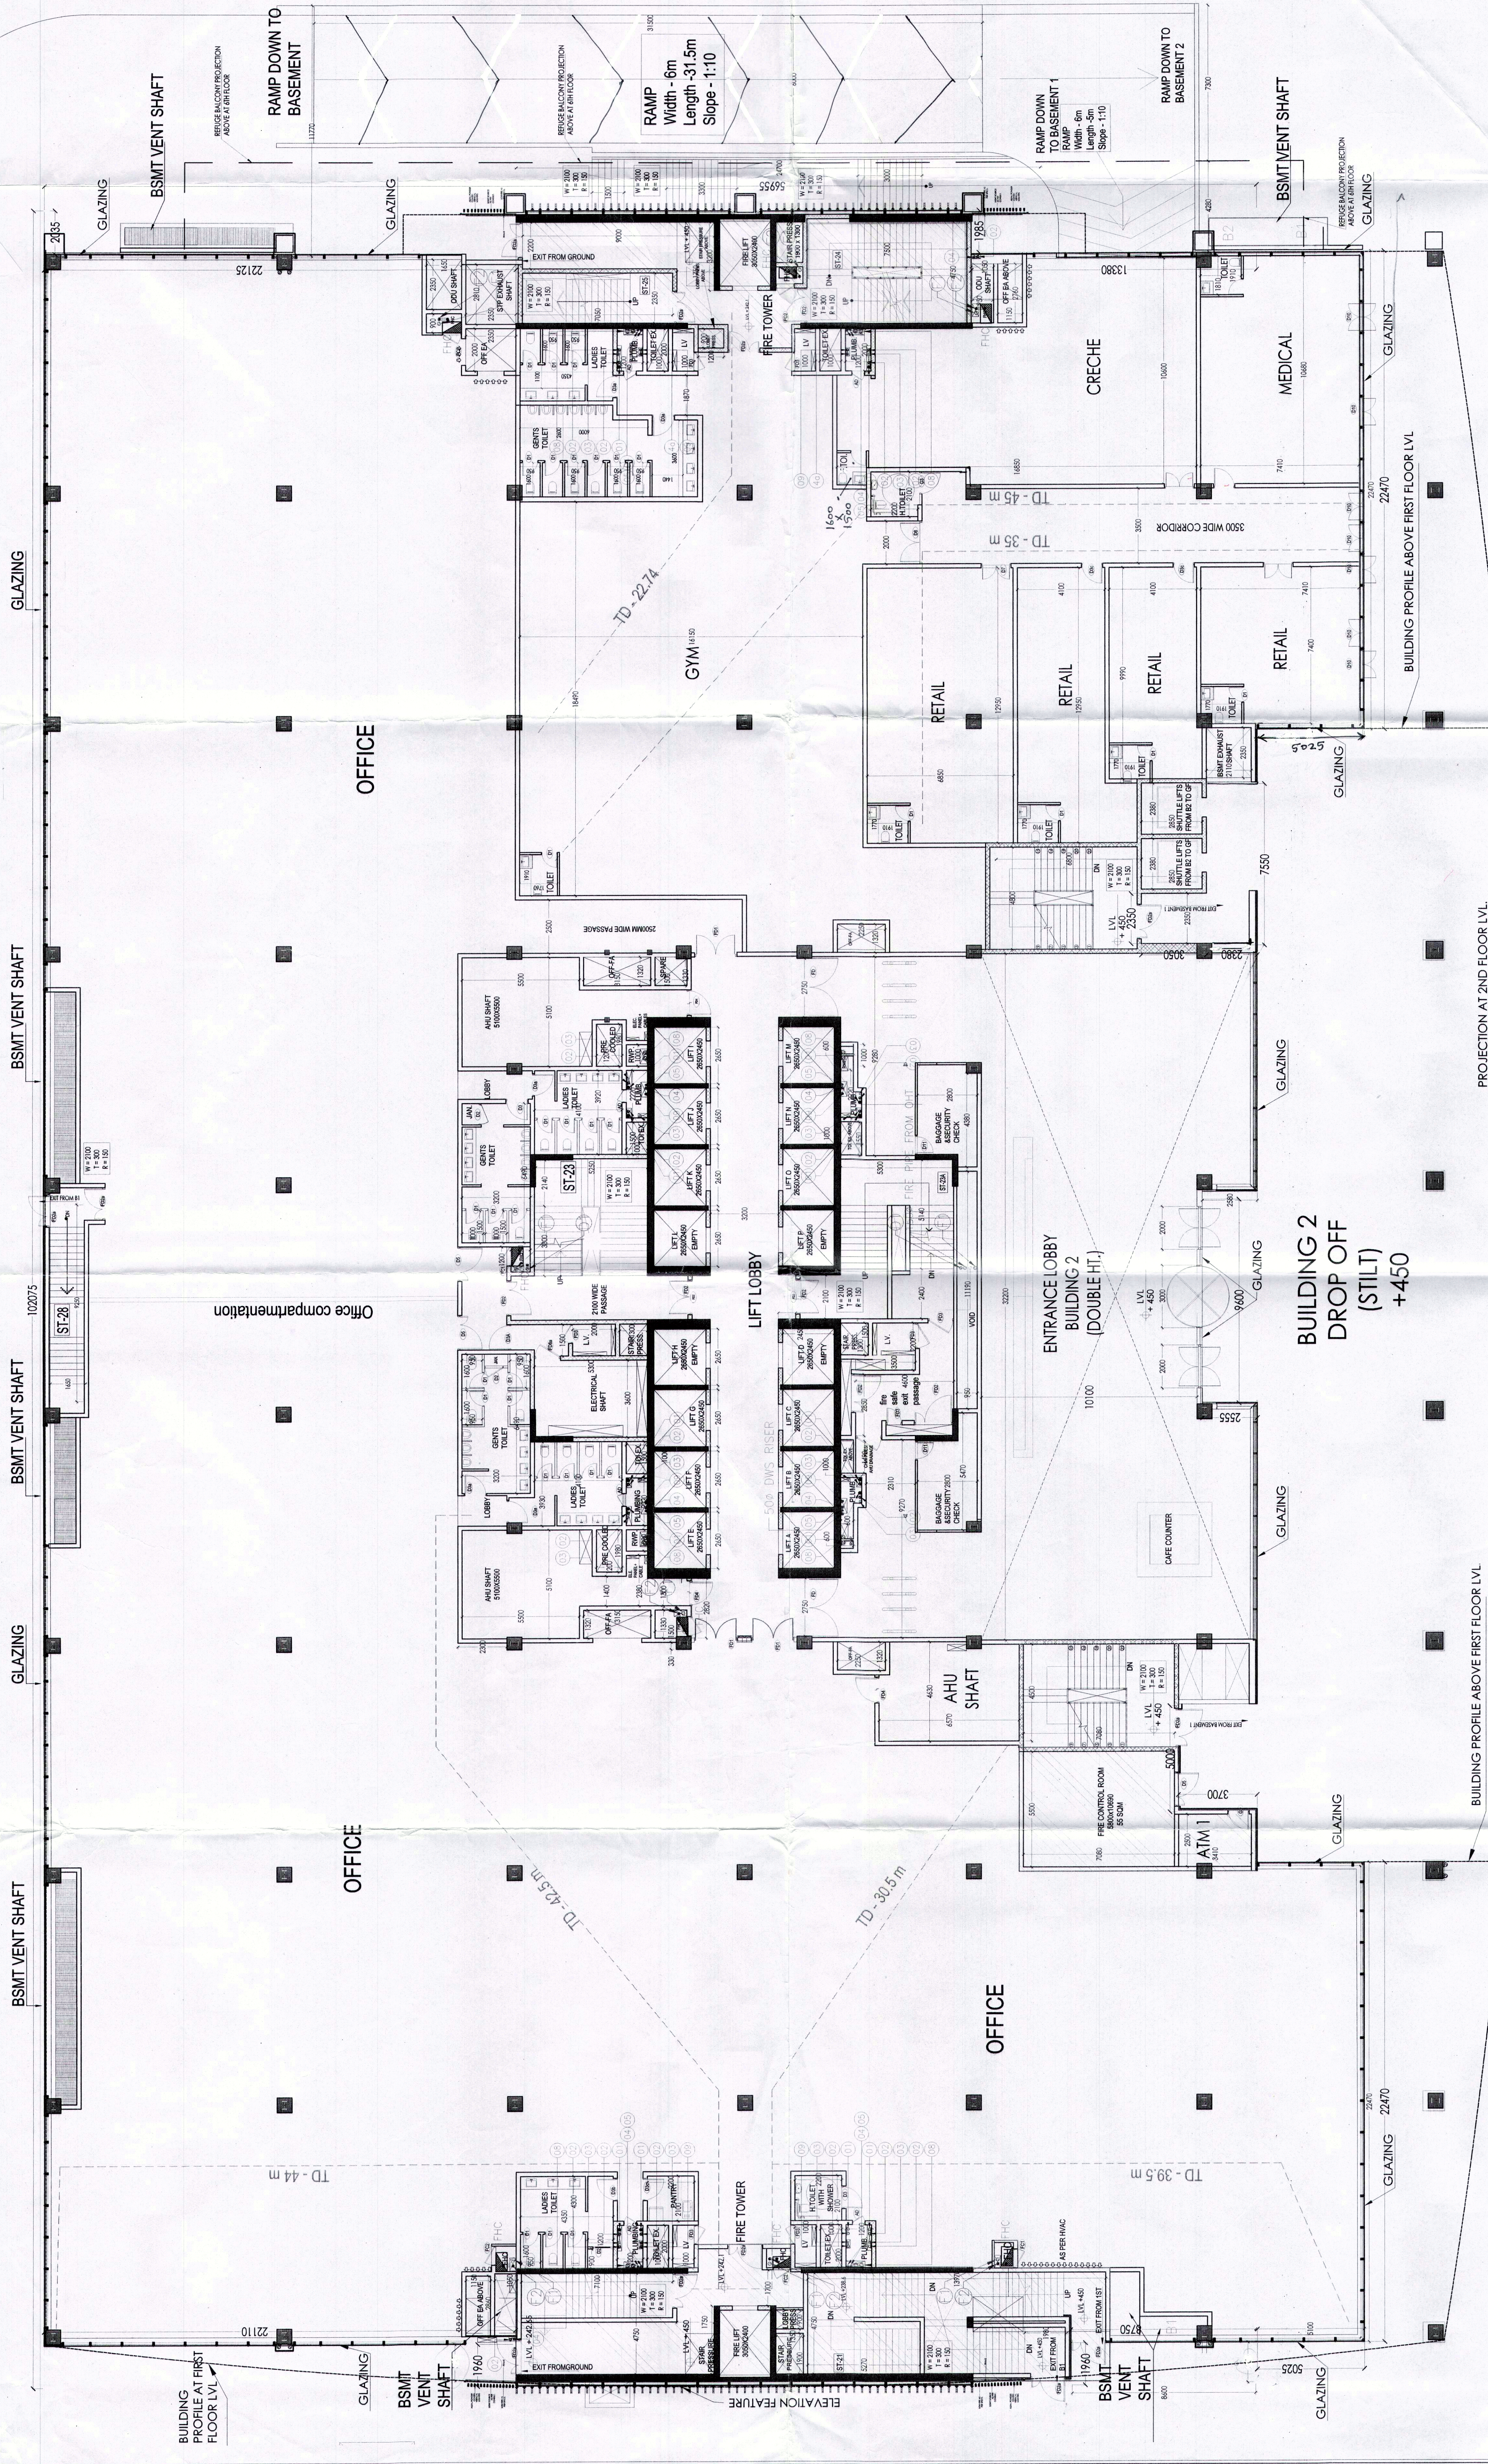

NOTE: OPENABLE WINDOW PROVIDED AT 10 Meter CENTER TO CENTER

PIPE DIA'S	S.NO.	SYMBOL	DESCRIPTION
1	WB TO FT	40.00	ALL PIPE DIAMETERS ARE IN MM
2	URINAL TO UT	50.00	ALL CONNECTIONS FLOOR DRAIN TO FLOOR TRAP WILL BE 63.00 UPVC WASTE PIPE
3	FD TO FT	63.00	ALL WASTE FROM WASH BASIN TO FT WILL BE 40.00 UPVC WASTE PIPE
4	FT/UT TO VERTICAL STACK	110.00	ALL WASTE FROM URINALS TO UT WILL BE 40.00 UPVC SOIL PIPE
5	WC TO VERTICAL STACK	110.00	ALL DRAIN FROM FT TO STACK WILL BE 110.00 UPVC PIPES 100/110 (OTHERWISE SPECIFIED)

GROUND FLOOR PLAN
BUILDING 2

Note: Openable windows are provided @ c/c distance less than 10 meters.

LEVEL(+450)

NO.	DOOR	LOCATION	REMARKS
1	DOOR	DOOR	DOOR
2	DOOR	DOOR	DOOR
3	DOOR	DOOR	DOOR
100	DOOR	DOOR	DOOR