


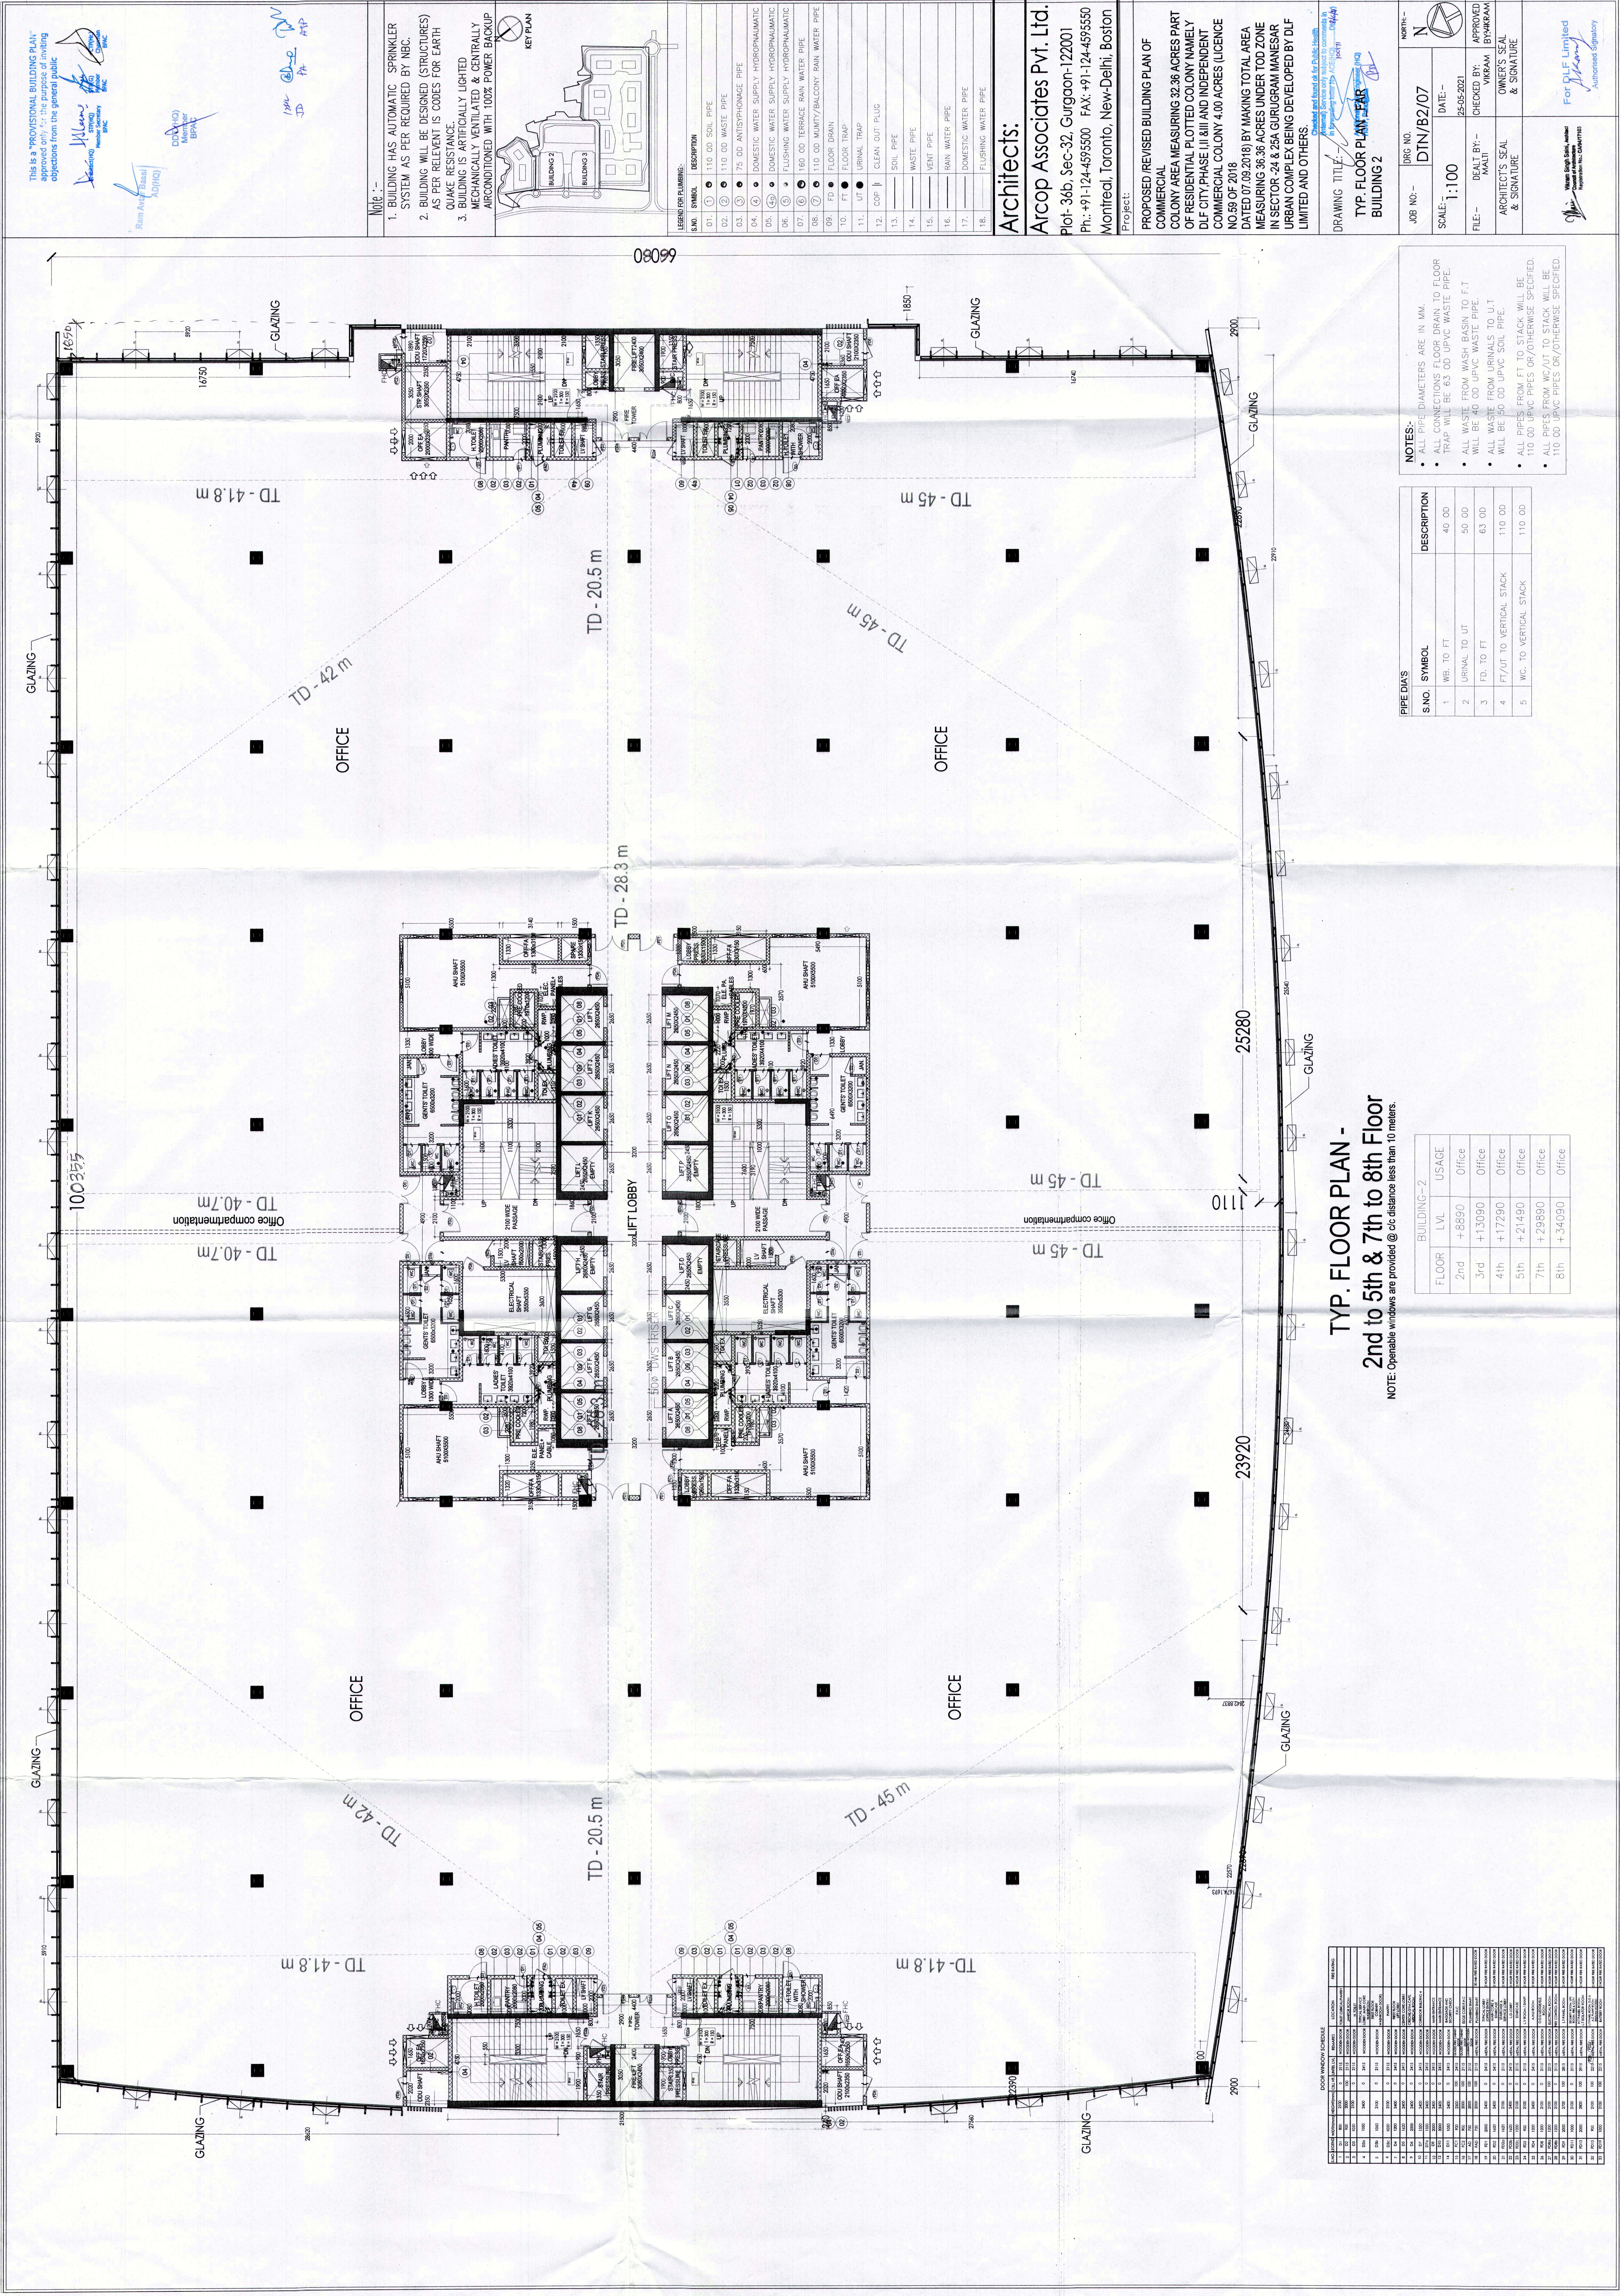

DOOR WINDOW SCHEDULE		NO.	TYPE	LOCATION	REMARKS
1	DOOR	100	100	100	100
2	DOOR	100	100	100	100
3	DOOR	100	100	100	100
100	DOOR	100	100	100	100

BUILDING - 2		
FLOOR	LVL	USAGE
2nd	+8890	Office
3rd	+13090	Office
4th	+17290	Office
5th	+21490	Office
7th	+29590	Office
8th	+34090	Office

PIPE DIAS		DESCRIPTION
S.NO.	SYMBOL	
1	WB TO FT	40 OD
2	URINAL TO UT	50 OD
3	FD TO FT	63 OD
4	FT/UT TO VERTICAL STACK	110 OD
5	WC TO VERTICAL STACK	110 OD

NOTES:-

- ALL PIPE DIAMETERS ARE IN MM
- ALL CONNECTIONS FLOOR DRAIN TO FLOOR TRAP WILL BE 63 OD UPVC WASTE PIPE.
- ALL WASTE FROM WASH BASIN TO F.T WILL BE 40 OD UPVC WASTE PIPE.
- ALL WASTE FROM URINALS TO F.T WILL BE 63 OD UPVC WASTE PIPE.
- ALL PIPES FROM FT TO STACK WILL BE 110 OD UPVC PIPES OR/OTHERWISE SPECIFIED.

TYP. FLOOR PLAN -
2nd to 5th & 7th to 8th Floor
NOTE: Operable windows are provided @ cb distance less than 10 meters.

This is a "PROVISIONAL BUILDING PLAN" approved only for the purpose of inviting objections from the general public.

Manoj Kumar
Architect

Manoj Kumar
Architect

Manoj Kumar
Architect

NOTE:-

- BUILDING HAS AUTOMATIC SPRINKLER SYSTEM AS PER REQUIRED BY NBC.
- BUILDING WILL BE DESIGNED (STRUCTURES) AS PER RELEVANT IS CODES FOR EARTH QUAKE RESISTANCE.
- BUILDING IS ARTIFICIALLY LIGHTED MECHANICALLY VENTILATED & CENTRALLY AIRCONDITIONED WITH 100% POWER BACKUP.

KEY PLAN

BUILDING 2

BUILDING 3

LEGEND FOR PLUMBING:-

S.NO.	SYMBOL	DESCRIPTION
01.	①	110 OD SOIL PIPE
02.	②	110 OD WASTE PIPE
03.	③	75 OD ANTISIPHONAGE PIPE
04.	④	DOMESTIC WATER SUPPLY HYDRO-PNEUMATIC
05.	⑤	DOMESTIC WATER SUPPLY HYDRO-PNEUMATIC
06.	⑥	FLUSHING WATER SUPPLY HYDRO-PNEUMATIC
07.	⑦	110 OD TERRACE RAIN WATER PIPE
08.	⑧	110 OD MANTY/BALCONY RAIN WATER PIPE
09.	⑨	FLOOR DRAIN
10.	⑩	FLOOR TRAP
11.	⑪	URINAL TRAP
12.	⑫	CLEAN OUT PLUG
13.	⑬	SOIL PIPE
14.	⑭	WASTE PIPE
15.	⑮	VENT PIPE
16.	⑯	RAIN WATER PIPE
17.	⑰	DOMESTIC WATER PIPE
18.	⑱	FLUSHING WATER PIPE

Architects:
Arco Associates Pvt. Ltd.
Plot-36b, Sec-32, Gurgaon-122001
Ph.: +91-124-4595500 FAX: +91-124-4595550
Montreal, Toronto, New-Delhi, Boston

Project:
PROPOSED REVISED BUILDING PLAN OF
COMMERCIAL
COLONY AREA MEASURING 32.36 ACRES PART
OF RESIDENTIAL PLOTTED COLONY NAMELY
DLF CITY PHASE II/III AND INDEPENDENT
COMMERCIAL COLONY 4.00 ACRES (LICENCE
NO.89 OF 2018)
DATED 07.09.2018) BY MAKING TOTAL AREA
MEASURING 36.36 ACRES UNDER TOD ZONE
IN SECTOR -24 & 25A GURGRAM MANESAR
URBAN COMPLEX BEING DEVELOPED BY DLF
LIMITED AND OTHERS.

DRAWING TITLE:-
TYP. FLOOR PLAN - FAR
BUILDING 2

JOB NO:-
DTN/B2/07

SCALE:-
1:100

FILE:-
DATE BY:-
CHECKED BY:
VERAM BY/VERAM

ARCHITECT'S SEAL
& SIGNATURE

OWNER'S SEAL
& SIGNATURE

For DLF Limited
Authorized Signatory