

This is a "PROVISIONAL BUILDING PLAN" approved only for the purpose of providing information to the public and not for the purpose of providing a final design. It is not to be used for construction purposes without the approval of the relevant authorities.

Architect: Arcop Associates Pvt. Ltd.
Plot-36b, Sec-32, Gurgaon-122001
Ph: +91-124-495500 FAX: +91-124-495550
Montreel, Toronto, New-Delhi, Boston


Project: PROPOSED REVISED BUILDING PLAN OF COMMERCIAL COLONY AREA MEASURING 32.38 ACRES PART OF RESIDENTIAL PLOTTED COLONY NAMELY DLF CITY PHASE III & III AND INDEPENDENT COMMERCIAL COLONY 4.00 ACRES (LICENCE NO.59 OF 2018 DATED 07.08.2018) BY MAKING TOTAL AREA MEASURING 38.38 ACRES UNDER TOD ZONE IN SECTOR-24 & 25A GURUGRAM MANESAR URBAN COMPLEX BEING DEVELOPED BY DLF LIMITED AND OTHERS.

Note :-

- BUILDING HAS AUTOMATIC SPRINKLER SYSTEM AS PER REQUIRED BY NBC.
- BUILDING WILL BE DESIGNED (STRUCTURES) AS PER RELEVANT IS CODES FOR EARTHQUAKE RESISTANCE.
- BUILDING IS ARTIFICIALLY LIGHTED MECHANICALLY VENTILATED & CENTRALLY AIRCONDITIONED WITH 100% POWER BACKUP.

LEGEND OF SYMBOLS:

NO.	SYMBOL	DESCRIPTION
01	○	110 OD SOIL PIPE
02	○	110 OD WASTE PIPE
03	○	75 OD ANTI-SIPHONAGE PIPE
04	○	DOMESTIC WATER SUPPLY HYDRO-PNEUMATIC
05	○	DOMESTIC WATER SUPPLY HYDRO-PNEUMATIC
06	○	FLUSHING WATER SUPPLY HYDRO-PNEUMATIC
07	○	160 OD TERRACE RAIN WATER PIPE
08	○	110 OD MUMTY/BALCONY RAIN WATER PIPE
09	○	FLOOR DRAIN
10	○	UT
11	○	CLEAN OUT PLUG
12	○	SOIL PIPE
13	○	WASTE PIPE
14	○	VENT PIPE
15	○	RAIN WATER PIPE
16	○	DOMESTIC WATER PIPE
17	○	FLUSHING WATER PIPE

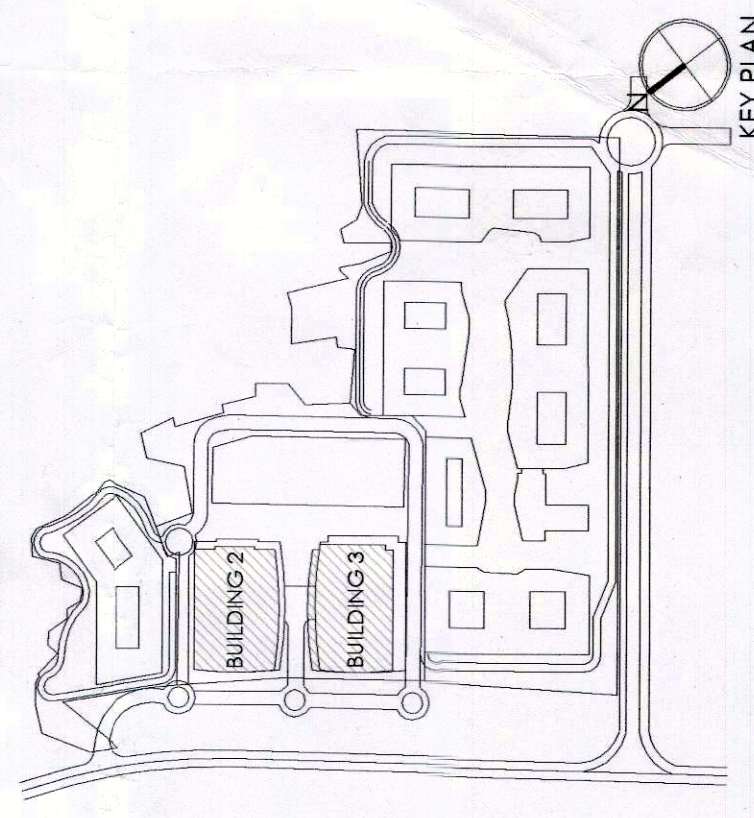


Architects:
Arcop Associates Pvt. Ltd.
Plot-36b, Sec-32, Gurgaon-122001
Ph: +91-124-495500 FAX: +91-124-495550
Montreel, Toronto, New-Delhi, Boston

DRAWING TITLE:-
6TH FLOOR (REFUGE FLOOR), FAR BUILDING 3

JOB NO.:-	DTN/B3/08	DATE:-	APPROVED BY:-
SCALE:-	1:200	DEALT BY:-	OWNER'S SEAL & SIGNATURE
FILE:-		ARCHITECT'S SEAL & SIGNATURE	

Notes:

- ALL PIPE DIAMETERS ARE IN MM.
- ALL CONNECTIONS FLOOR DRAIN TO FLOOR TRAP WILL BE 63 OD UPVC WASTE PIPE.
- ALL WASTE FROM WASH BASIN TO F.T. WILL BE 40 OD UPVC WASTE PIPE.
- ALL WASTE FROM URINALS TO U.T. WILL BE 50 OD UPVC SOIL PIPE.
- ALL PIPES FROM F.T. TO STACK WILL BE 110 OD UPVC PIPES OR OTHERWISE SPECIFIED.
- ALL PIPES FROM U.T. TO STACK WILL BE 110 OD UPVC PIPES OR OTHERWISE SPECIFIED.

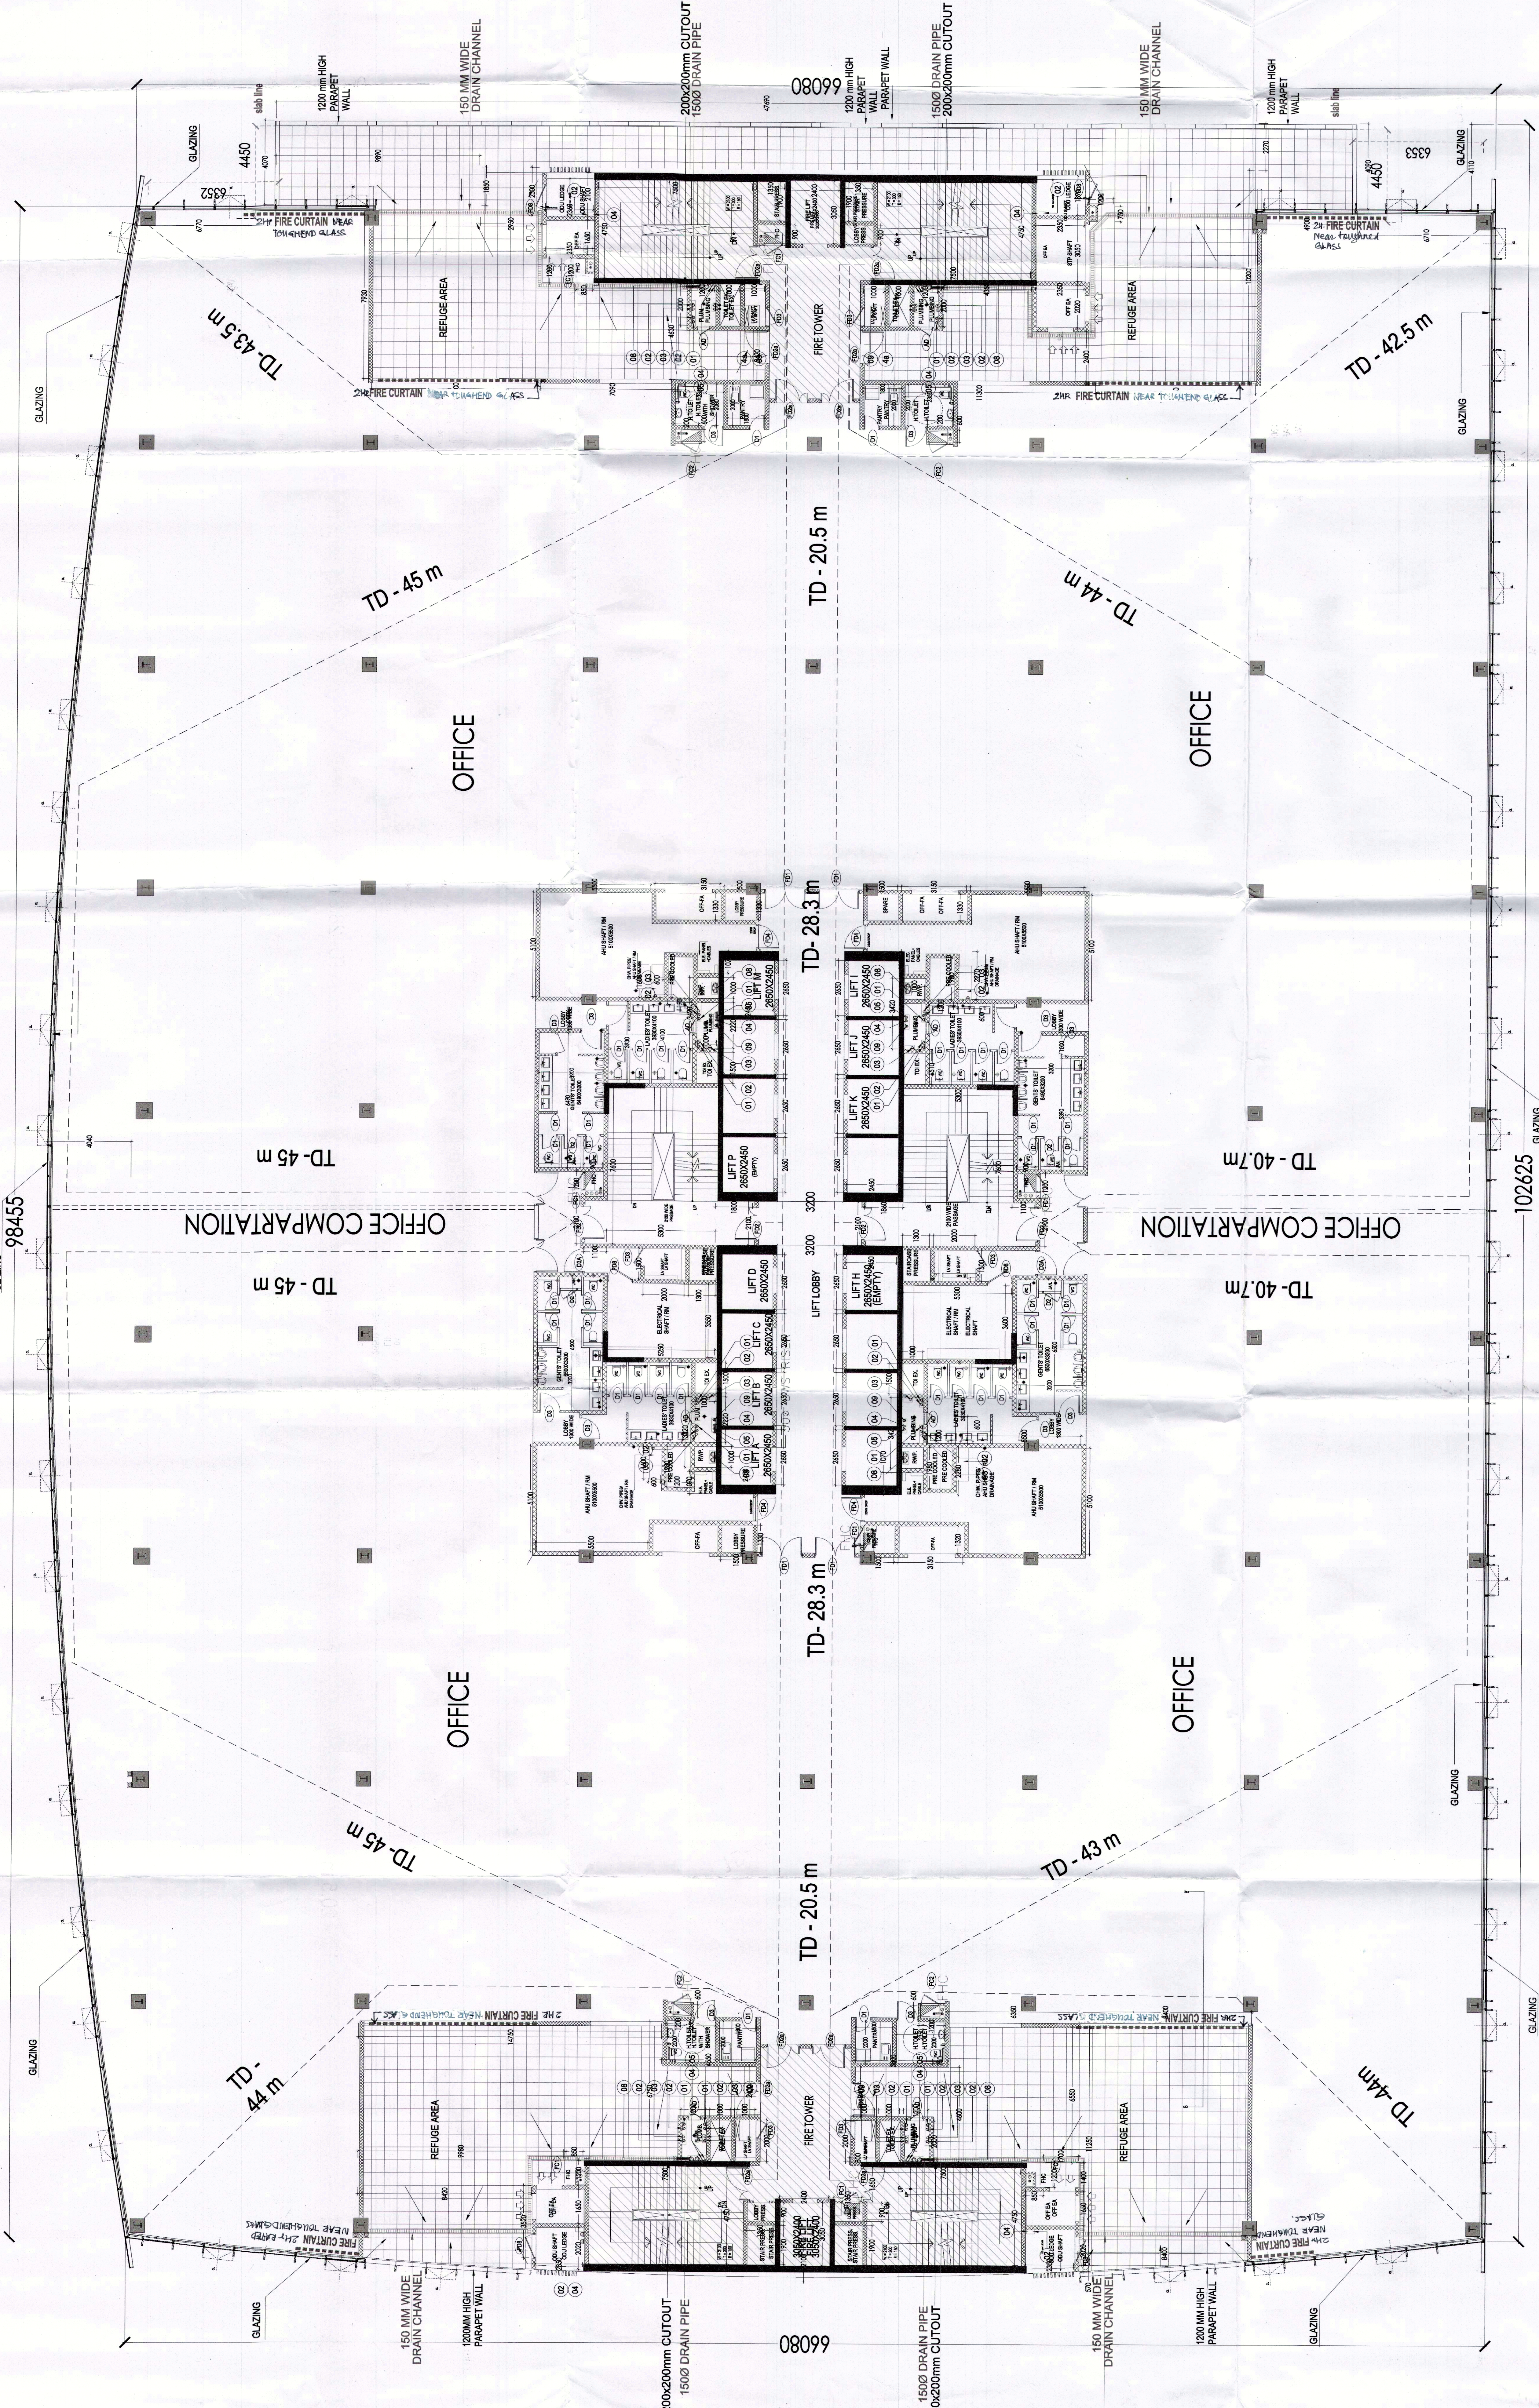

6th FLOOR PLAN- REFUGE FLOOR BUILDING 3

Note: Operable windows are provided @ c/c distance less than 10 meters.
- Compartmentation shall be 2hr partition / fire curtain.

LEVEL(+25690)

PIPE DIA'S

S.NO.	SYMBOL	DESCRIPTION
1	WB TO FT	40 OD
2	URINAL TO UT	50 OD
3	FD TO FT	63 OD
4	FT/UT TO VERTICAL STACK	110 OD
5	WC TO VERTICAL STACK	110 OD