

Note:

1. BUILDING WILL BE DESIGNED (STRUCTURES)
AS PER RELEVANT IS CODES FOR EARTH QUAKE
RESISTANCE.

PROJECT

PROPOSED BUILDING PLAN OF RESIDENTIAL COLONY UNDER NEW INTEGRATED LICENSING POLICY(NIP) DATED 11.05.2022 ON LAND MEASURING 116.29625 ACRES (LICENCE NO. 219 OF 2023 DATED 25.10.23) (AN AREA MEASURING 103.05625 ACRES MARGINATION FROM LICENCE NO. 27 OF 2021 DATED 02.04.2012) AND 02.34 ACRES AS FRESH AS FRESH APPLIED AREA IN SECTOR - 76 & 77, GURGOGRAM, GATEWAY URBAN COMPLEX, BEING DEVELOPED BY DLF LTD IN COLLABORATION WITH LAND OWNERS AND 3'S ASSOCIATE COMPANIES

DESIGN ARCHITECTS

Arcop Associates Pvt. Ltd.,
Plot No.-36B, Institutional Area
Sector-32, Gurgaon,
Haryana-122001.

ASSOCIATE ARCHITECTS

R|S|N|S
ARCHITECTS

RSMS ARCHITECTS PVT. LTD.
69, Noro Niwas Bhowani Kunj
(Behind D2), Vasant Kunj,
New Delhi-110070.
Tel.: 011-26898616, 26898617
www.rsms-arch.com

SANCTIONED
TO BE READ WITH THIS OFFICE
MEMO NO.: 42259
DATED: 13-12-2023

DBP/H
Mentor
BPAC

ARCHITECT'S SEAL
& SIGNATURE


OWNER'S SEAL
& SIGNATURE

For DLF Limited
Shankar
Authorised Signatory


SEP.-2023	Scale : 1:100	
Drawing Title:-		Drawing No

FAR AREA CALCULATION OF (1ST TO 40TH FLOOR PLAN) 41ST PENHOUSE & MILITARY


ELECTRICAL/BATTERY ROOM AREA
(TOWER - A,B,C,D,E,F & G)

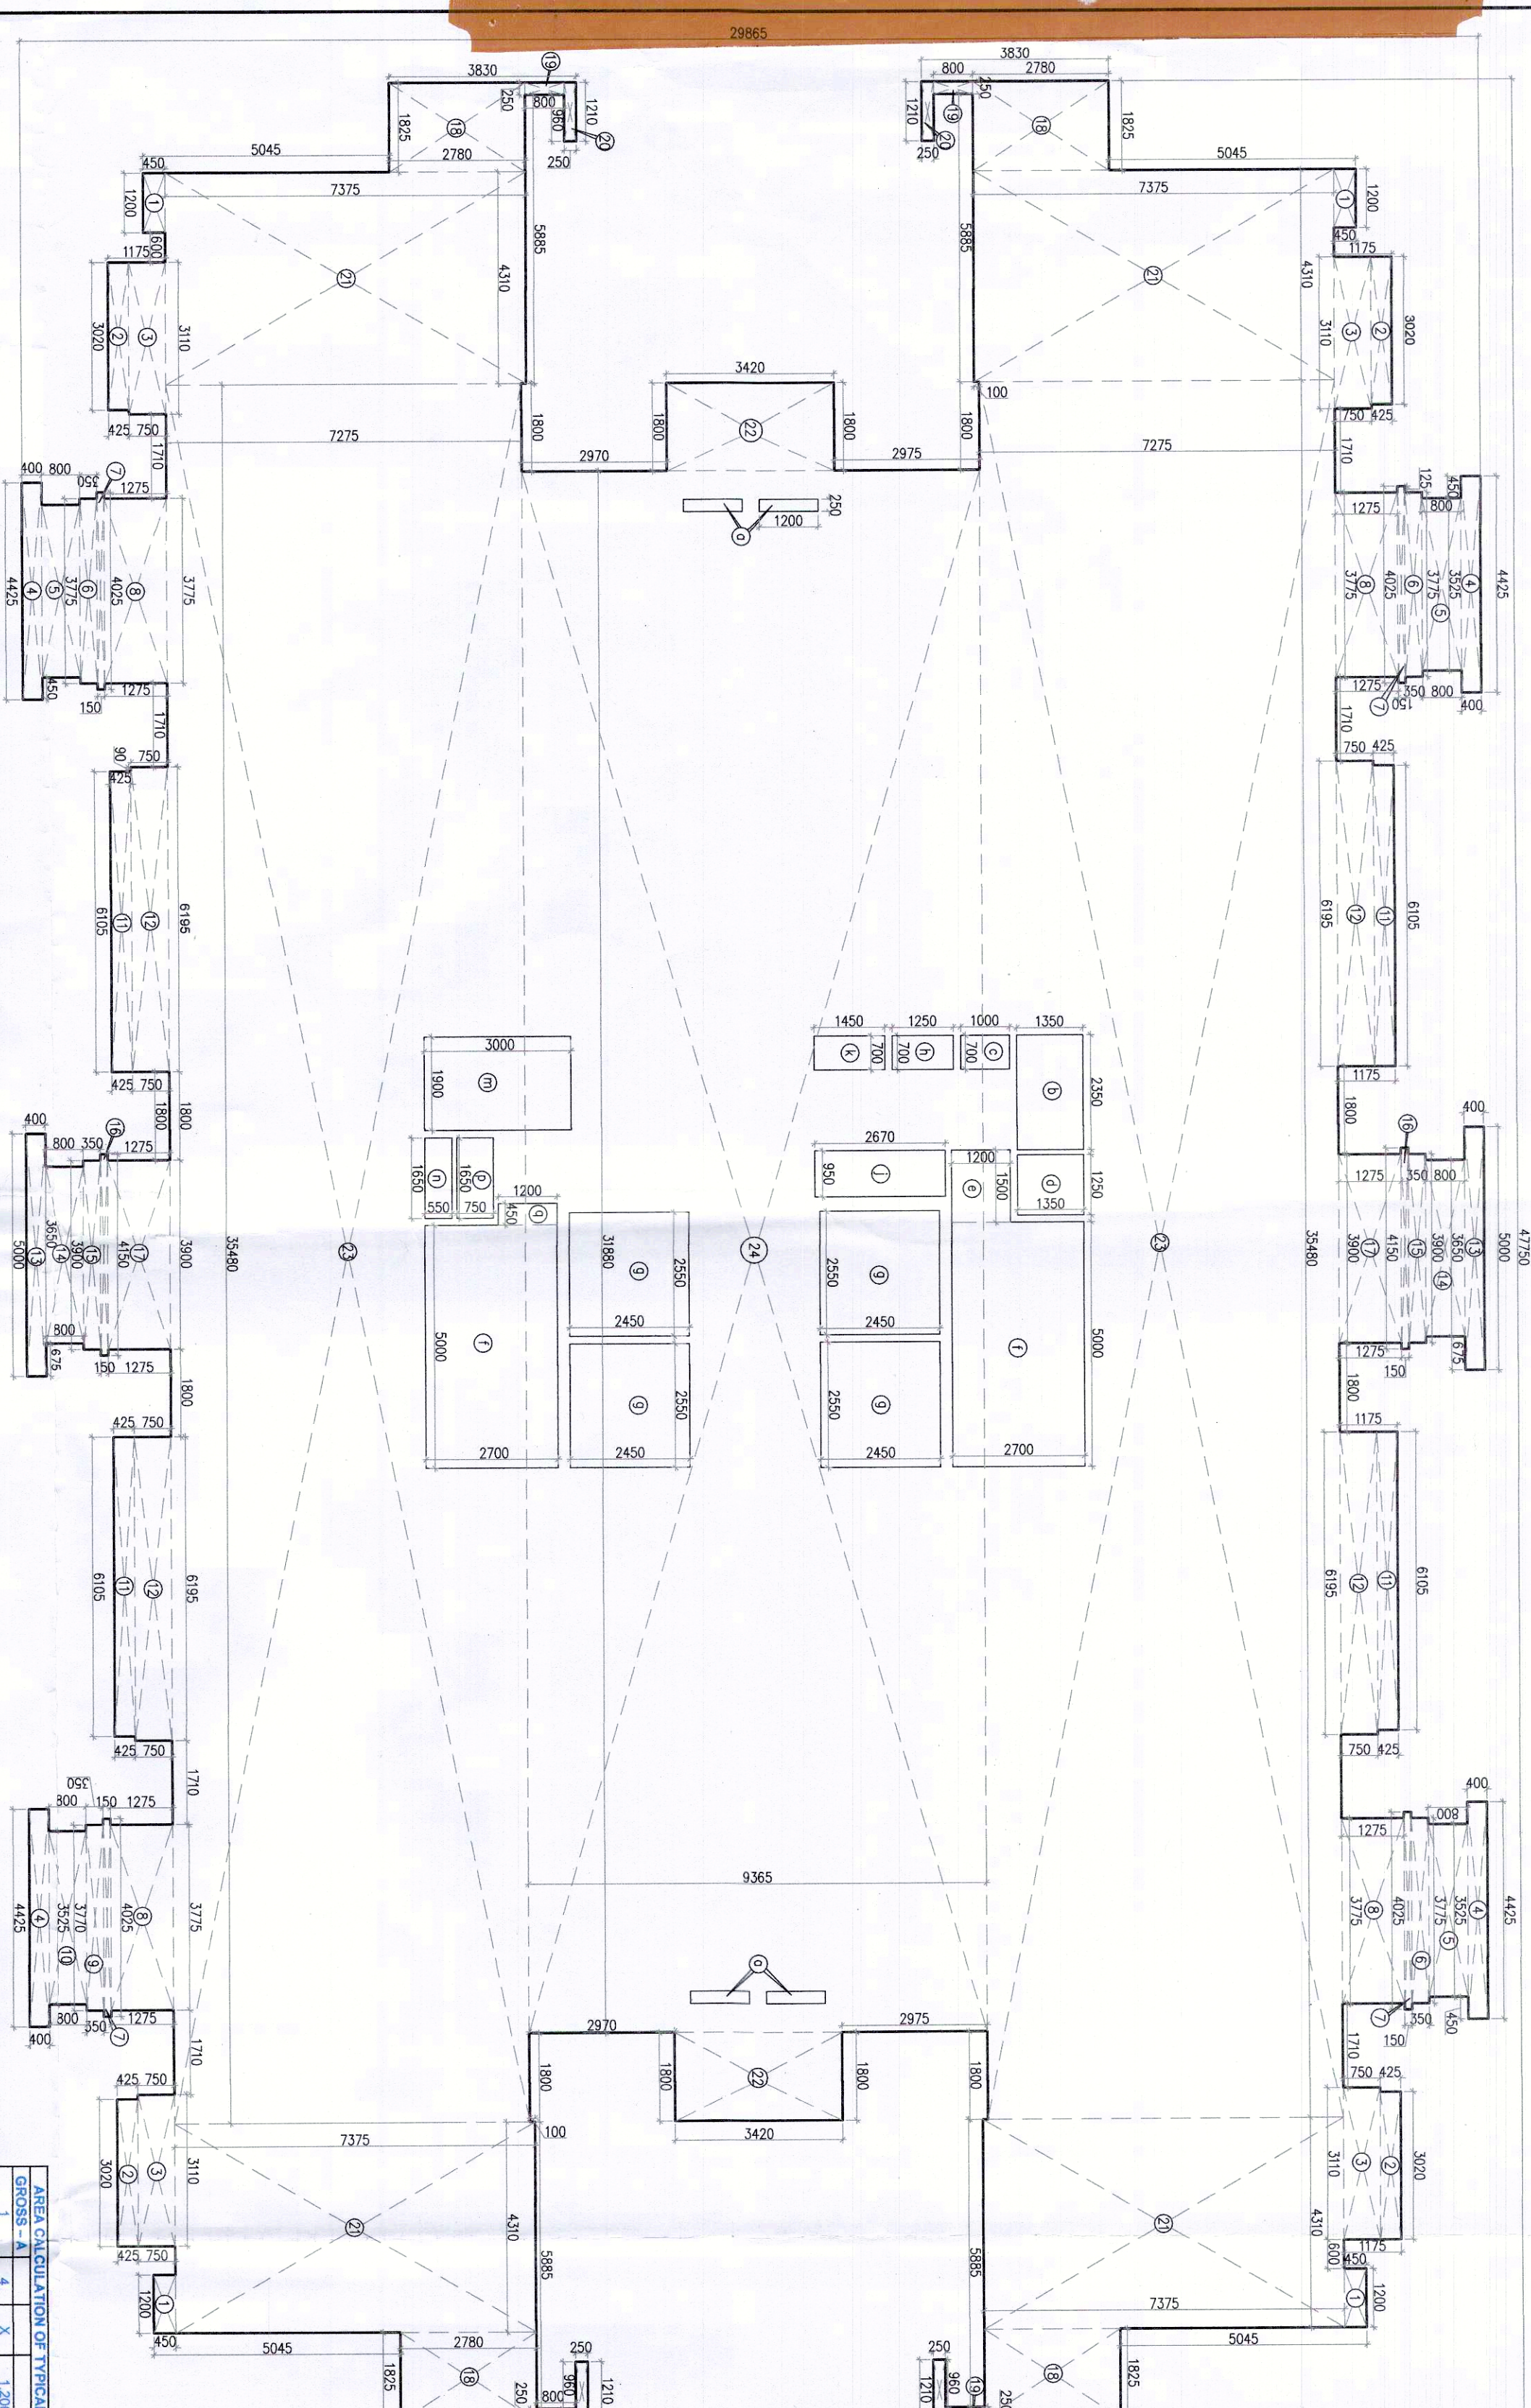


TYPICAL (1st TO 16th, 18th TO 25th, 27th TO 34th, 36th TO 40th) FLOOR AREA CALCULATION

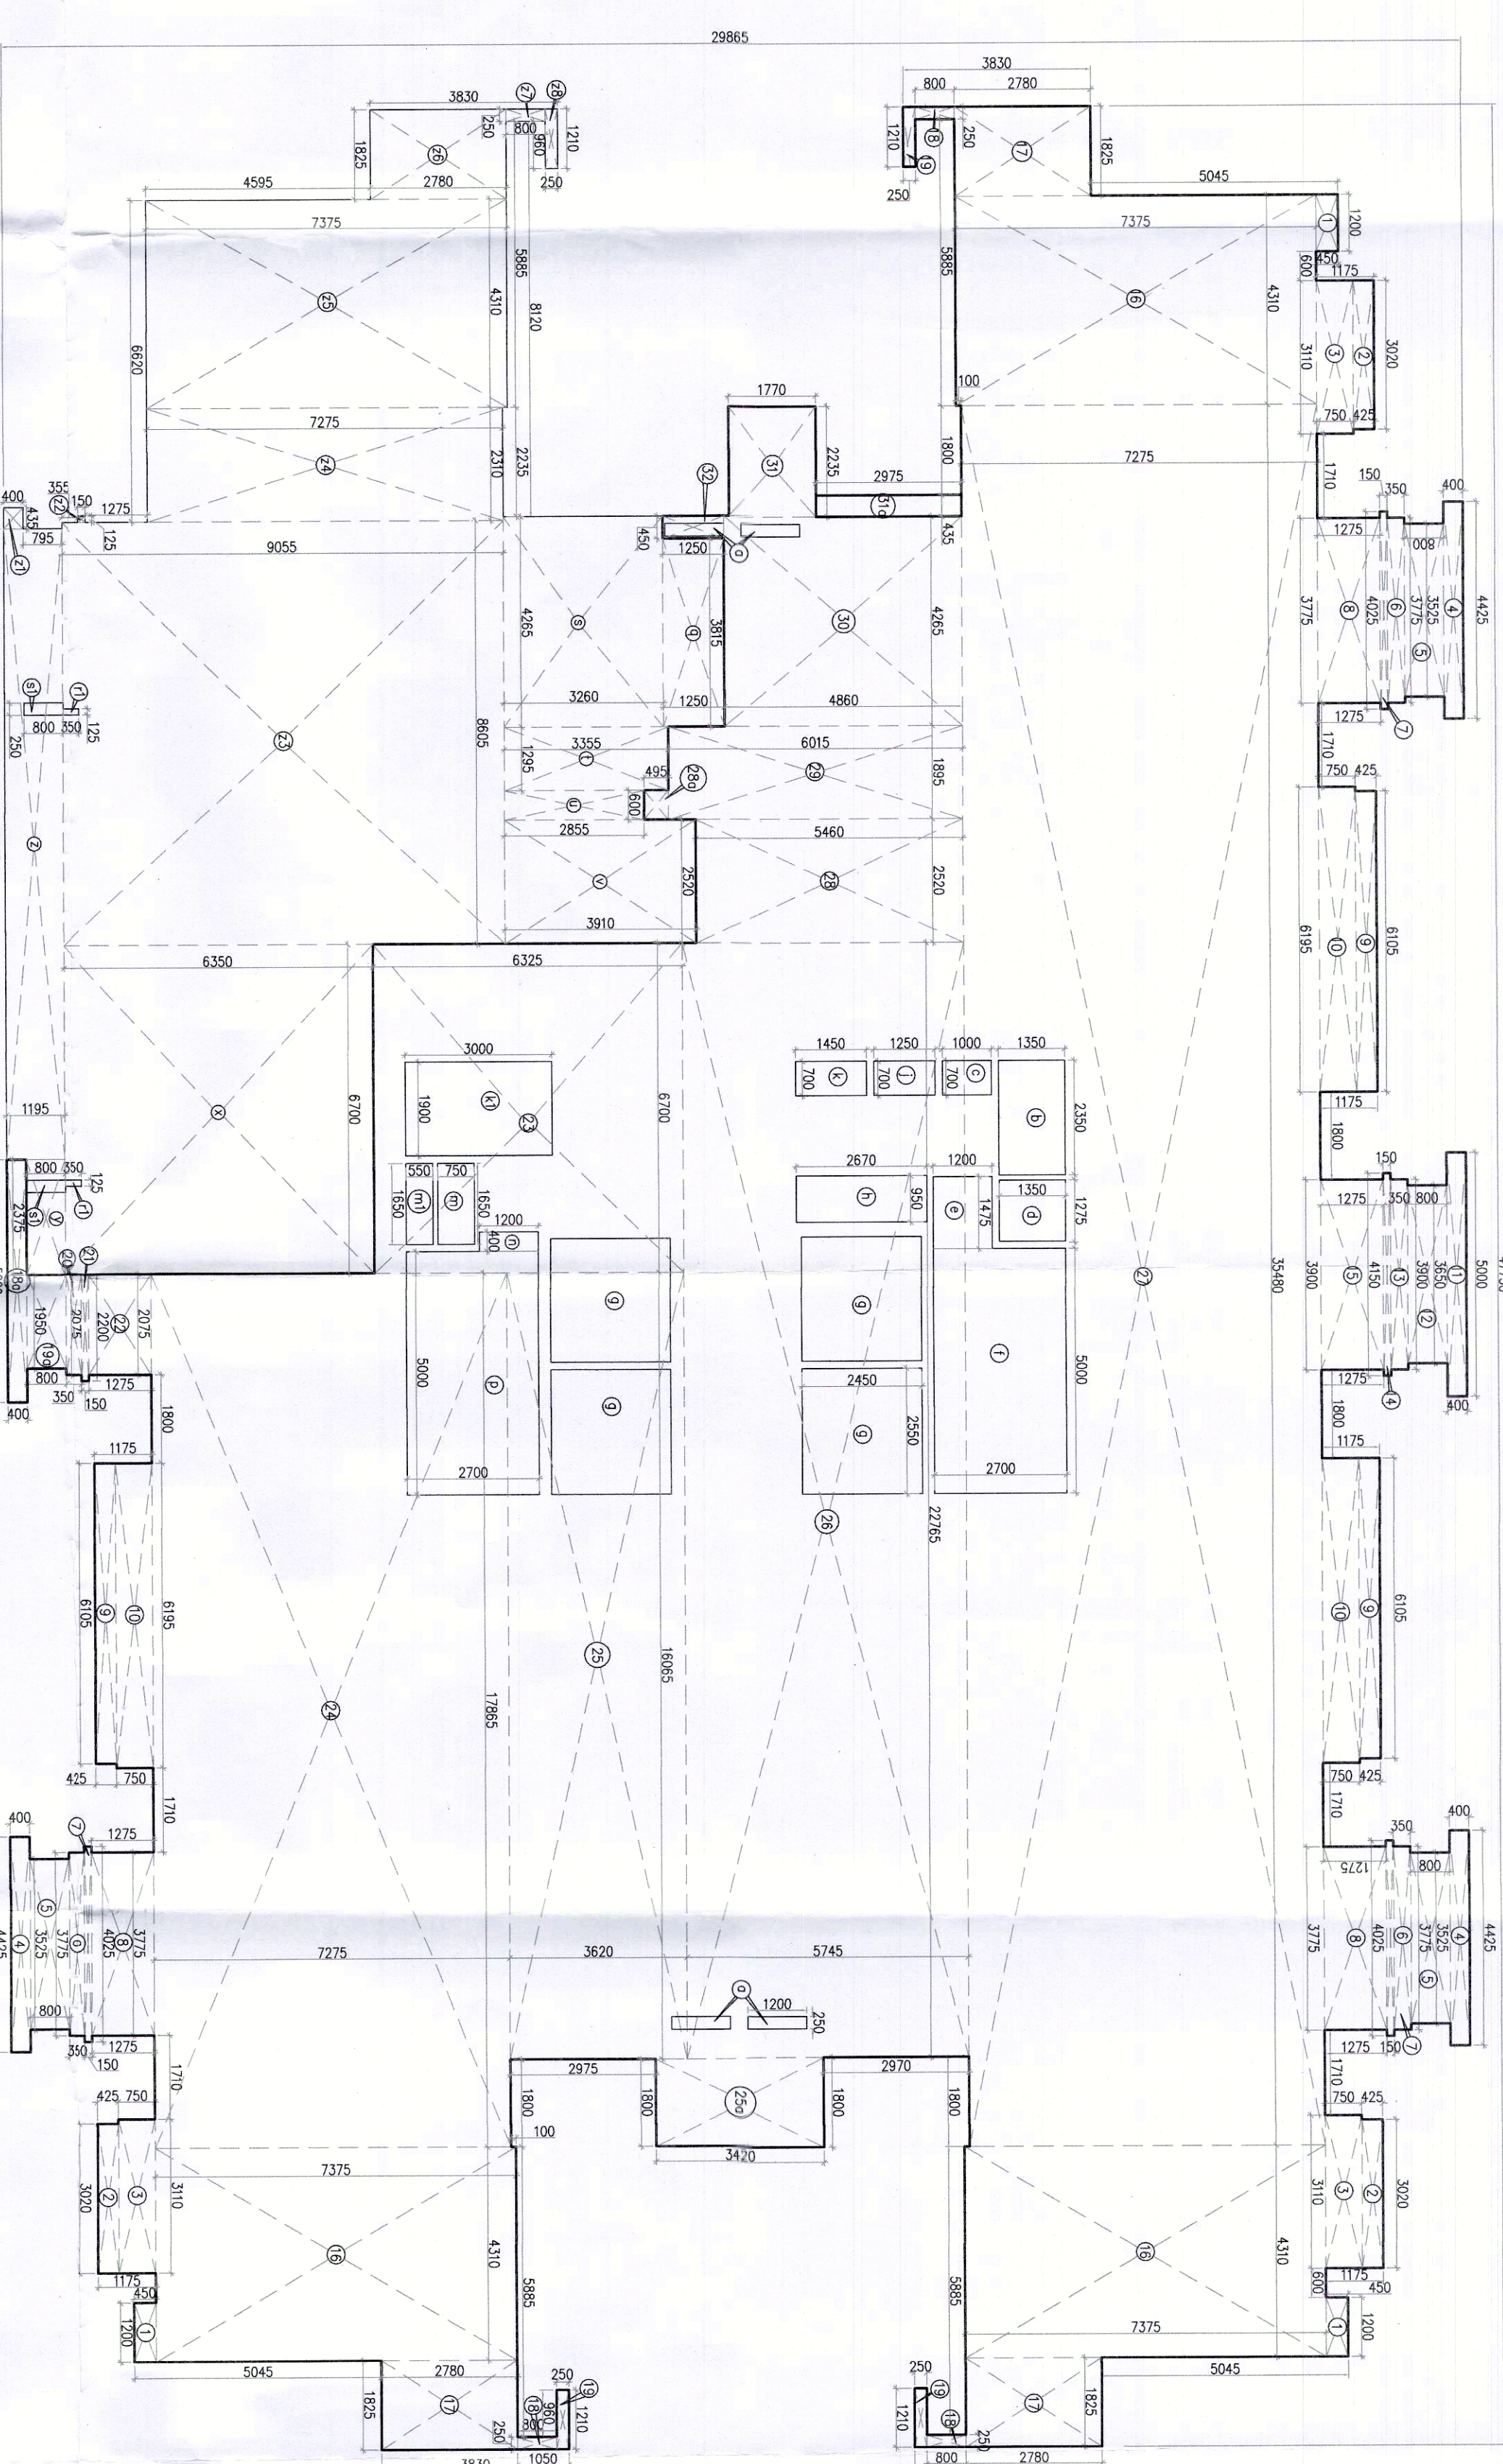


TYPICAL REFUGE (17th, 26th & 35th) FLOOR AREA CALCULATION
TOWER-A,B,C,D,E,F,G

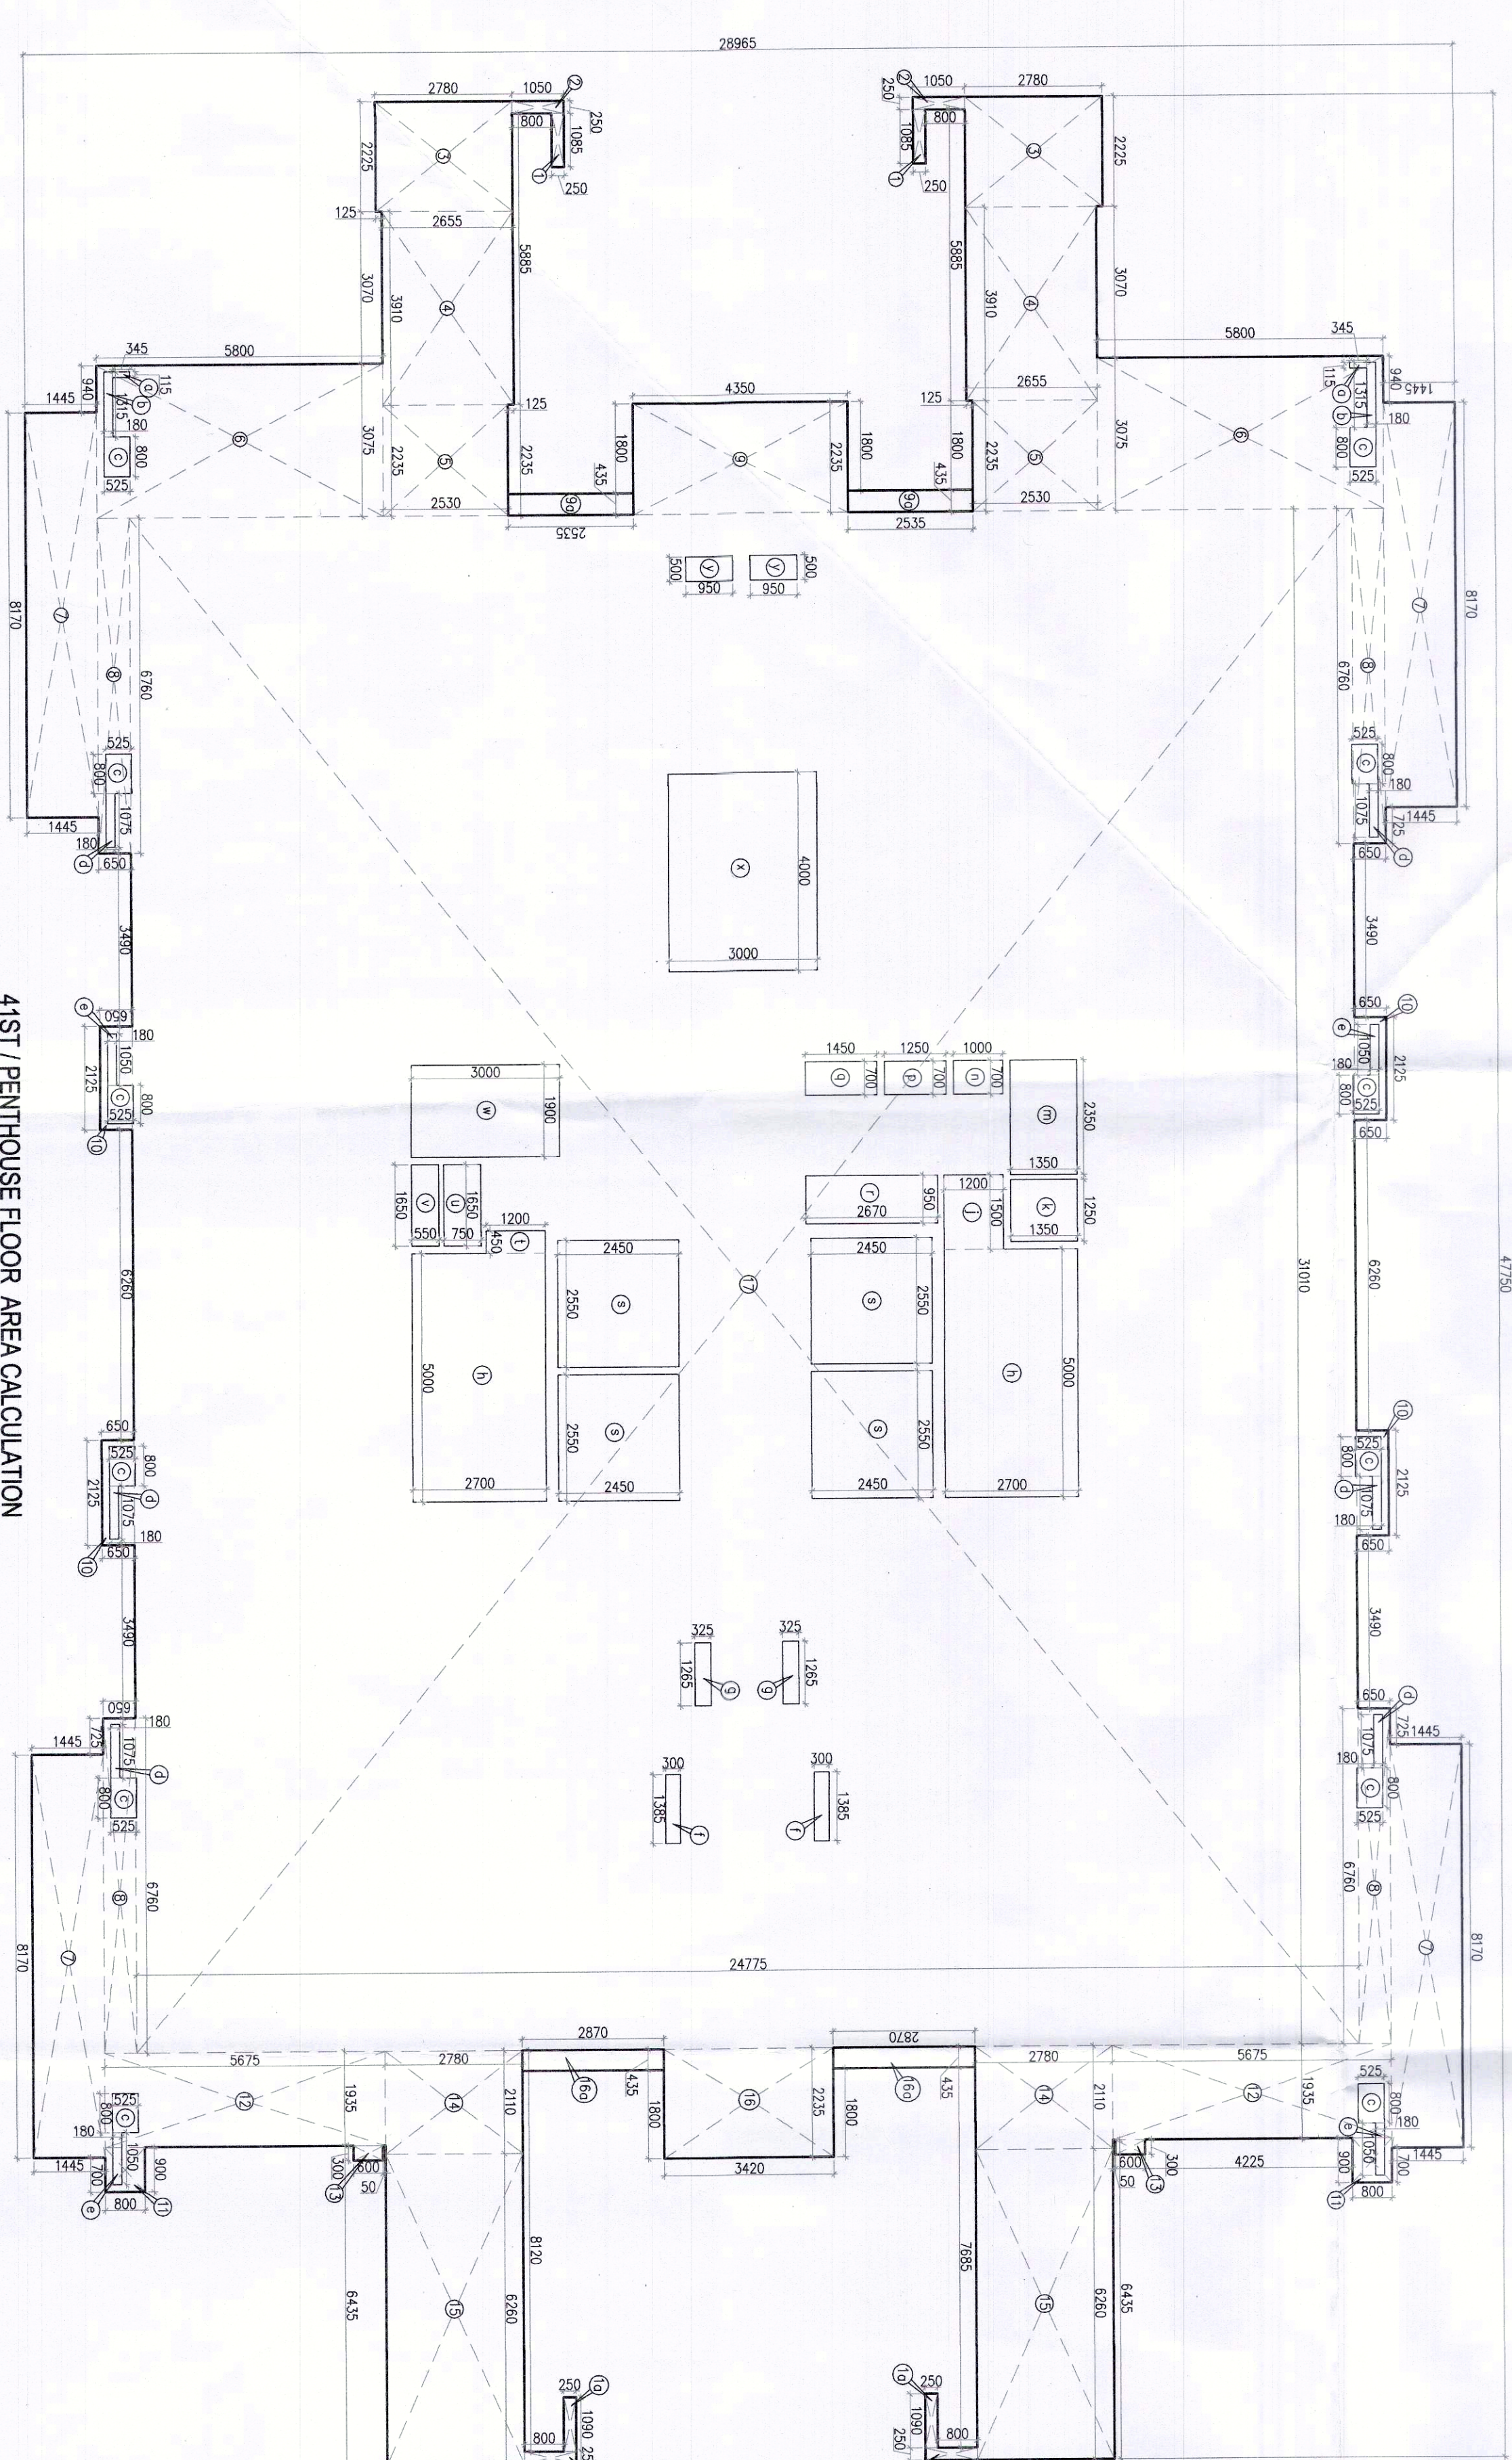[illegible][illegible][illegible]

41ST / PENTHOUSE FLOOR AREA CALCULATION

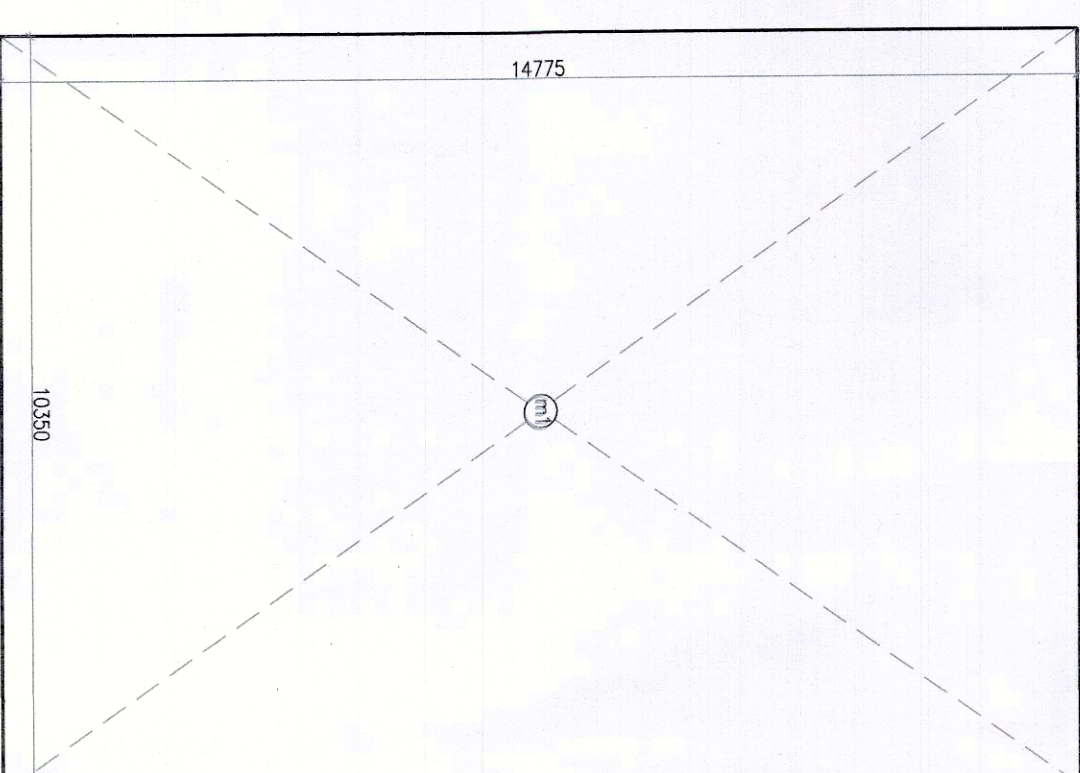[illegible]

MUMTY AREA

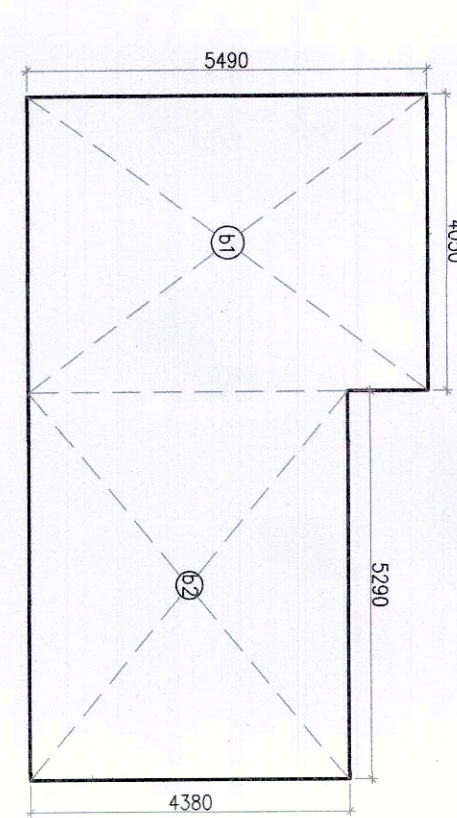

ELECTRICAL & BATTERY ROOM ARE

ELECTRICAL & BATTERY ROOM AREA CALCULATION									
GROSS - A									
b1	=	1	X	4.050	X	5.400	=	22.235	SQM
b2	=	1	X	5.290	X	4.350	=	23.170	SQM
						TOTAL	=	45.405	SQM

MUMTY / NON FAR AREA CALCULATION					
GROSS - A					
m1	=	1	X	10.350	X
					14.775
					=
					152.921
					TOTAL
					=
					152.921
					SQM