

DRG NO. BBST-03

Checked and found OK for Field Work.
(Vertical) Services only subject to comments in the drawing.
Additional Civil Engineer
HPP/P. Permissible

DDVT MEMBER BPAC
PA
JD.

TO BE READ WITH THIS OFFICE DRAWING
NO. 19/241
DATED: 11-7-2022

KEY PLAN

Architect Hafeez Contractor
35, Janki S Park, Borey, 08 02, 16164826

RISIMIS ARCHITECTS
RISMS ARCHITECTS PVT. LTD.
89, Nara Nivas, Bhawanil Kunj
(Behind D2), Vasant Kunj,
New Delhi-110070.
Tel: 011-26888816, 26888617
www.risimis-arch.com


REVISED BUILDING PLANS OF BUILDING B.C. D. 12, & P IN CYBER CITY UNDER TRUST ORIENTED DEVELOPMENT (OD) POLICY FOR MIXED COMMERCIAL, MC-03/004, 108-55522 ACRES IN SECTOR 24, 25 & 25-A, GURUGRAM, HARYANA. URBAN COMPLEX BEING DEVELOPED BY DLF CYBER CITY DEVELOPERS LIMITED.

DLF DLF Cyber City Developers Ltd.
10th Floor DLF Gateway Tower,
DLF Cyber City, Gurugram,
Haryana Pin-122002

DRAWING TITLE: BLOCK-B SITE PLAN (STORM WATER SCHEME)

REVISION	DATE	BY	APPROVED BY
1	15/06/22	JD	JD

OWNER'S SEAL & SIGNATURE

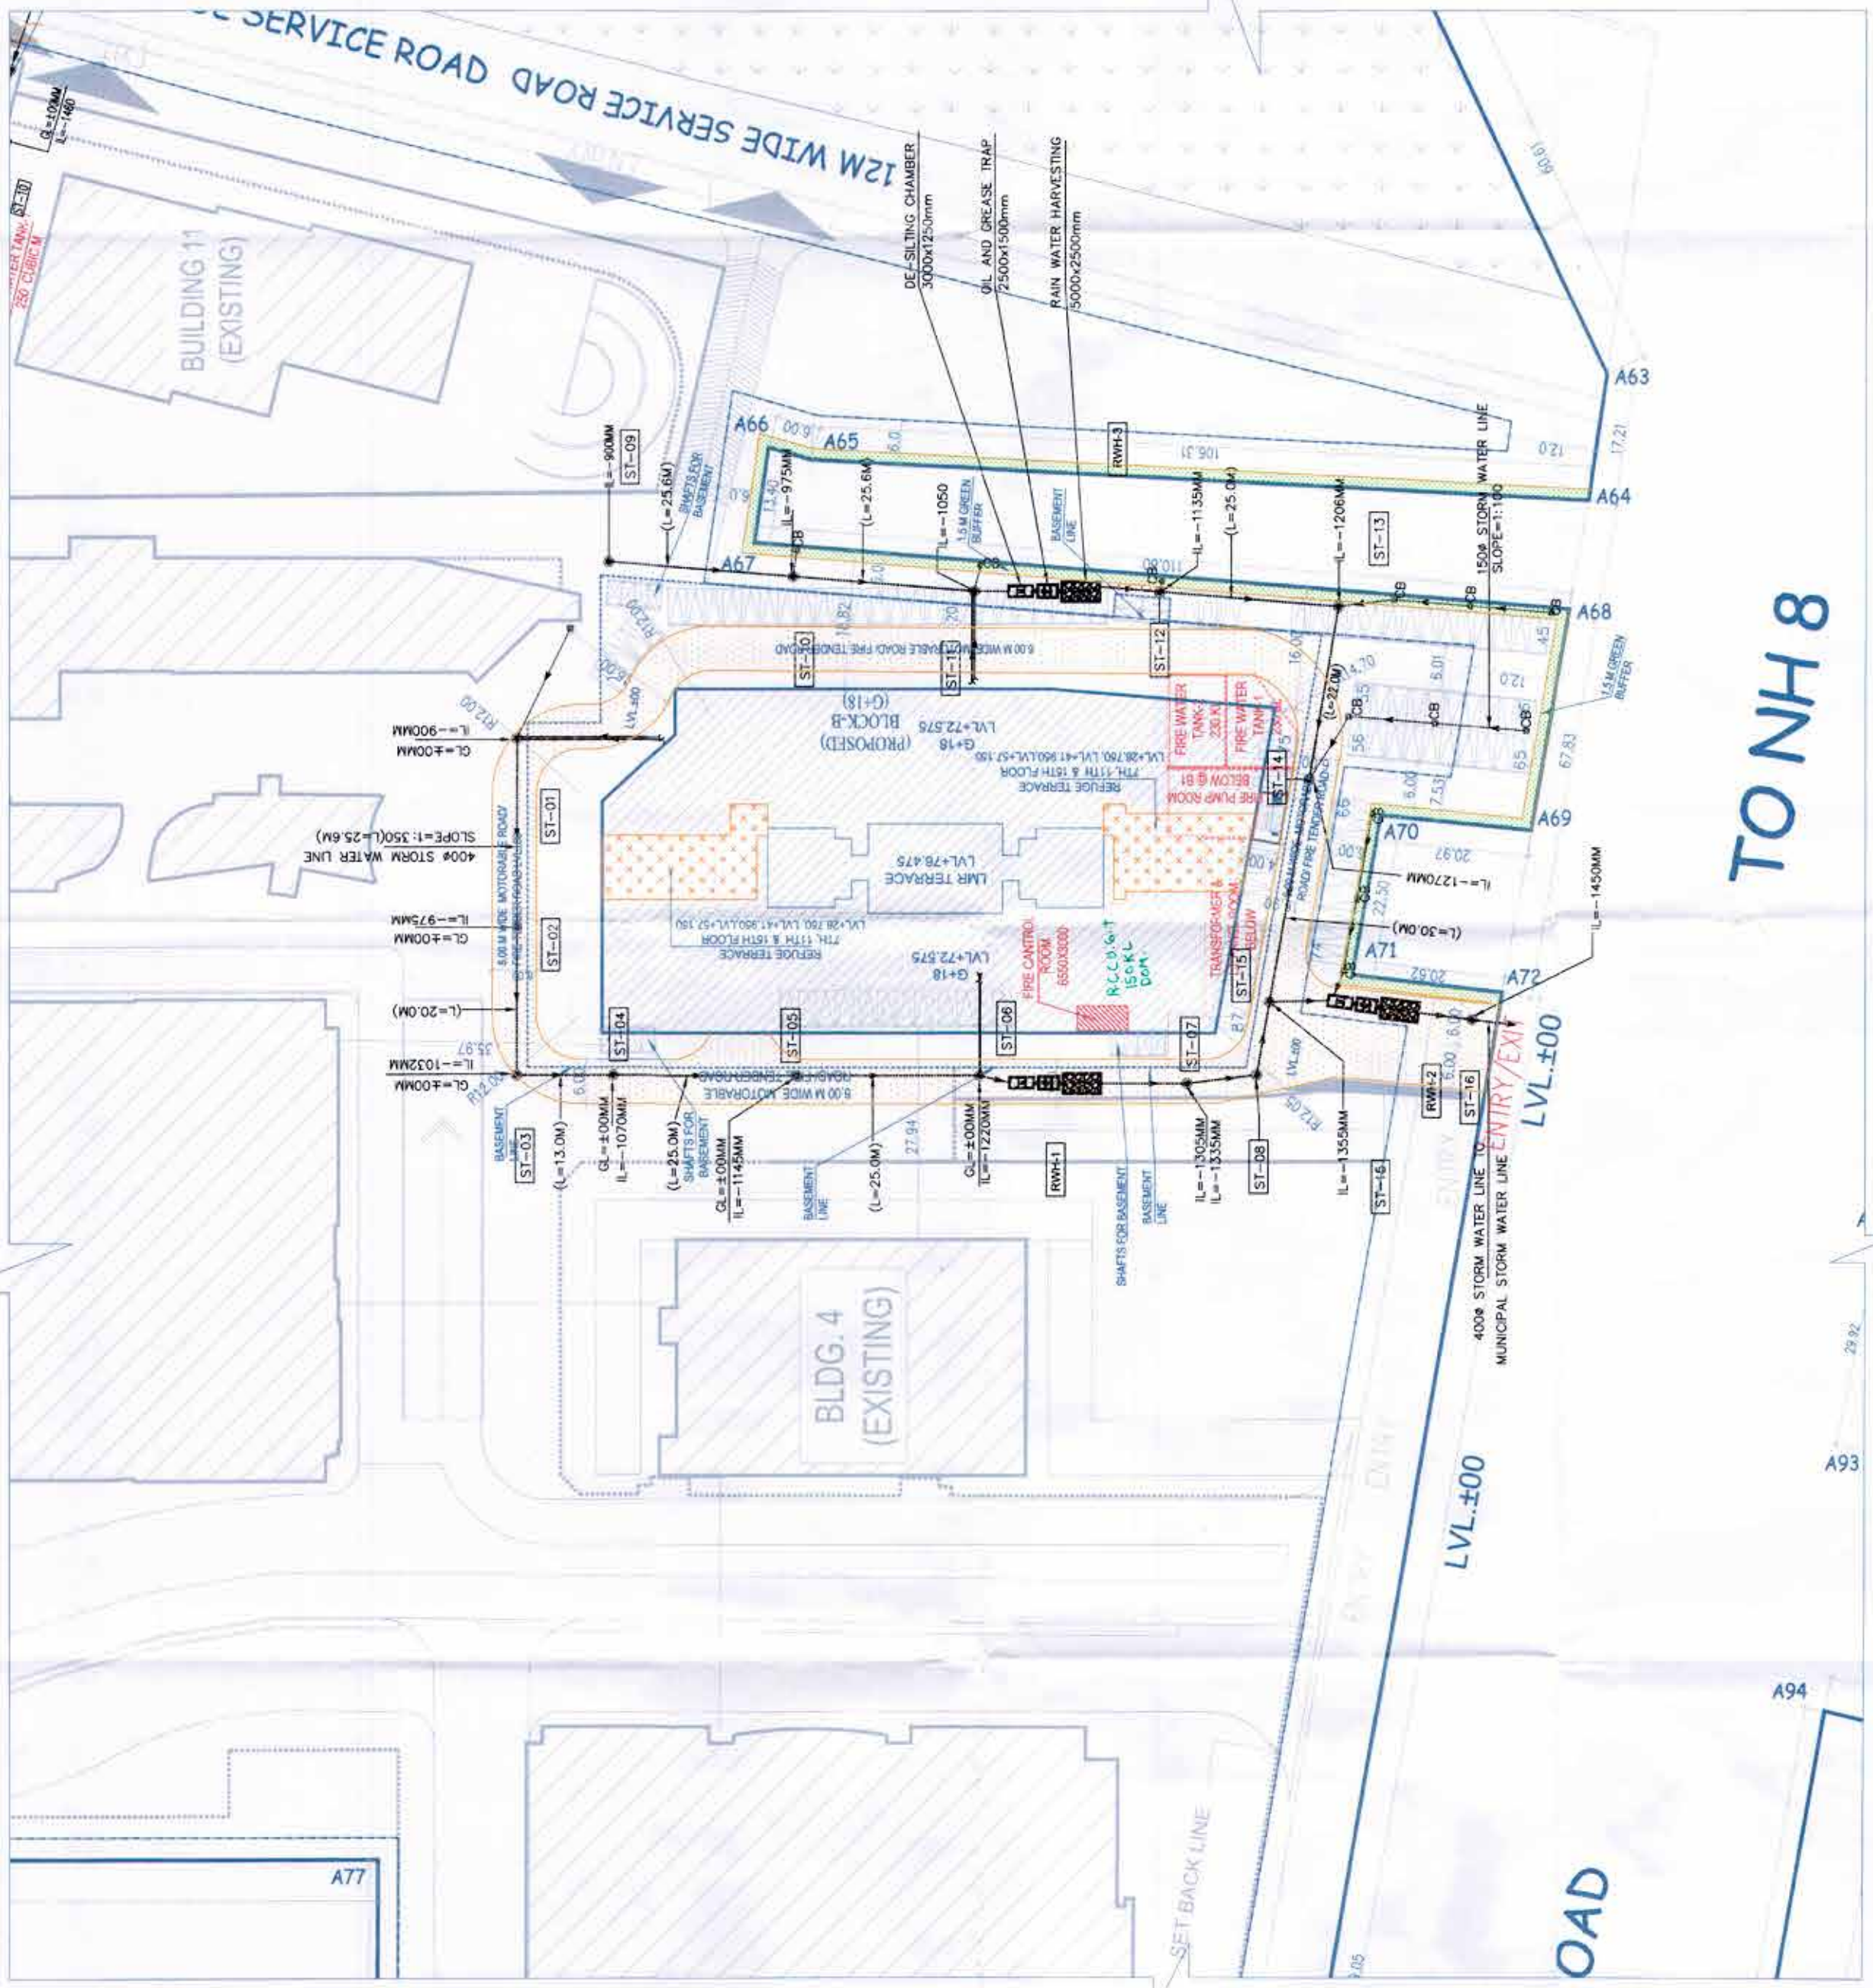

TO NH 8