


[illegible]

KEY PLAN

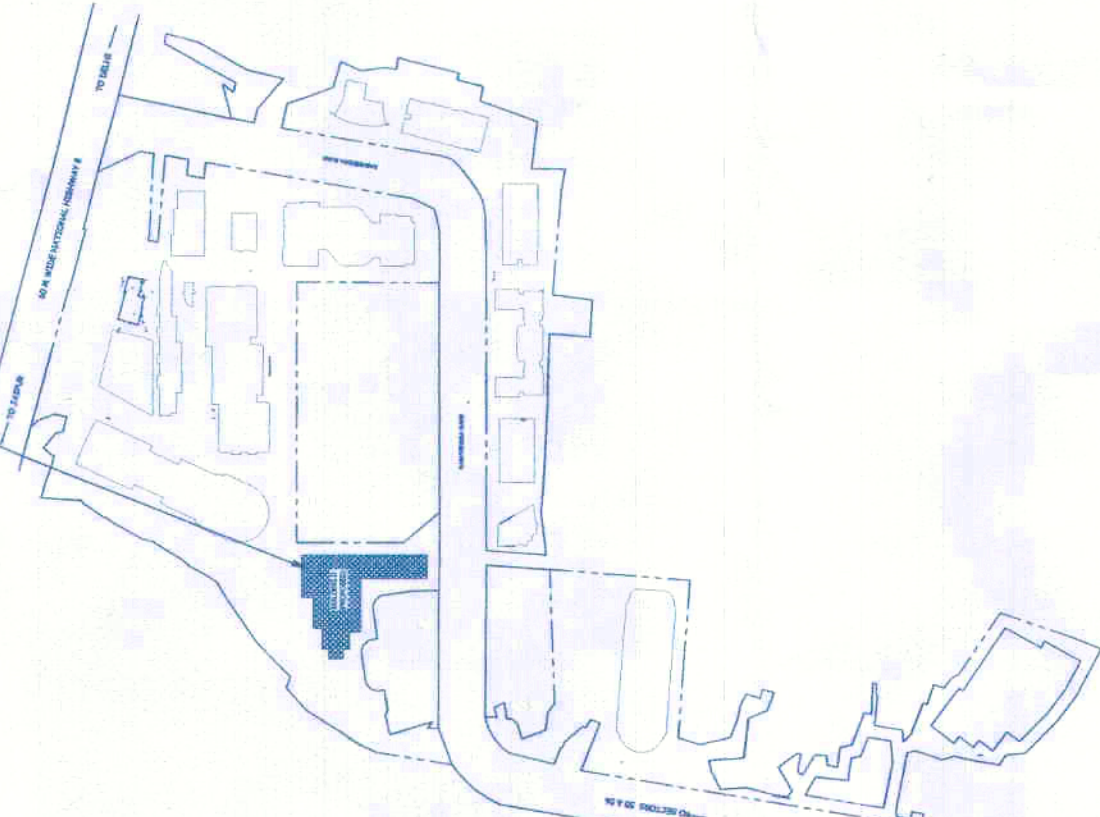

Architect Hafeez Contractor

R|S|M|S
ARCHITECTS

RSMS ARCHITECTS PVT. LTD.
69, Nora Niwas Bhawani Kunj
(Behind D2), Vasant Kunj,
New Delhi-110070.
Tel.: 011-268898616, 268898617


Project: REVISED BUILDING PLANS OF BUILDING-B, C, D, E, & F IN CYBER CITY UNDER TRANSIT ORIENTED DEVELOPMENT (TOD) POLICY FOR MIX LAND USED COLONY (70% IT/ITES)+30% COMMERCIAL) MEASURING 108.55922 ACRES IN SECTOR 24, 25 & 25-A, GURUGRAM MANESAR URBAN COMPLEX BEING

DLF  OWNER: DLF Cyber City Developers Ltd.
10th Floor DLF Gateway Tower,
DLF Cyber City, Gurugram, Haryana
Pin: 122002

DRAWING TITLE: -

III

REVISION	JOB NO.:-	DRG NO.:-	 NORTH:-
	SCALE:- 1:200	DATE:- 25-04-2022	
FILE:-	DEALT BY:-	CHECKED BY:-	APPROVED BY:-
ARCHITECT'S SEAL & SIGNATURE		OWNER'S SEAL & SIGNATURE	

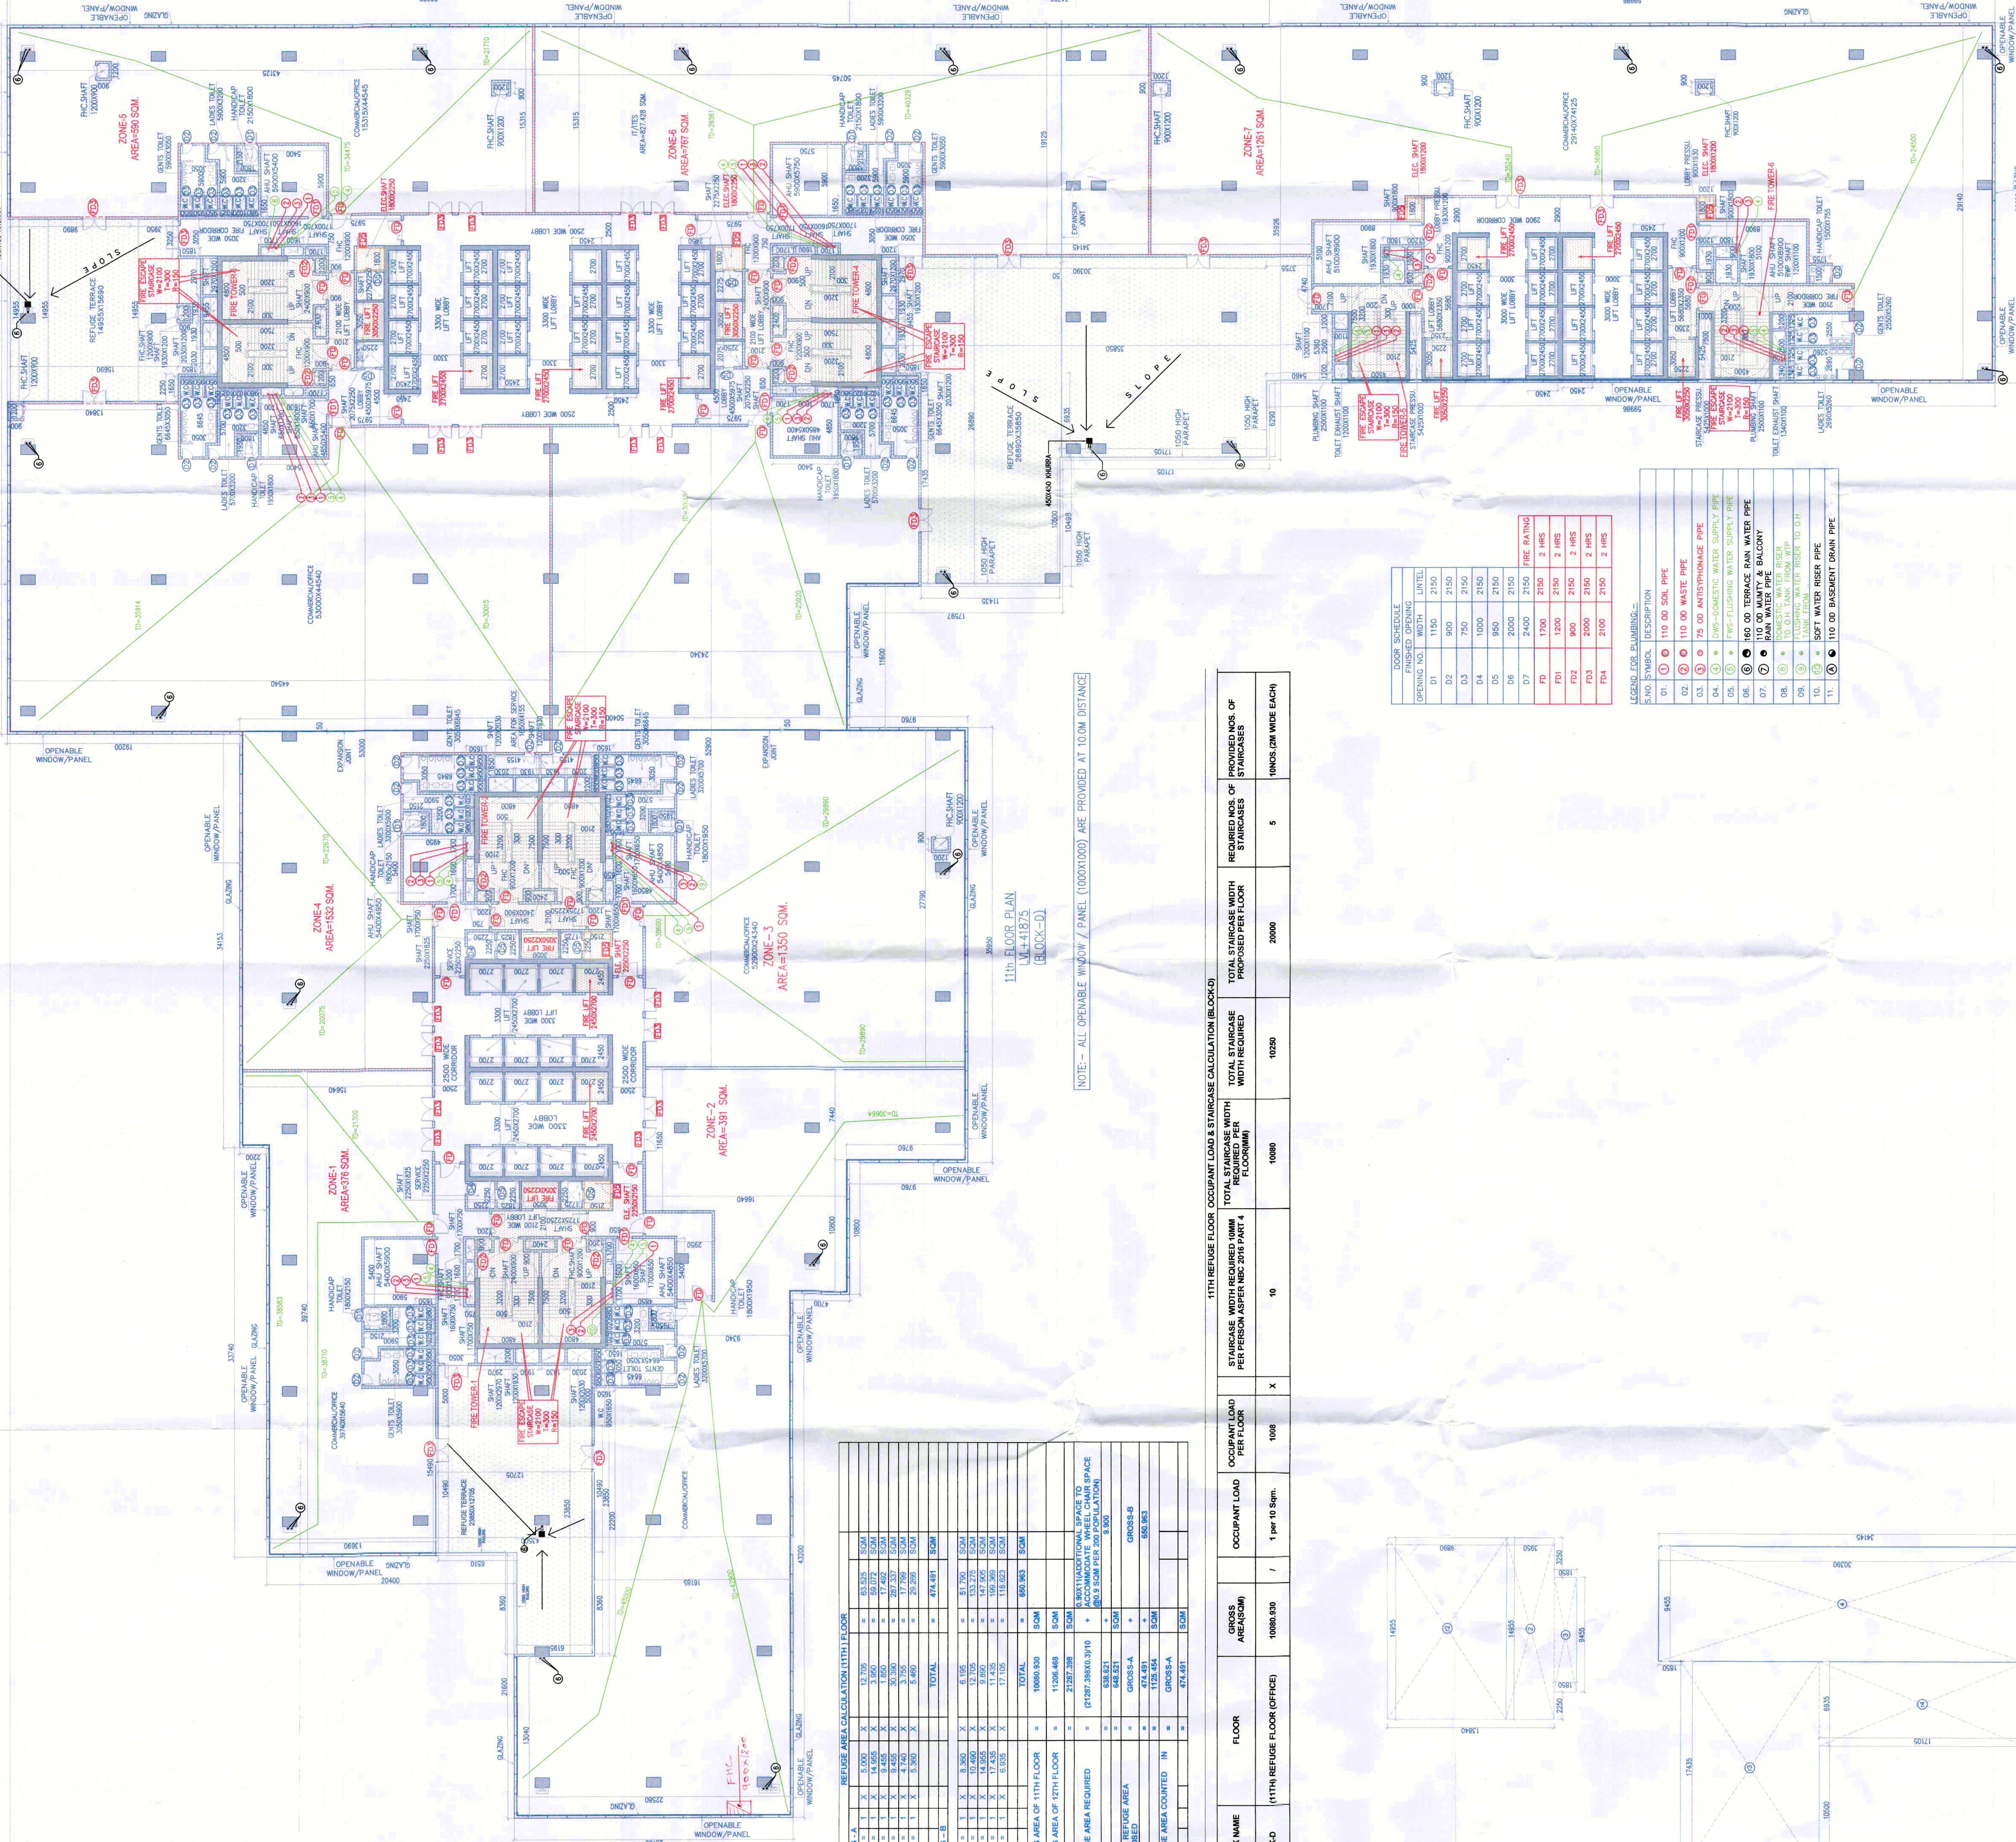

DOOR SCHEDULE	FINISHED OPENING		
	OPENING NO.	WIDTH	HEIGHT
	D1	1150	2150
	D2	900	2150
	D3	750	2150
	D4	1000	2150
	D5	950	2180
	D6	2000	2150
	D7	2400	2150
	D8	1700	2150
	D9	1200	2150
	D10	900	2150
	D11	2000	2150
	D12	2100	2150

LEGEND FOR DRAWING	
S.NO.	SYMBOL-DESCRIPTION
01.	① 110 Ø 110 SOL PIPE
02.	② 110 Ø 110 WASTE PIPE
03.	③ 75 Ø 75 ANTI-SIPHONAGE PIPE
04.	④ 75 Ø 75 DOMESTIC WATER SUPPLY PIPE
05.	⑤ 110 Ø 110 FWS-FLUSHING WATER SUPPLY PIPE
06.	⑥ 160 Ø 160 TERRACE RAIN WATER PIPE
07.	⑦ 160 Ø 160 DOWN PIPES TO BALCONY
08.	⑧ DOMESTIC WATER RISER
09.	⑨ 150 Ø 150 TANK FROM WPT
10.	⑩ 150 Ø 150 TANK RISER
11.	⑪ 150 Ø 150 WASTE RISER PIPE
12.	⑫ 160 Ø 160 BASEMENT RAIN PIPE

BLOCK NAME	FLOOR	GROSS AREA(SQM)	OCCUPANT LOAD		STAIRCASE WIDTH REQUIRED PER PERSON AS PER NBC-2018 PART 4	TOTAL STAIRCASES WITHIN FLOOR PLAN	TOTAL STAIRCASE WIDTH REQUIRED	PROVIDED NOS. OF STAIRCASES
(B) BLOCK-D	(B) FLOOR (OFFICE)	16985.930	/	1 per 10 Sqm.	X	10000	10320	5 [MINOS.(ON WIDE EACH)]

