


DRG NO. BF-04b

THIS IS A PROVISIONAL BUILDING PLAN approved only for the purpose of obtaining approvals from the general public. It is not to be used for any other purpose.

Created and approved by: **Dr. P. K. Singh**
Architect
Member
BPAAC

TO BE READ WITH THE OFFICE
NO. 1947
DATED: 19/04/2022

KEY PLAN

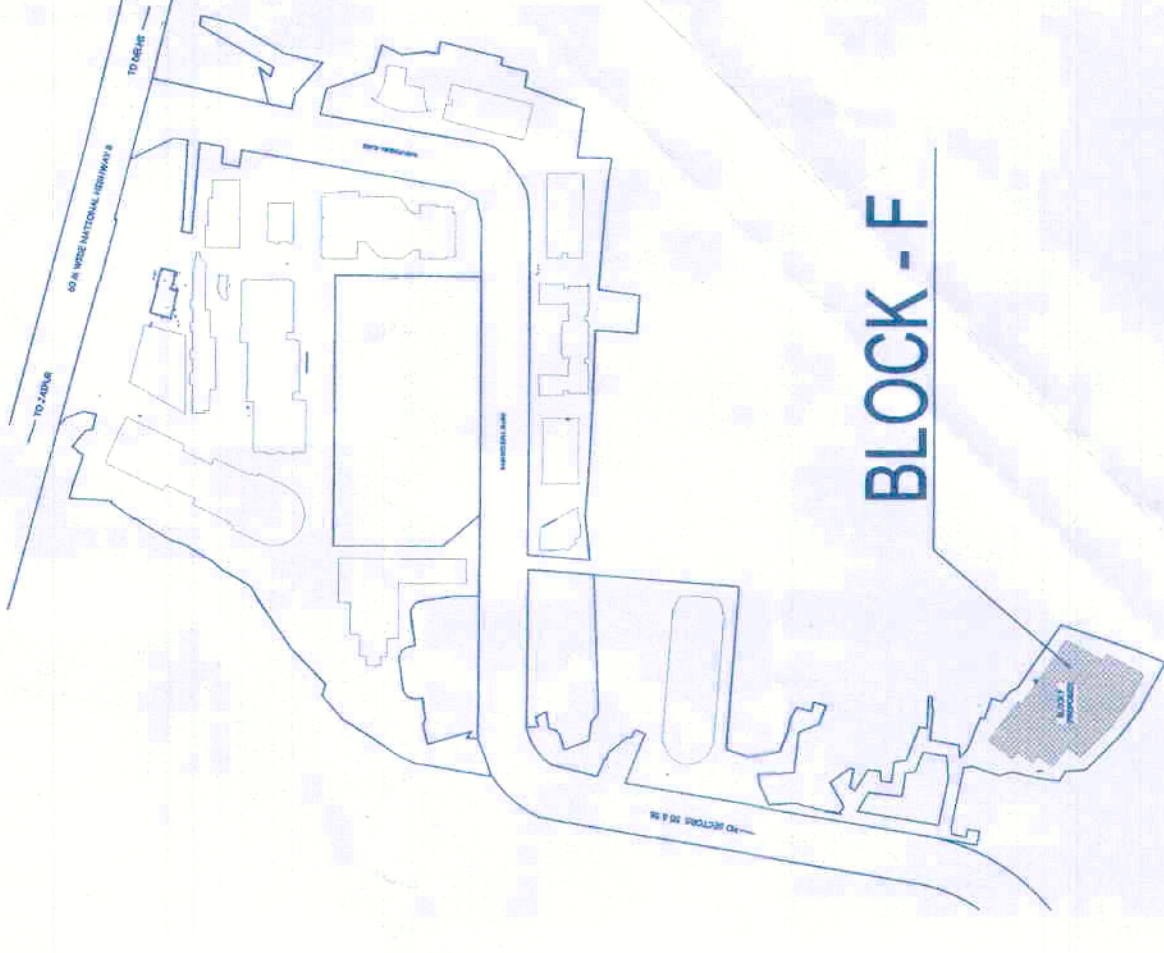

Architect
Hafeez
Contractor

RSMIS
ARCHITECTS

RSMIS ARCHITECTS PVT. LTD.
69, Nara Nivas, Bhawan Kunj
(Behind D2), Vasant Kunj
New Delhi-110070
Tel.: 011-26898616, 26898617
www.rsmis-arch.com


Project:
REVISED BUILDING PLANS OF BUILDING-B,
C, D, E, & F IN CYBER CITY UNDER TRANSIT
ORIENTED DEVELOPMENT (TOD) POLICY FOR
MIX LAND USED COLONY (70% IT/ITES / 30%
COMMERCIAL) MEASURING 108.55922 ACRES
IN SECTOR 24, 25 & 25-A, GURUGRAM
MANESAR URBAN COMPLEX BENG
DLF CYBER CITY DEVELOPERS LIMITED

OWNER: DLF Cyber City Developers Ltd
10th Floor DLF Gateway Tower,
DLF Cyber City, Gurugram, Haryana
Pin: 122002

DRAWING TITLE:-
20th FLOOR PLAN
BLOCK-F

REVISION	JOB NO.	DRG NO.	DATE	CHECKED BY	APPROVED BY
		BF-04b	25-04-2022		

OWNER'S SEAL & SIGNATURE

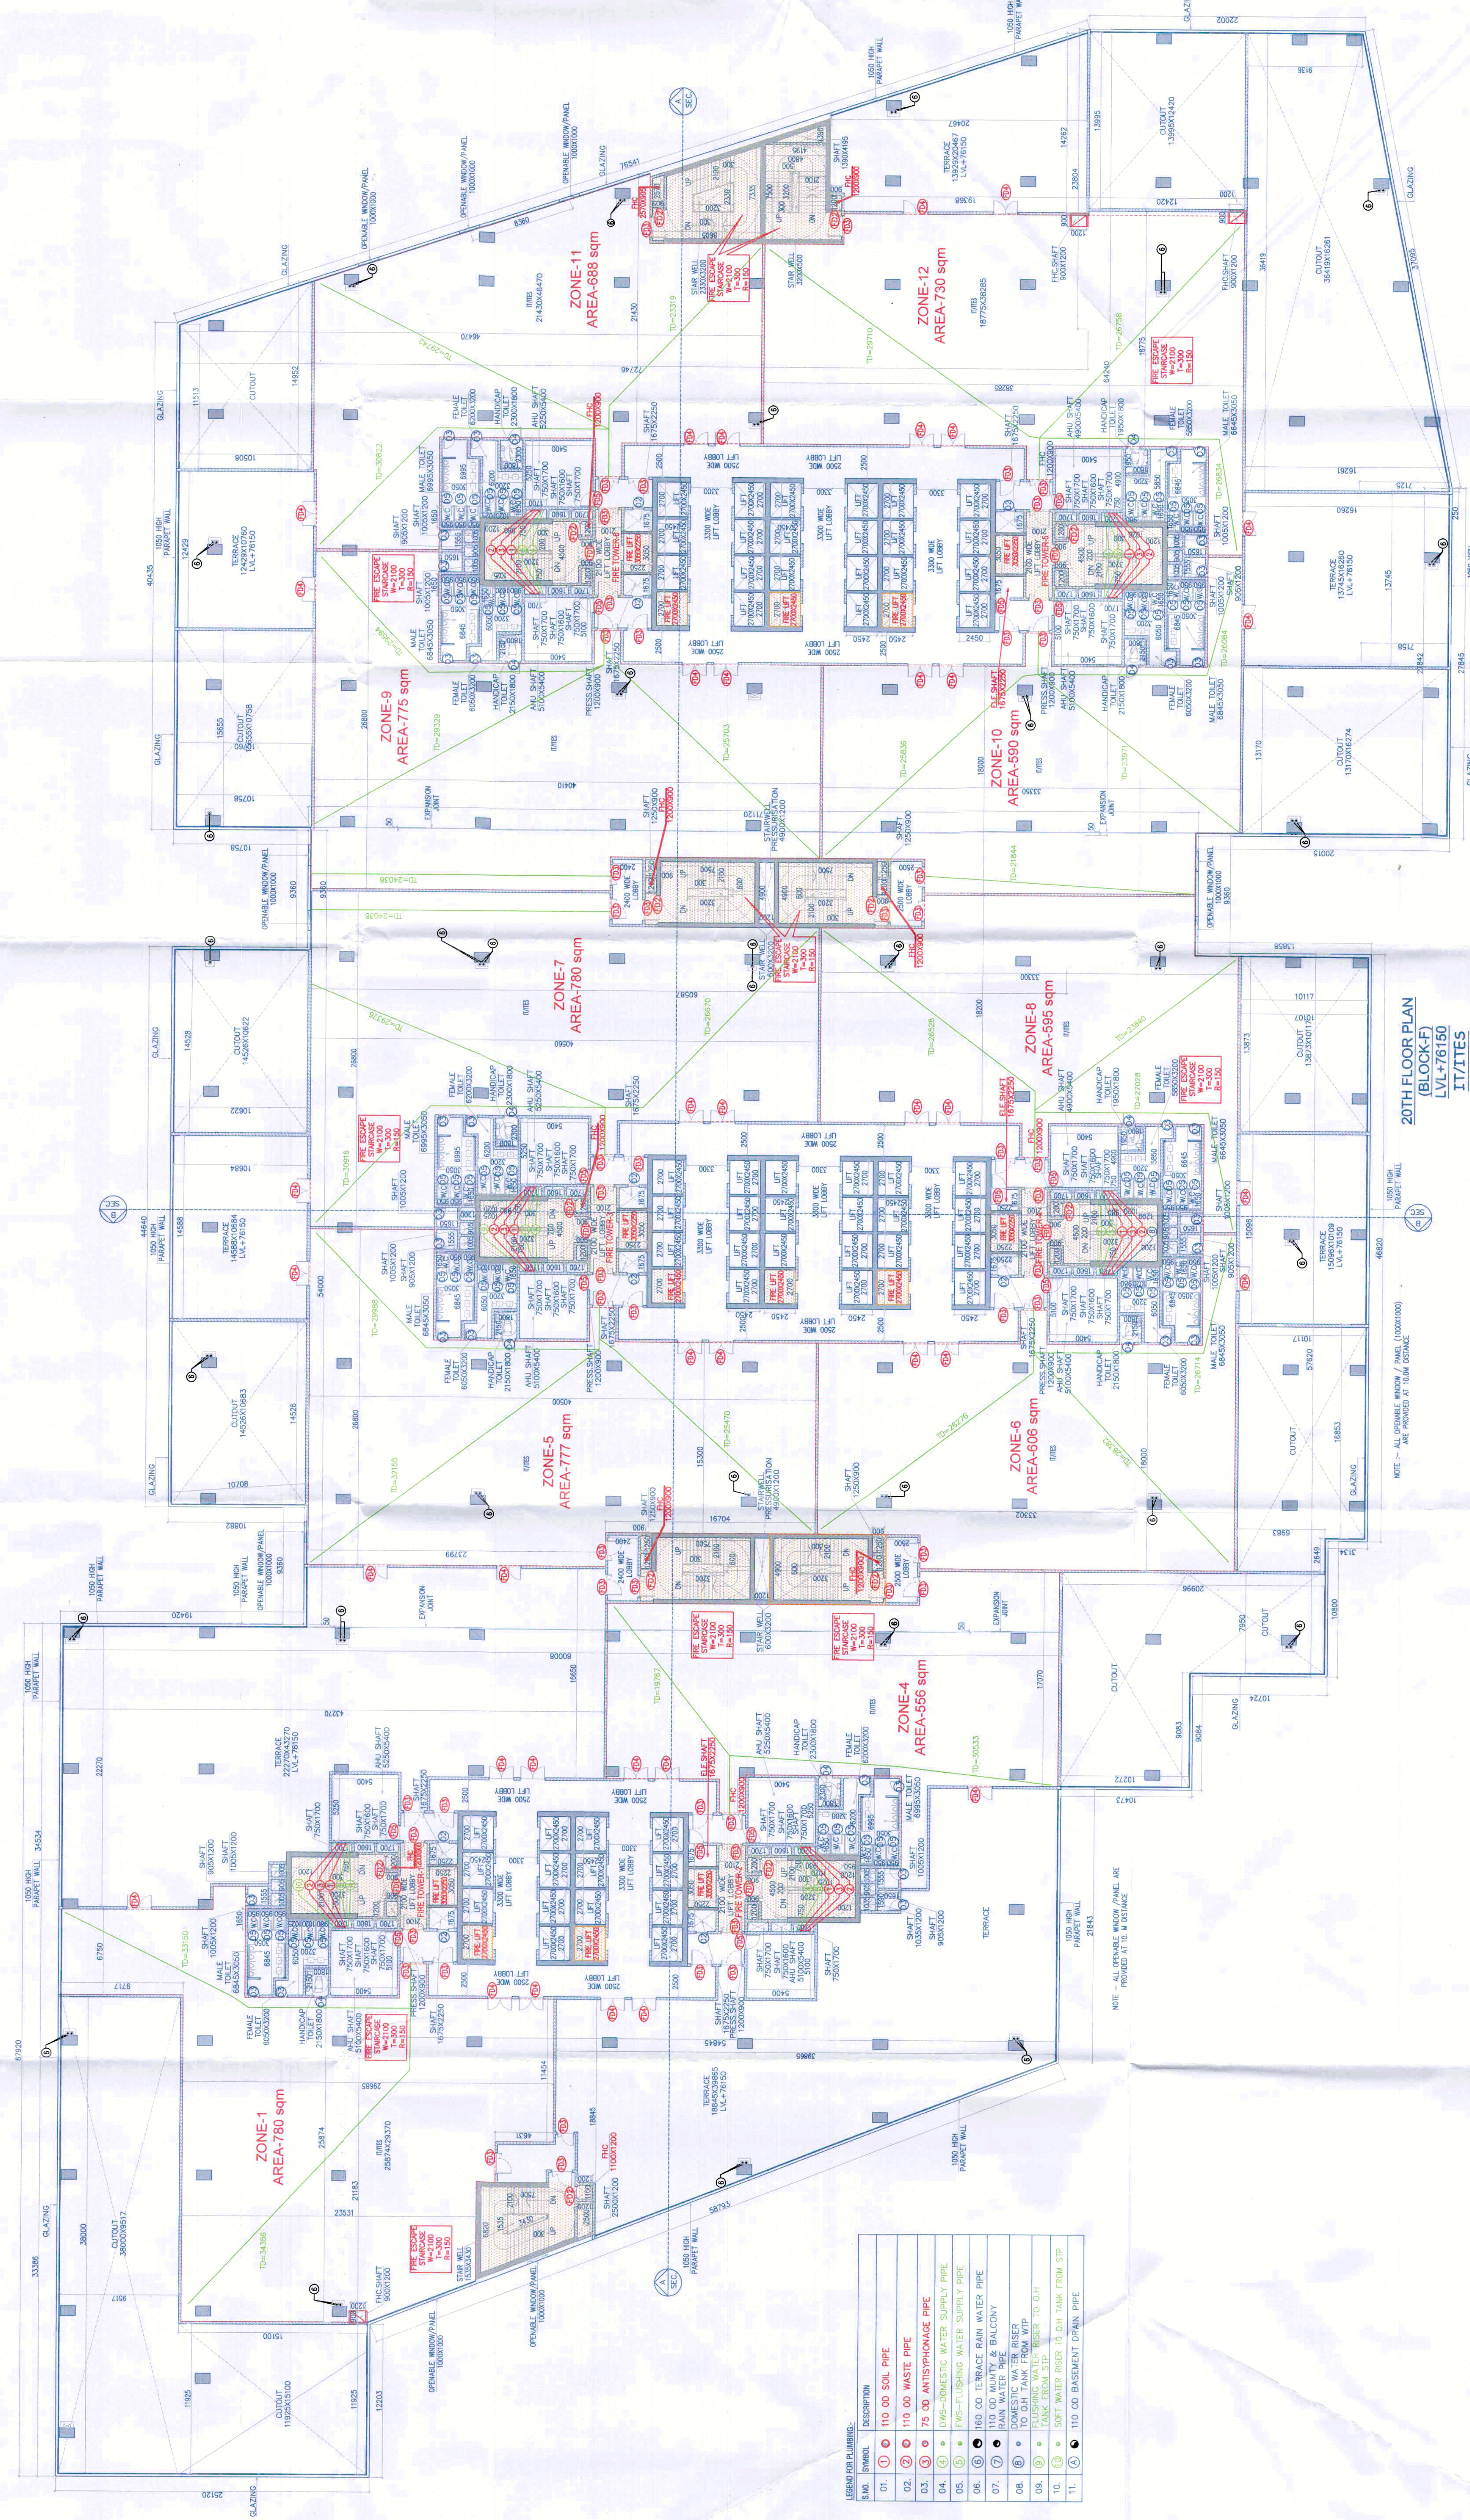

ZONE	AREA (sqm)	NO. OF ROOMS	NO. OF STAIRS	NO. OF ELEVATORS
ZONE-1	780	100	2	2
ZONE-2	780	100	2	2
ZONE-3	780	100	2	2
ZONE-4	780	100	2	2
ZONE-5	780	100	2	2
ZONE-6	780	100	2	2
ZONE-7	780	100	2	2
ZONE-8	780	100	2	2
ZONE-9	780	100	2	2
ZONE-10	780	100	2	2
ZONE-11	780	100	2	2
ZONE-12	780	100	2	2

BLOCK NAME	FLOOR	AREA (sqm)	OCCUPANT LOAD	NO. OF PERSONS	NO. OF STAIRS	NO. OF ELEVATORS	NO. OF ROOMS	NO. OF BATHS	NO. OF TOILETS	NO. OF KITCHENS	NO. OF STORES	NO. OF GARAGES	NO. OF PARKING SPACES	NO. OF CYCLING SPACES	NO. OF OTHER SPACES
20TH FLOOR PLAN (BLOCK-F)	20	10855.922	1 person per 10 sqm	1085	10	10	1000	100	100	100	100	100	100	100	100

SYMBOL	DESCRIPTION
01	110.00 SILE PPE
02	110.00 WASTE PIPE
03	75.00 ANTIPHONAGE PIPE
04	110.00 DOMESTIC WATER SUPPLY PIPE
05	110.00 THERMAL WATER SUPPLY PIPE
06	110.00 THERMAL WATER SUPPLY PIPE
07	110.00 THERMAL WATER SUPPLY PIPE
08	110.00 THERMAL WATER SUPPLY PIPE
09	110.00 THERMAL WATER SUPPLY PIPE
10	110.00 THERMAL WATER SUPPLY PIPE
11	110.00 THERMAL WATER SUPPLY PIPE