


This is a PROFESSIONAL BUILDING PLAN prepared and submitted for the purpose of making objections from the general public.

**Architect**  
Hafeez Contractor  
27 Park Street, Boreilly, New Delhi-110028

**Contractor**  
RMS ARCHITECTS PVT. LTD.  
69, Nara Niwas, Bhawani Kunj (Behind D2), Vasant Kunj, New Delhi-110070.  
Tel: 011-26898616, 26898617  
www.rms-arch.com

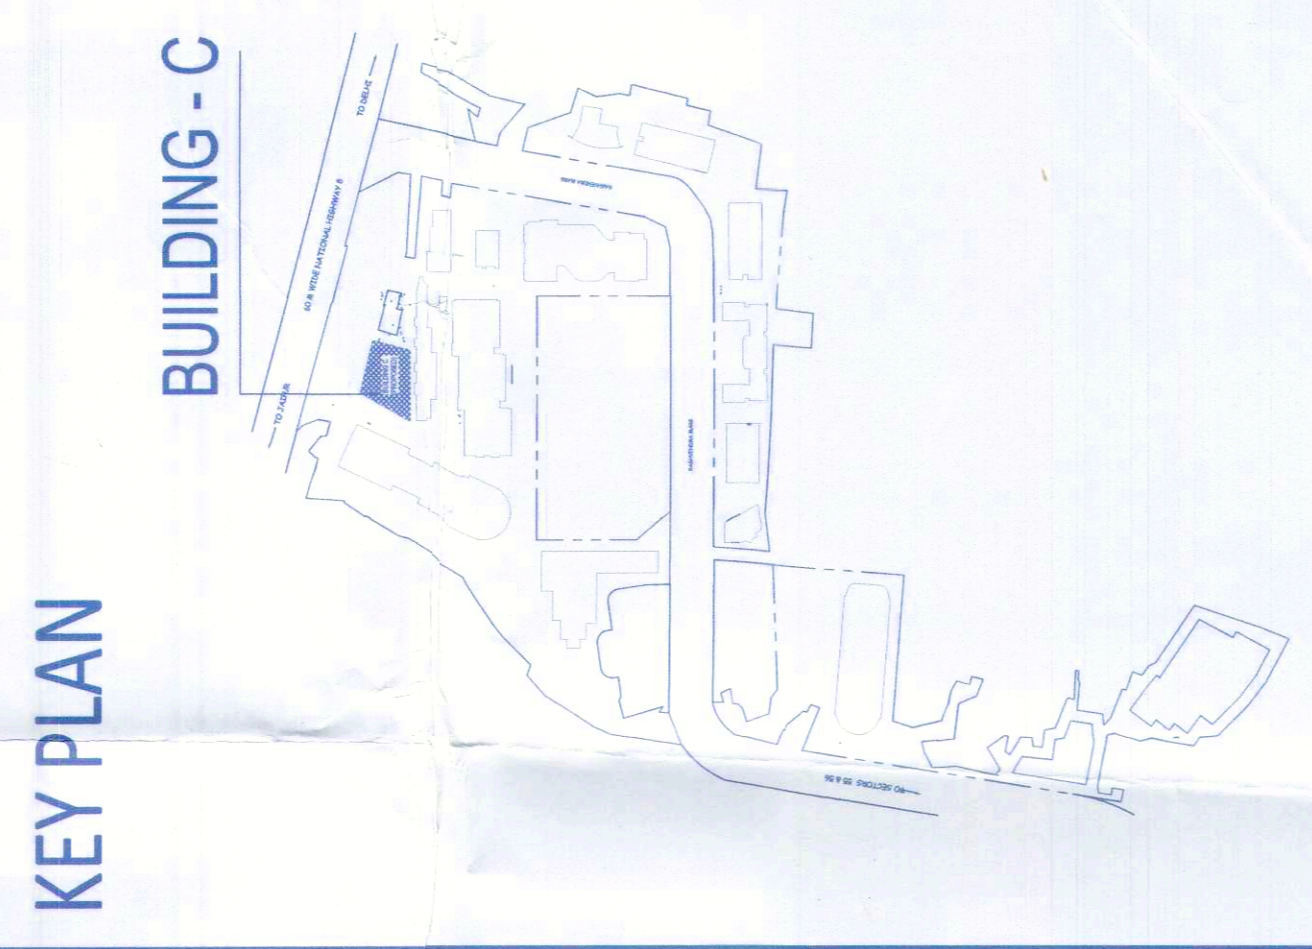

**Architect**  
Hafeez Contractor  
27 Park Street, Boreilly, New Delhi-110028

**RMS ARCHITECTS**


RMS ARCHITECTS PVT. LTD.  
69, Nara Niwas, Bhawani Kunj (Behind D2), Vasant Kunj, New Delhi-110070.  
Tel: 011-26898616, 26898617  
www.rms-arch.com

PROPOSED BUILDING PLANS OF BUILDING - B AND REVISED BUILDING PLANS OF BUILDING - C, D, E, & F IN CYBER CITY UNDER TRANSIT ORIENTED DEVELOPMENT (TOD) POLICY FOR MIX LAND USED COLONY (70% IT/ITES / 4-10% COMMERCIAL) MEASURING 108.55922 ACRES IN SECTOR 24, 25 & 25-A, CURBGRAM, MANESAR, URBAN DLF CYBER CITY DEVELOPERS LIMITED

**OWNER:** DLF Cyber City Developers Ltd.  
10th Floor DLF Gateway Tower,  
DLF Cyber City, Gurugram, Haryana  
Pin: 122002


**DRAWING TITLE:** L.M.R. FLOOR & ROOF PLAN BLOCK-C

| REVISION | JOB NO. -  | DRG NO. - | DATE -     | CHECKED BY:                  | APPROVED BY:             |
|----------|------------|-----------|------------|------------------------------|--------------------------|
|          | SCALE -    | 1:100     | 01-04-2021 |                              |                          |
| FILE -   | DEALT BY - |           |            | ARCHITECT'S SEAL & SIGNATURE | OWNER'S SEAL & SIGNATURE |

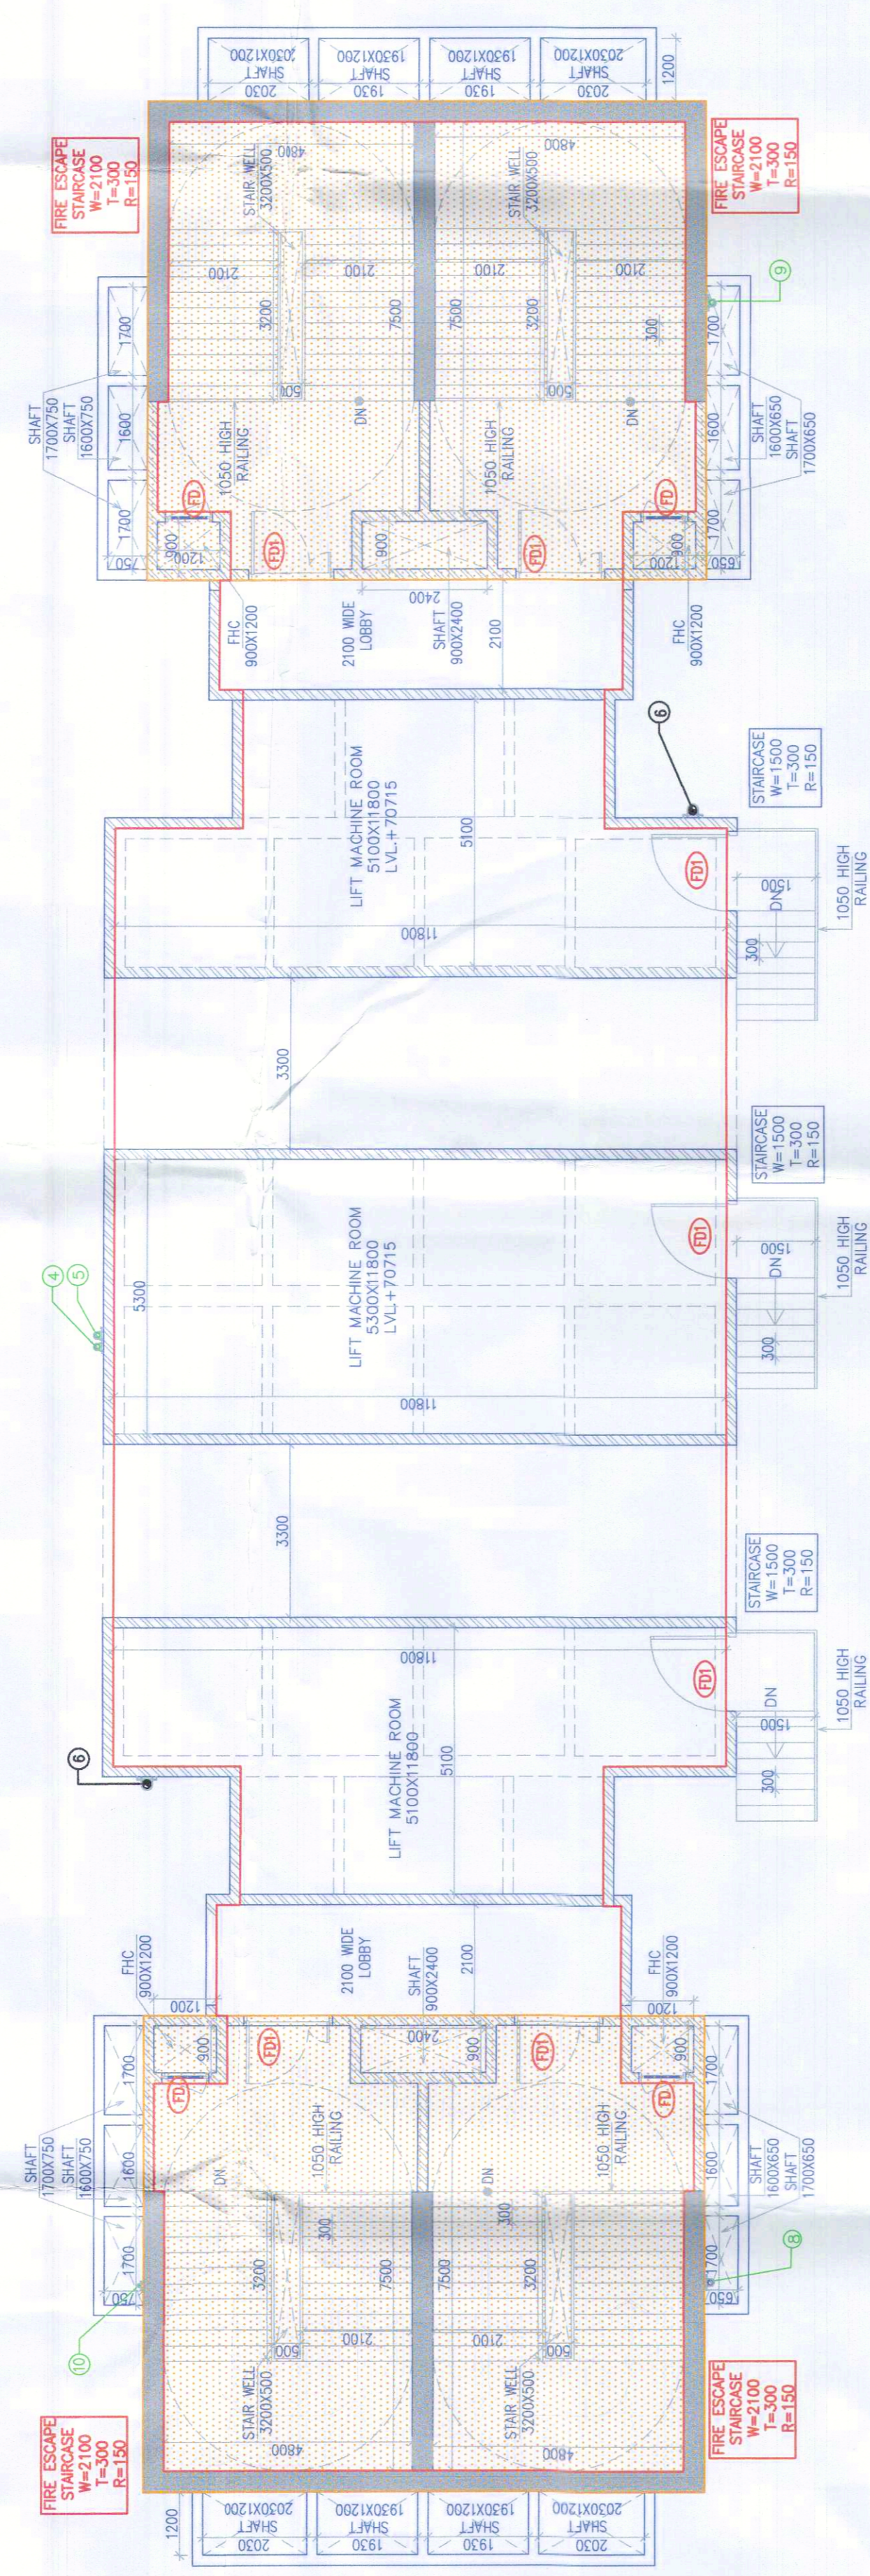

L.M.R. PLAN  
LM+70715  
(BLOCK-C)

| S.NO. | SYMBOL | DESCRIPTION  |
|-------|--------|--|
| 01.   | ①      | 110 Ø3 SOIL PIPE   |
| 02.   | ②      | 110 Ø0 WASTE PIPE  |
| 03.   | ③      | 75 Ø0 INTERFERENCE PIPE  |
| 04.   | ④      | Ø150 DOMESTIC WATER SUPPLY PIPE                                    |
| 05.   | ⑤      | Ø150 FLUSHING WATER SUPPLY PIPE                                    |
| 06.   | ⑥      | Ø150 Ø0 TERRACE RAIN WATER PIPE                                    |
| 07.   | ⑦      | Ø150 Ø0 W.M.P. & BALCONY RAIN WATER PIPE                           |
| 08.   | ⑧      | Ø150 Ø0 DOMESTIC WATER RISER TO O.H. TANK FROM W.P. TANK FROM STD. |
| 09.   | ⑨      | Ø150 Ø0 DOMESTIC WATER RISER TO O.H. TANK FROM STD.                |
| 10.   | ⑩      | Ø150 Ø0 RISER TO O.H. TANK FROM STD.                               |
| 11.   | ⑪      | Ø150 Ø0 RISER TO O.H. TANK FROM STD.                               |
| 12.   | ⑫      | FLOOR DRAIN  |
| 13.   | ⑬      | FLOOR TRAP   |
| 14.   | ⑭      | URINAL TRAP  |
| 15.   | ⑮      | FLOOR CLEAN OUT  |
| 16.   | ⑯      | WASTE PIPE   |
| 17.   | ⑰      | WASHING WATER SUPPLY (GRAVITY SUPPLY)                              |
| 18.   | ⑱      | DOMESTIC WATER SUPPLY (GRAVITY SUPPLY)                             |

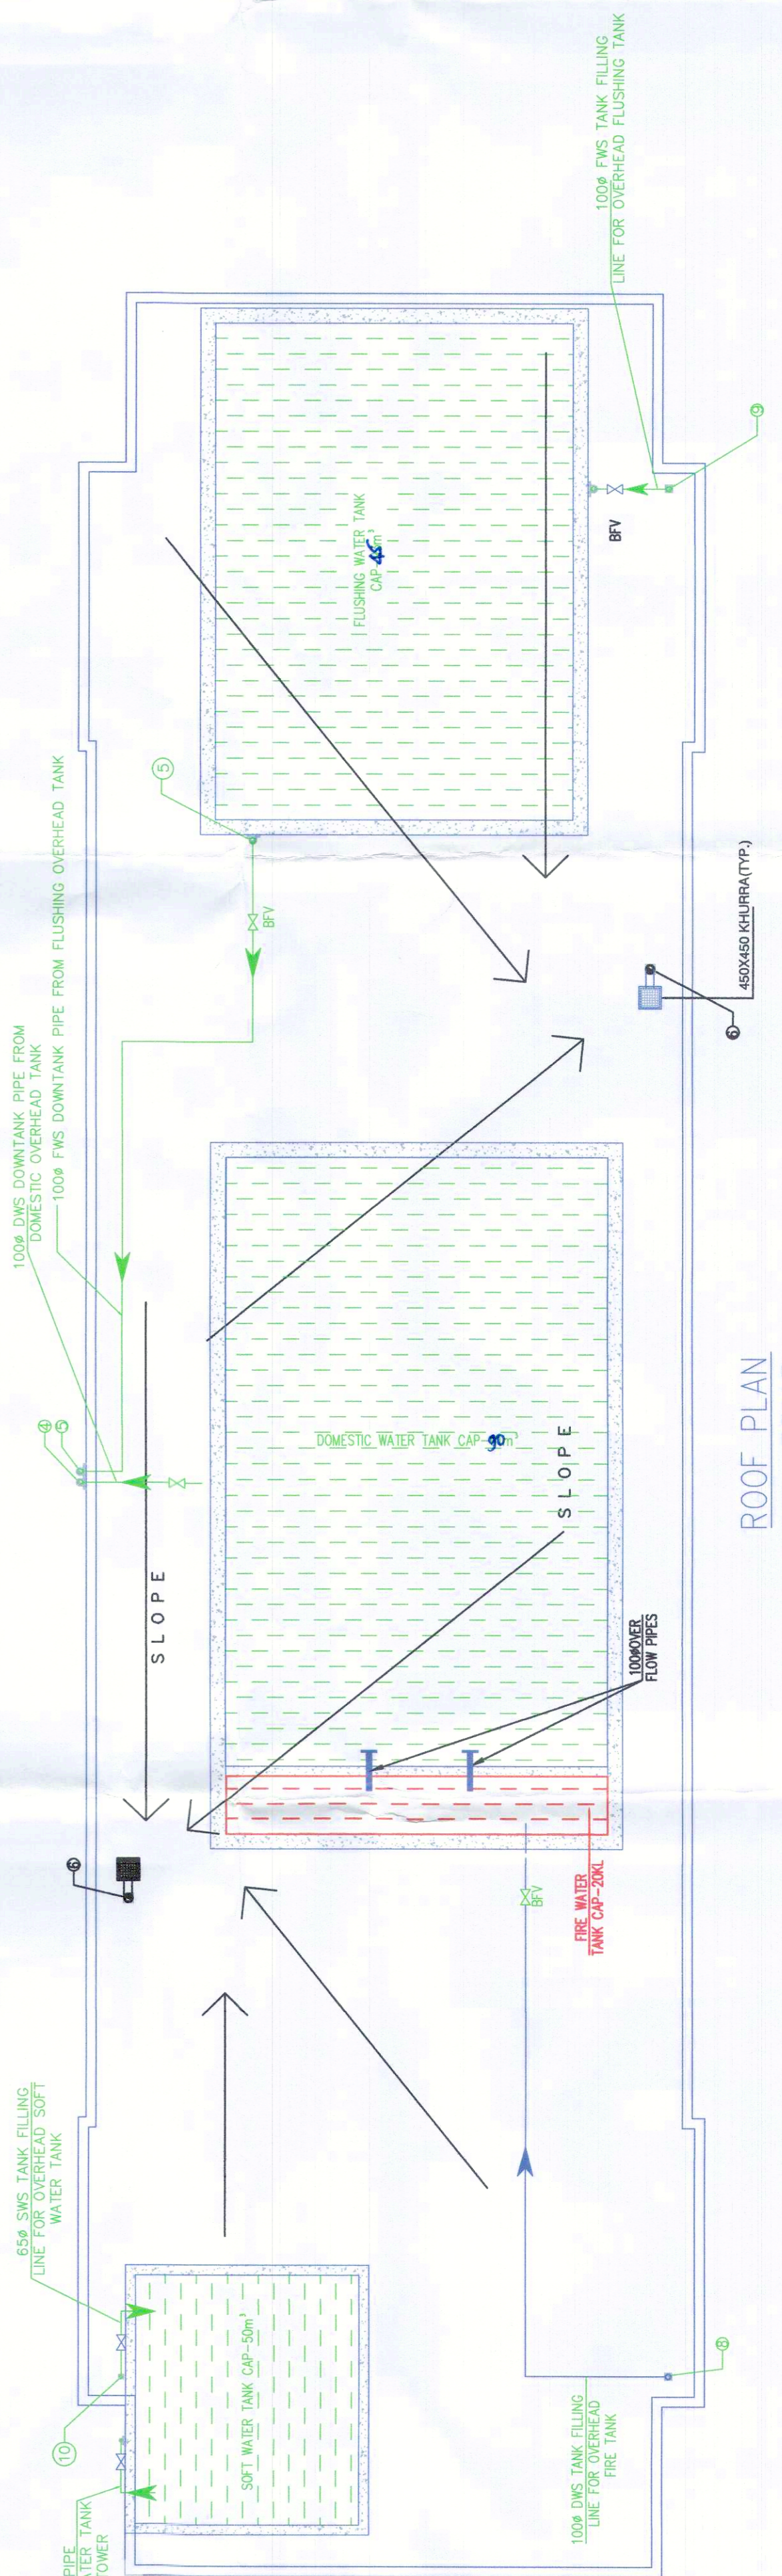

ROOF PLAN  
LM+73115  
(BLOCK-C)