


THIS IS A PROVISIONAL BUILDING PLAN approved only for the purpose of inviting objections from the general public.

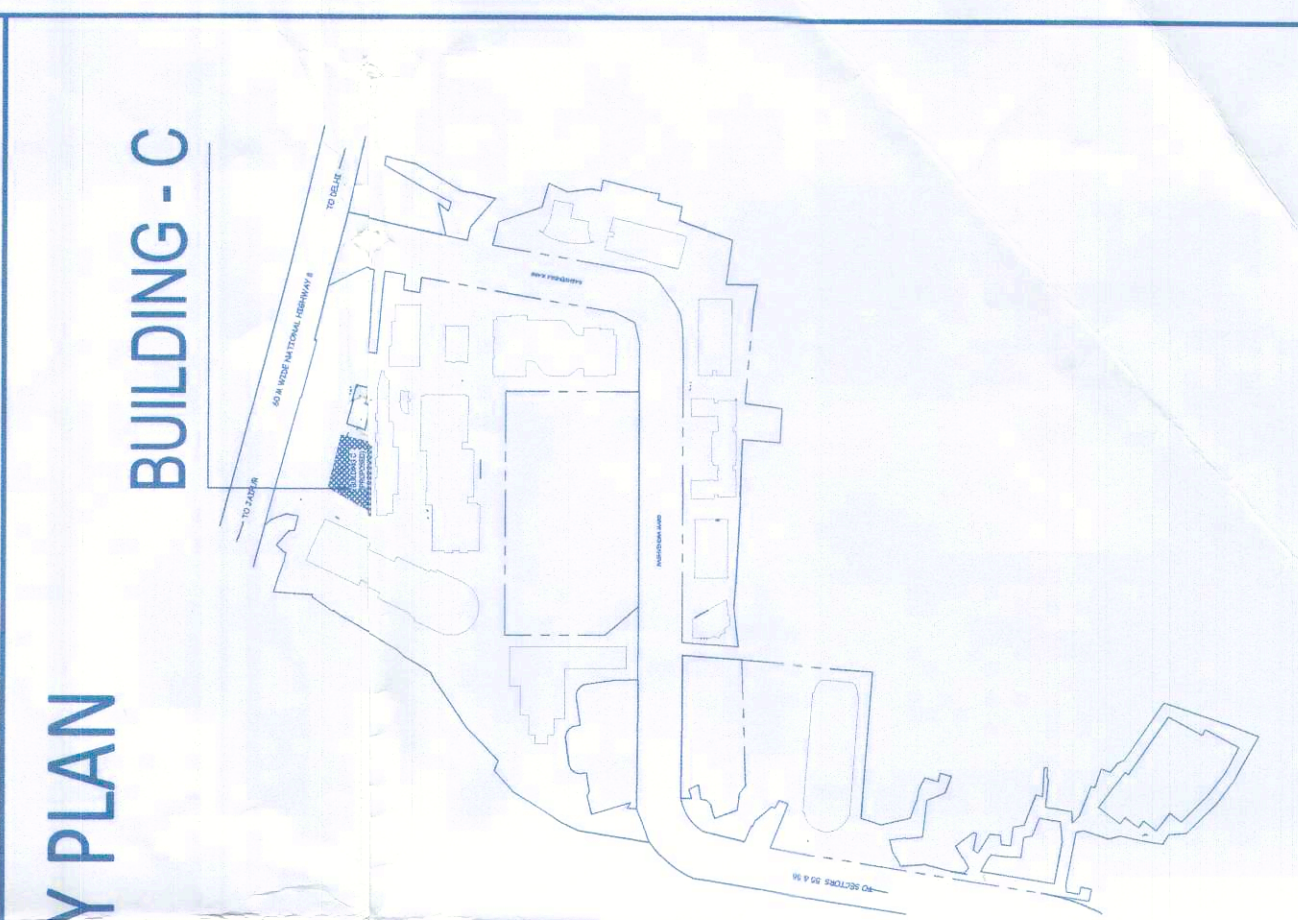

Architect
Hafeez Contractor
 29, Bank Street, Boney 401, N-8649380

RISIMIS ARCHITECTS
 RMS ARCHITECTS PVT. LTD.
 69, Nara Niwas, Bhawani Kunj (Behind D2), Vasant Kunj, New Delhi-110070.
 Tel: 011-26898616, 26898617
 www.rsimis-arch.com

PROPOSED BUILDING PLANS OF BUILDING - B AND REVISED BUILDING PLANS OF BUILDING - C, D, E, & F IN CYBER CITY UNDER TRANSIT ORIENTED DEVELOPMENT (TOD) POLICY FOR MIX LAND USE COLONY (70% IT/IES + 30% COMMERCIAL) MEASURING 108.55922 ACRES IN SECTOR 24, 25 & 25-A, GURUGRAM, MANESAR, URBAN, DLF, CYBER CITY DEVELOPERS LIMITED


OWNER: DLF Cyber City Developers Ltd.
 10th Floor DLF Gateway Tower,
 DLF Cyber City, Gurugram, Haryana
 Pin: 122002

DRAWING TITLE: 5th FLOOR PLAN (BLOCK-C)

REVISION	JOB NO. -	DRG. NO. -	NORTH -
	SCALE: 1:100	BC-03A	
FILE -	DATE: 01-04-2021		
	CHECKED BY: -		
	DEALT BY: -		
	APPROVED BY: -		
	ARCHITECT'S SEAL & SIGNATURE		
	OWNER'S SEAL & SIGNATURE		

LEGEND:

SYMBOL	DESCRIPTION
01. 110 OD SOL PIPE	110 OD SOL PIPE
02. 110 OD WASTE PIPE	110 OD WASTE PIPE
03. 75 OD ANTISEPTIC PIPE	75 OD ANTISEPTIC PIPE
04. 110 DOMESTIC WATER SUPPLY PIPE	110 DOMESTIC WATER SUPPLY PIPE
05. 110 FLUSHING WATER SUPPLY PIPE	110 FLUSHING WATER SUPPLY PIPE
06. 110 OD TERRACE RAIN WATER PIPE	110 OD TERRACE RAIN WATER PIPE
07. 110 OD MURTY & BALCONY RAIN WATER PIPE	110 OD MURTY & BALCONY RAIN WATER PIPE
08. DOMESTIC WATER RISER TO O.H. TANK FROM W.P. TANK FROM STP	DOMESTIC WATER RISER TO O.H. TANK FROM W.P. TANK FROM STP
09. SOFT WATER RISER TO O.H. TANK FROM STP	SOFT WATER RISER TO O.H. TANK FROM STP
10. 110 OD BASEMENT DRAIN PIPE	110 OD BASEMENT DRAIN PIPE
11. FLOOR DRAIN	FLOOR DRAIN
12. FLOOR TRAP	FLOOR TRAP
13. URINAL TRAP	URINAL TRAP
14. COP	FLOOR CLEAN OUT
15. SOL PIPE	SOL PIPE
16. WASTE PIPE	WASTE PIPE
17. FLUSHING WATER SUPPLY (GRAVITY SUPPLY)	FLUSHING WATER SUPPLY (GRAVITY SUPPLY)
18. DOMESTIC WATER SUPPLY (GRAVITY SUPPLY)	DOMESTIC WATER SUPPLY (GRAVITY SUPPLY)

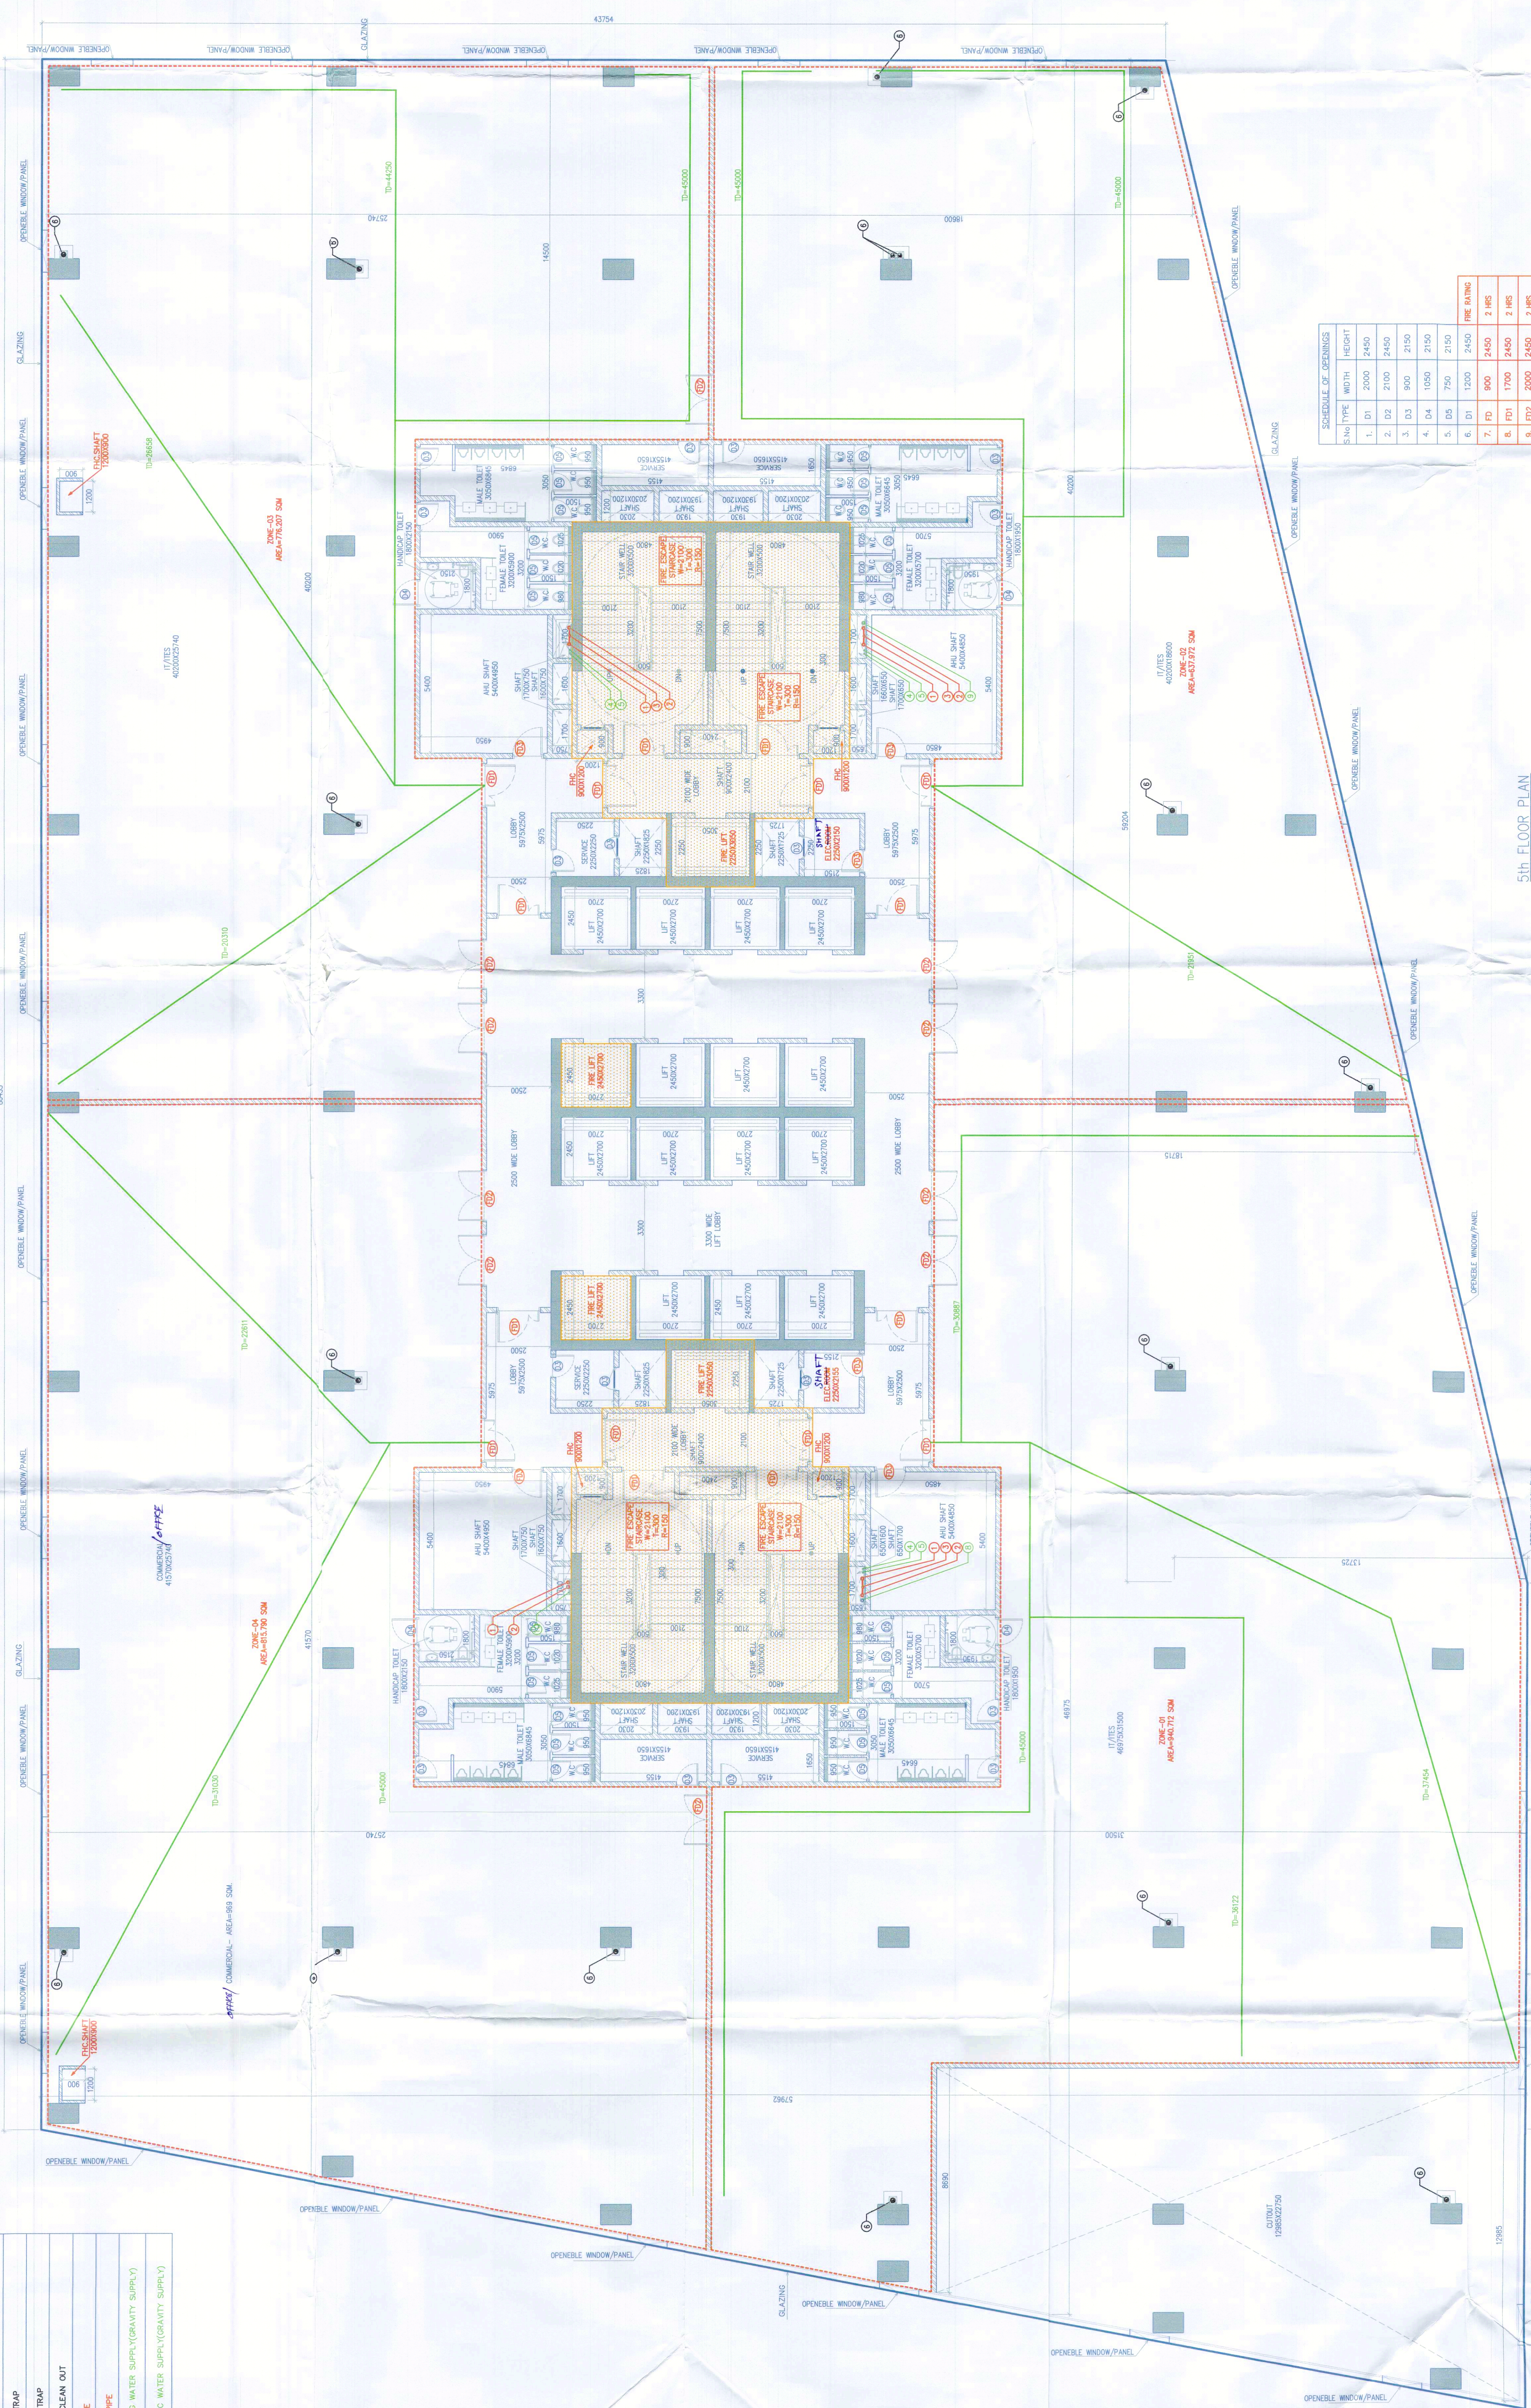

SCHEDULE OF OPENINGS

S/N	TYPE	WIDTH	HEIGHT	NO. OF OPENINGS
1.	FD	2000	2400	1
2.	FD	2100	2400	1
3.	FD	900	2100	1
4.	FD	1000	2100	1
5.	FD	700	2100	1
6.	FD	900	2400	1
7.	FD	1700	2400	1
8.	FD	2000	2400	1
9.	FD	1000	2400	1

5th FLOOR PLAN
LV-L19150
(BLOCK-C)

NOTE: ALL OPENABLE WINDOW / PANEL ARE PROVIDED AT 10M DISTANCE.