

**DRG NO. BD-01**

This is a "PROVISIONAL BUILDING PLAN" approved only for the purpose of having objections from the general public.

**Architect**  
Hafeez Contractor


**Contractor**  
RMS ARCHITECTS PVT. LTD.

**OWNER**  
DLF Cyber City Developers Ltd.  
10th Floor DLF Gateway Tower,  
DLF Cyber City, Gurugram, Haryana  
Pin: 122002

**PROJECT:**  
PROPOSED BUILDING PLANS OF BUILDING - B AND REVISED BUILDING PLANS OF BUILDING - C, D, E, & F IN CYBER CITY UNDER TRANSIT ORIENTED DEVELOPMENT (TOD) POLICY FOR MIX LAND USED COLONY 70% IT/TES (+30% COMMERCIAL) MEASURING 108.55922 ACRES IN SECTOR 24, 25 & 25-A, GURUGRAM MANESAR URBAN COMPLEX BEING DEVELOPED BY DLF CYBER CITY DEVELOPERS LIMITED

**REVISION:**  
JOB NO. - BD-01  
SCALE - 1/200  
DATE - 01-04-2021

**FILE:**  
DEALT BY: -  
CHECKED BY: -  
APPROVED BY: -  
ARCHITECT'S SEAL & SIGNATURE  
OWNER'S SEAL & SIGNATURE

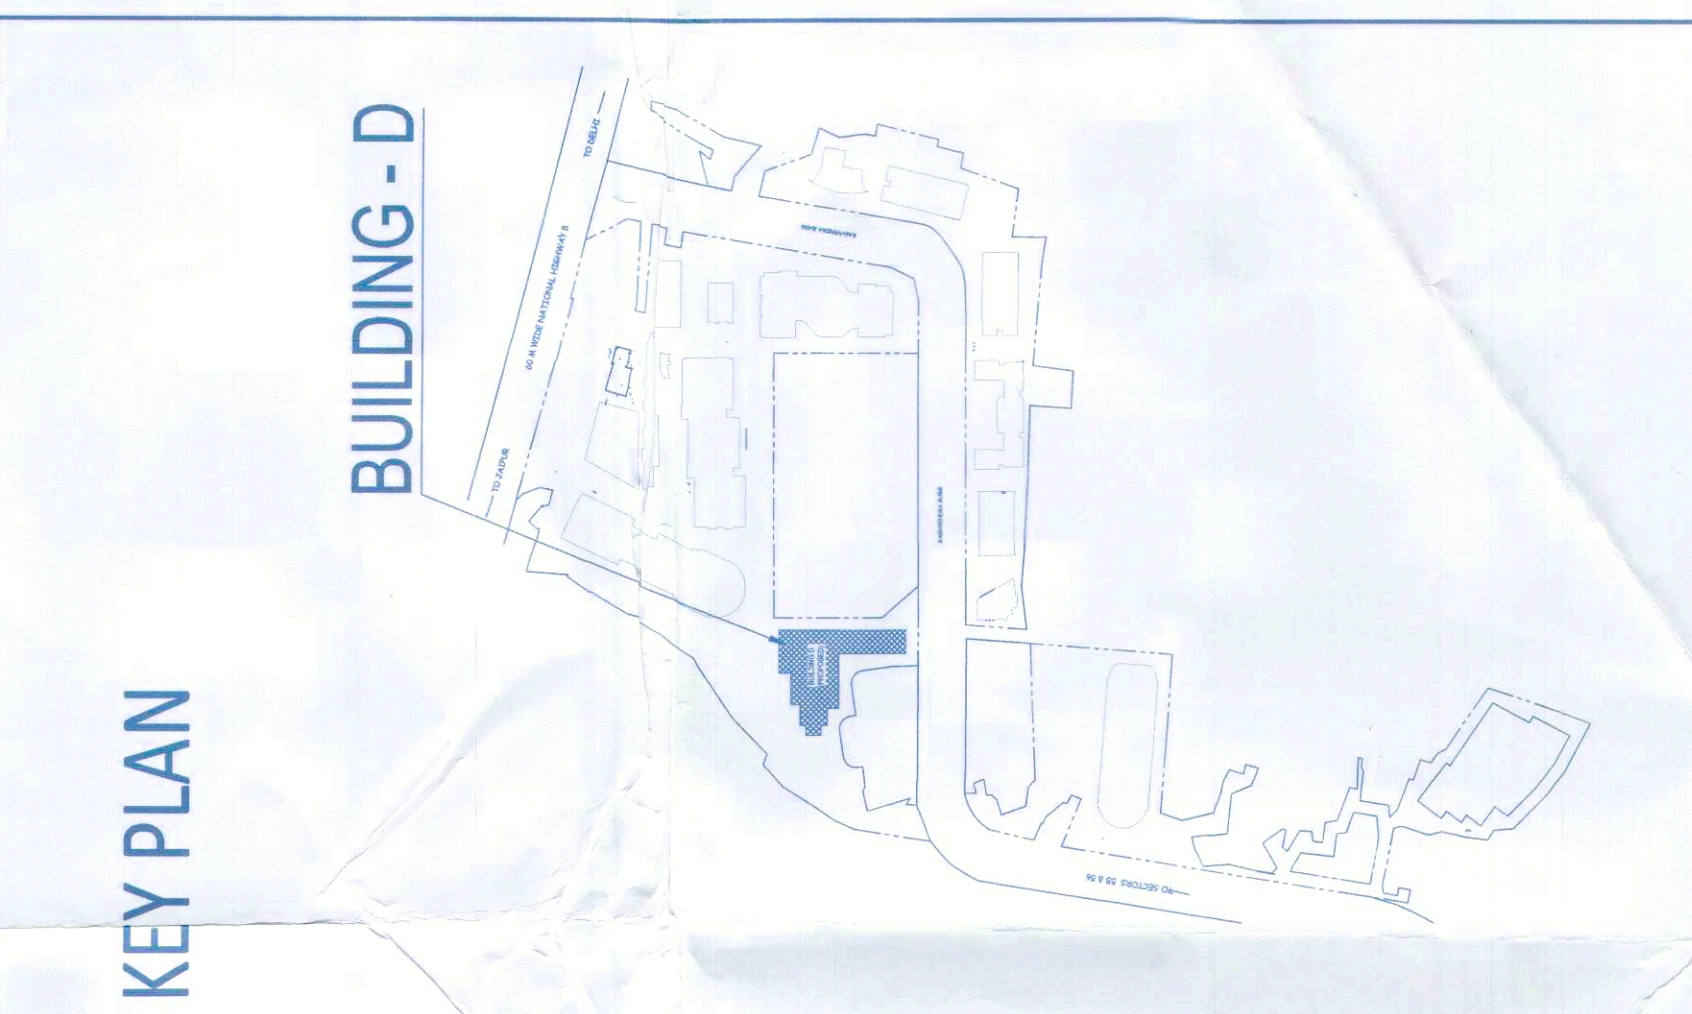


**Architect**  
Hafeez Contractor  
29 Bina Street, Borey, ARI 823, 14846938

**RISIMIS ARCHITECTS**

**RMS ARCHITECTS PVT. LTD.**  
69, Nara Niwas, Bhawani Kunj (Behind D2), Vasant Kunj, New Delhi - 110070  
Tel: 011-26888616, 26888617  
www.rms-arch.com

**OWNER:**  
DLF Cyber City Developers Ltd.  
10th Floor DLF Gateway Tower,  
DLF Cyber City, Gurugram, Haryana  
Pin: 122002

**DRAWING TITLE:**  
GROUND FLOOR PLAN BLOCK-D

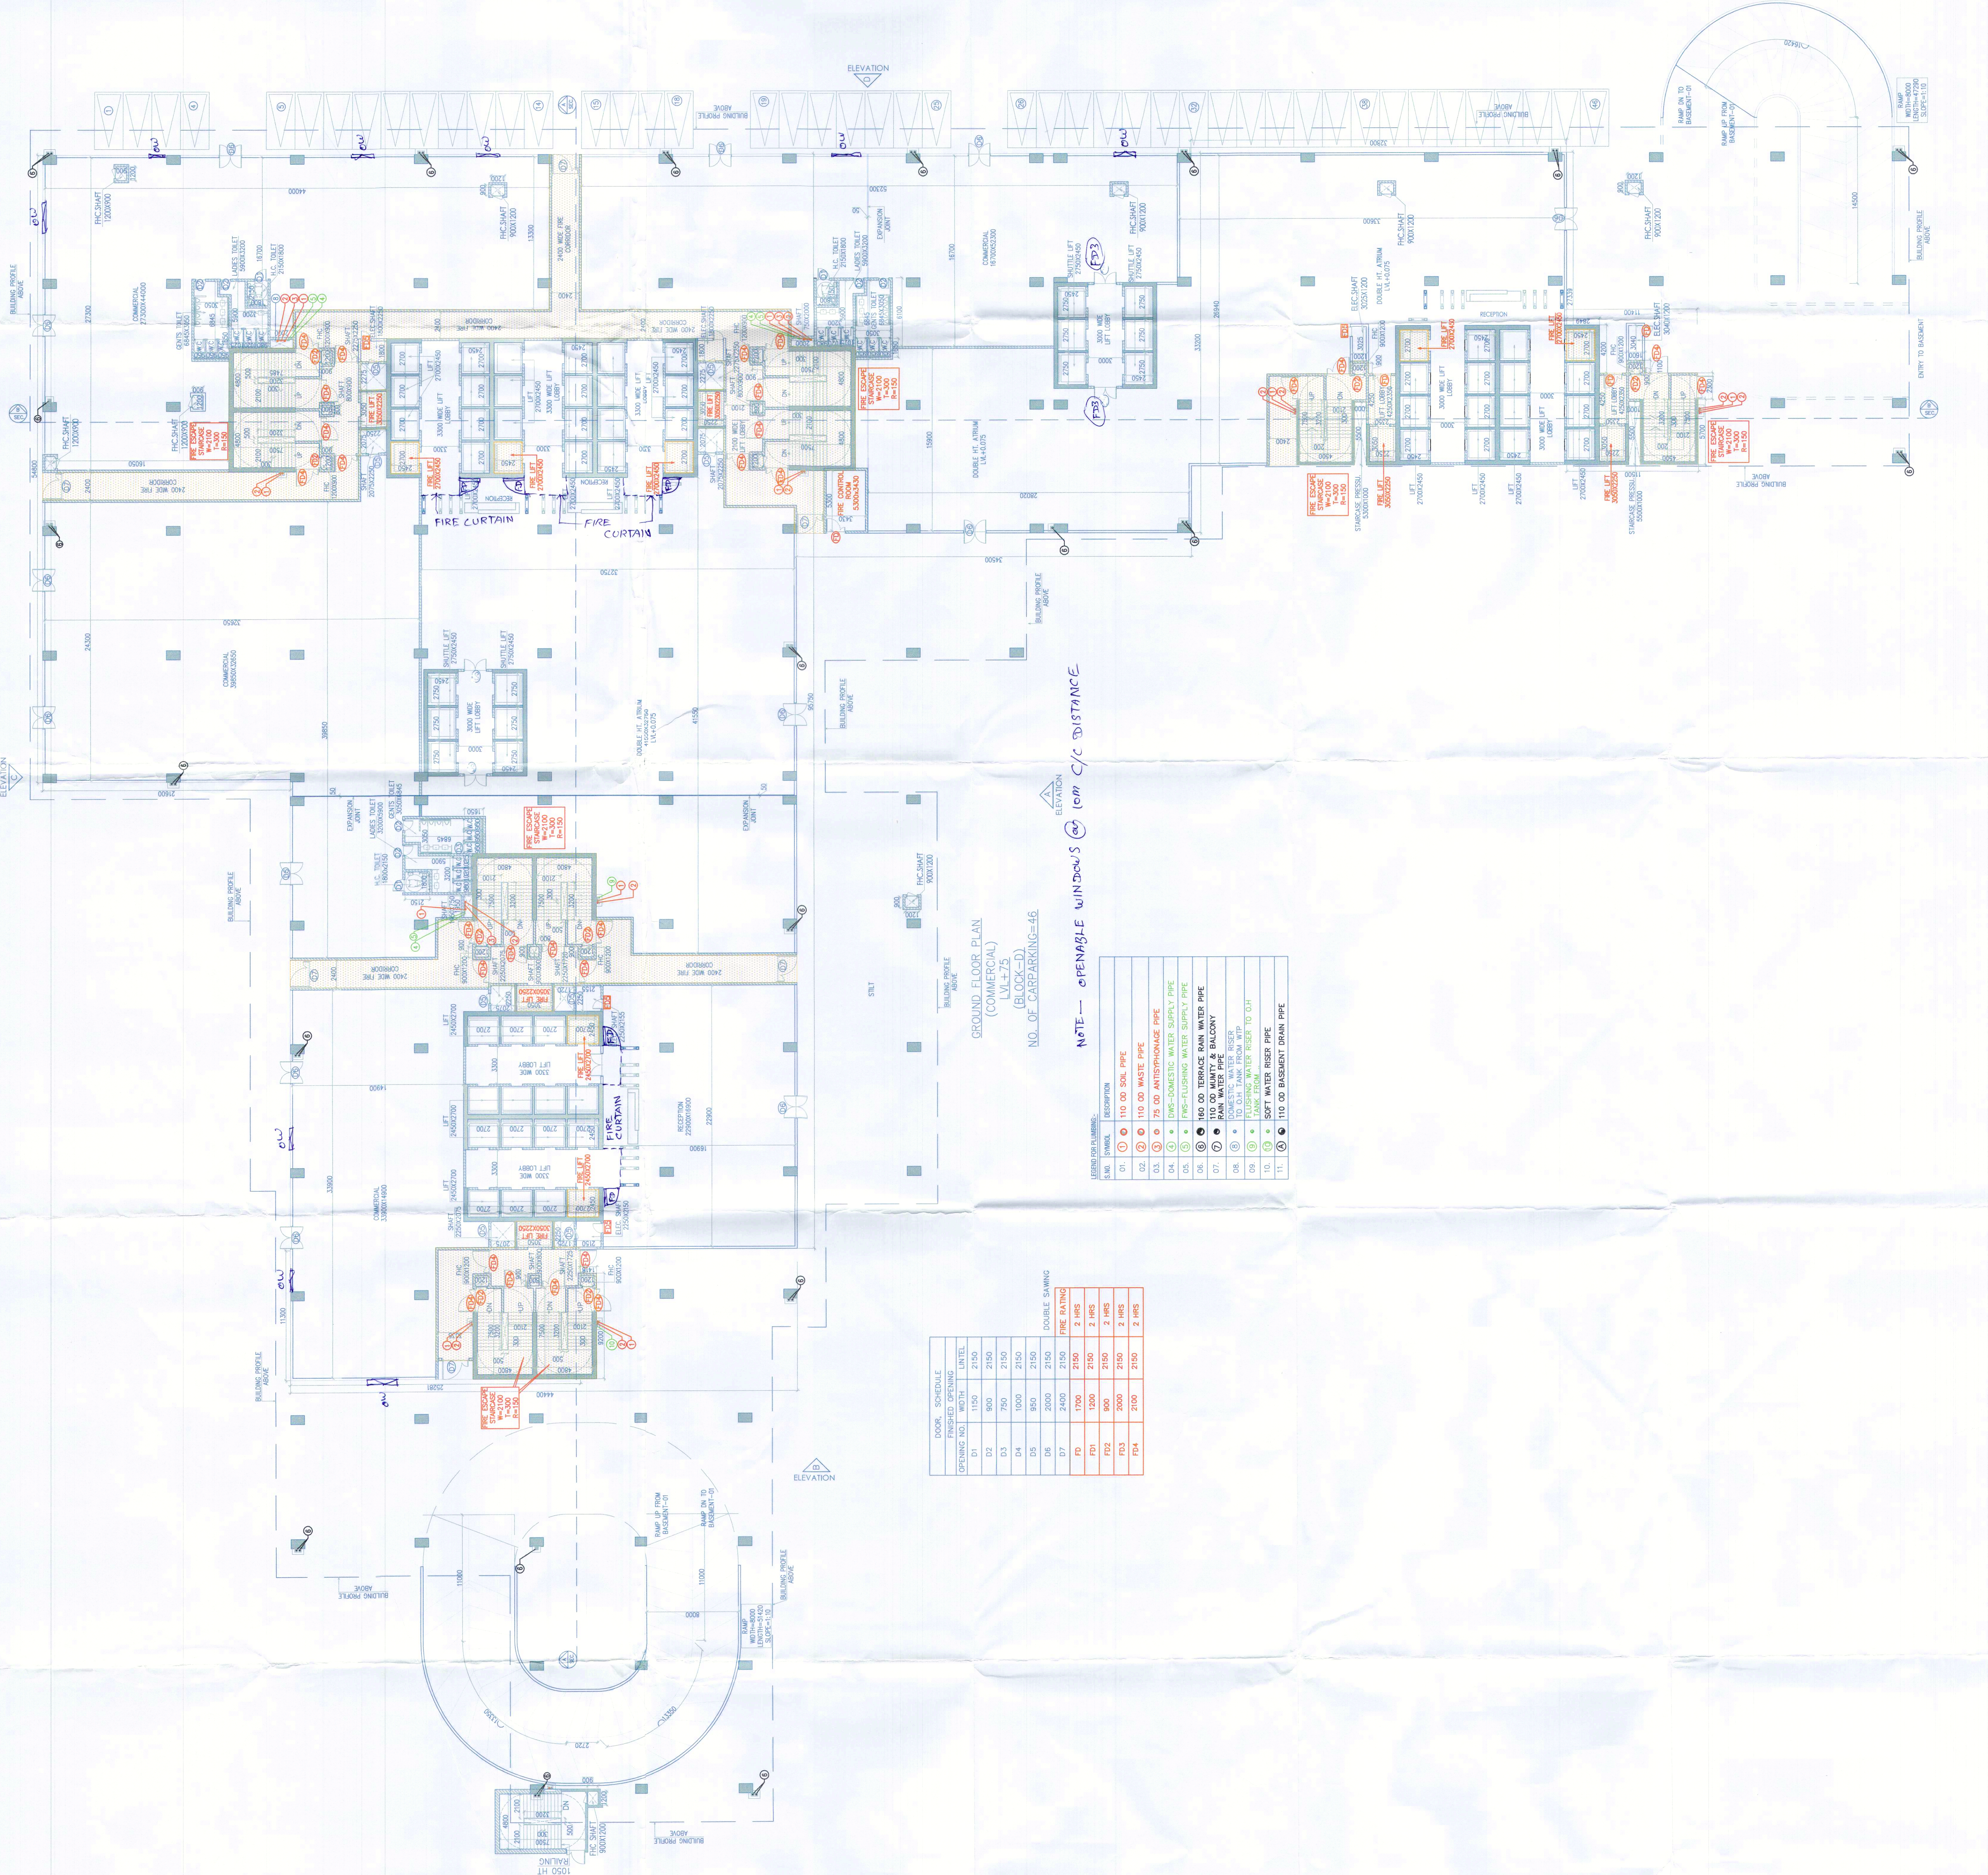

**DOOR, SCHEDULE**

DOOR	SCHEDULE	UNIT
D1	1150	2150
D2	900	2150
D3	750	2150
D4	1000	2150
D5	950	2150
D6	2000	2150
D7	2400	2150
D8	1700	2150
D9	900	2150
D10	1000	2150
D11	900	2150
D12	2100	2150
D13	2100	2150
D14	2100	2150

**GROUND FLOOR PLAN (COMMERCIAL) (BLOCK-D) (L1+25)**  
NO. OF CARPARKING=46

**NOTE - OPENABLE WINDOWS @ 6m C/C DISTANCE**

**LEGEND FOR SYMBOLS:**

SYMBOL	DESCRIPTION
01	110.00 SOIL PIPE
02	110.00 WASTE PIPE
03	75.00 ANTI-SIPHONAGE PIPE
04	DWS-DOMESTIC WATER SUPPLY PIPE
05	FWS-FRESHWATER WATER SUPPLY PIPE
06	110.00 TERRACE RAIN WATER PIPE
07	RAIN WATER PIPE BALCONY
08	10.00 TANK TRUNK W/P
09	10.00 TANK TRUNK W/P
10	110.00 WATER RISE PIPE TO G/F
11	110.00 BASEMENT DRAIN PIPE

