


This is a PROVISIONAL BUILDING PLAN approved only for the purpose of inviting objections from the general public.

[Signatures and stamps]

Room No. (Block) ADP(03)

Scale: 1:200

DATE: 01-04-2021

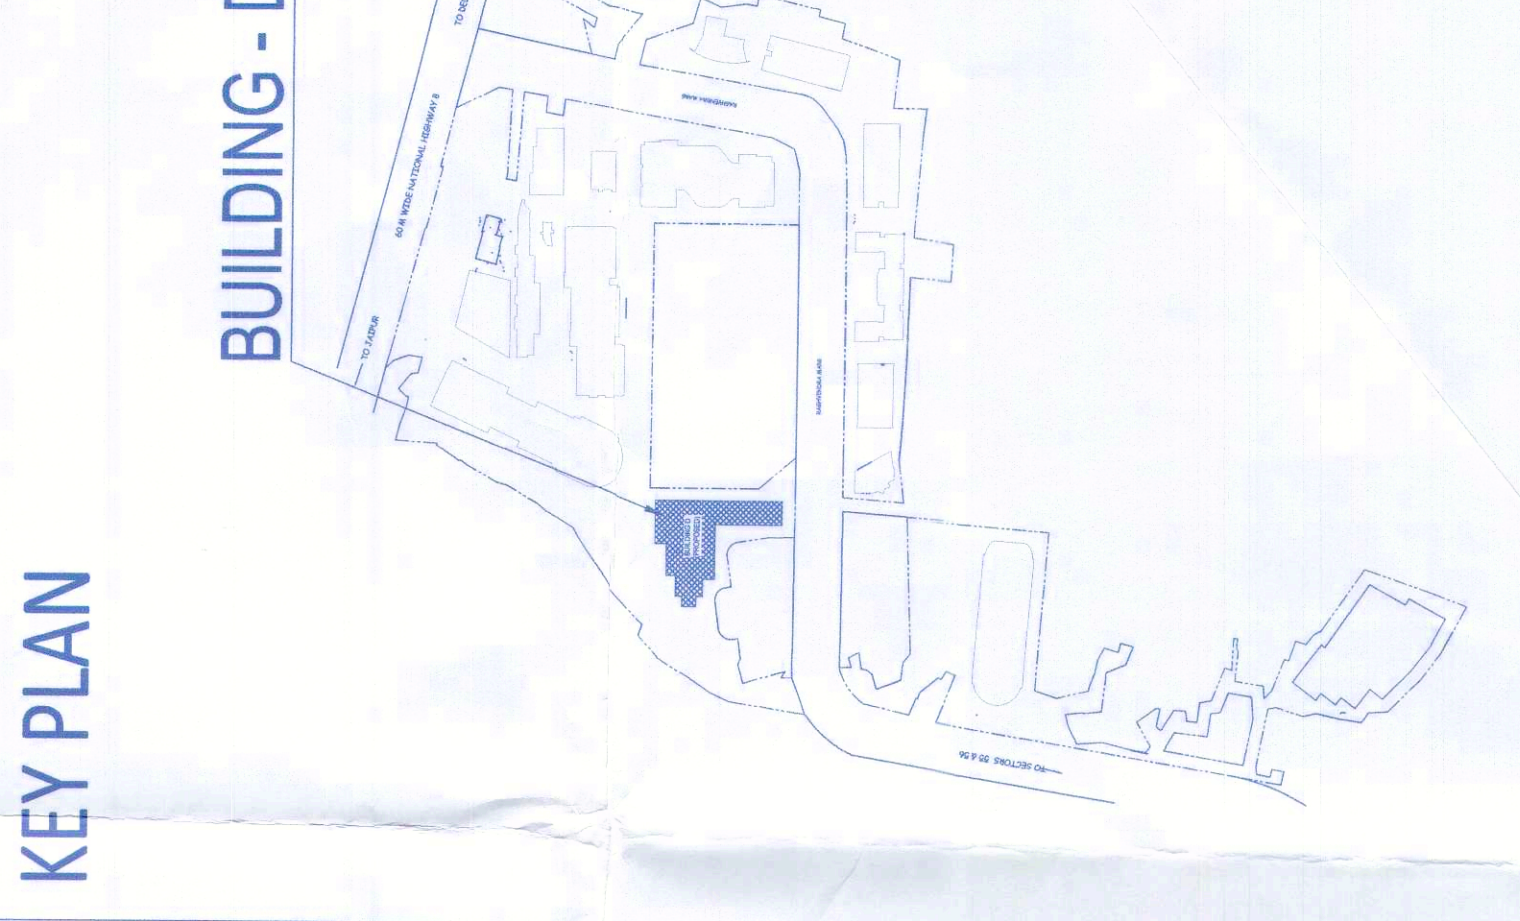

Architect
Hafeez

Contractor
RISIMIS ARCHITECTS


RSMS ARCHITECTS PVT. LTD.
69, Nara Niwas (Bhawani Kunj)
(Behind D2), Vasant Kunj,
New Delhi-110070.
Tel: 011-26889616, 26889617
www.rsms-arch.com

PROPOSED BUILDING PLANS OF BUILDING - B AND REVISED BUILDING PLANS OF BUILDING - C, D, E, & F IN CYBER CITY UNDER TRANSIT ORIENTED DEVELOPMENT (TOD) POLICY FOR MIX LAND USED COLONY (70% IT/ITES + 30% COMMERCIAL) MEASURING 108.55922 ACRES IN SECTOR 24, 25 & 25-A, GURUGRAM MANESAR URBAN PLAN COMPLEX BEING DEVELOPED BY DLF CYBER CITY DEVELOPERS LIMITED

OWNER: DLF Cyber City Developers Ltd.
10th Floor DLF Gateway Tower,
DLF Cyber City, Gurugram, Haryana
Pin: 122002

DRAWING TITLE: TYPICAL (D) TO FTL - 8TH TO 10TH FLOOR PLAN (BLOCK-D)

REVISION	JOB NO. -	DRG NO. -	NORTH -
		BD-03	
FILE	DEALT BY -	DATE -	APPROVED BY -
		01-04-2021	OWNER'S SEAL & SIGNATURE

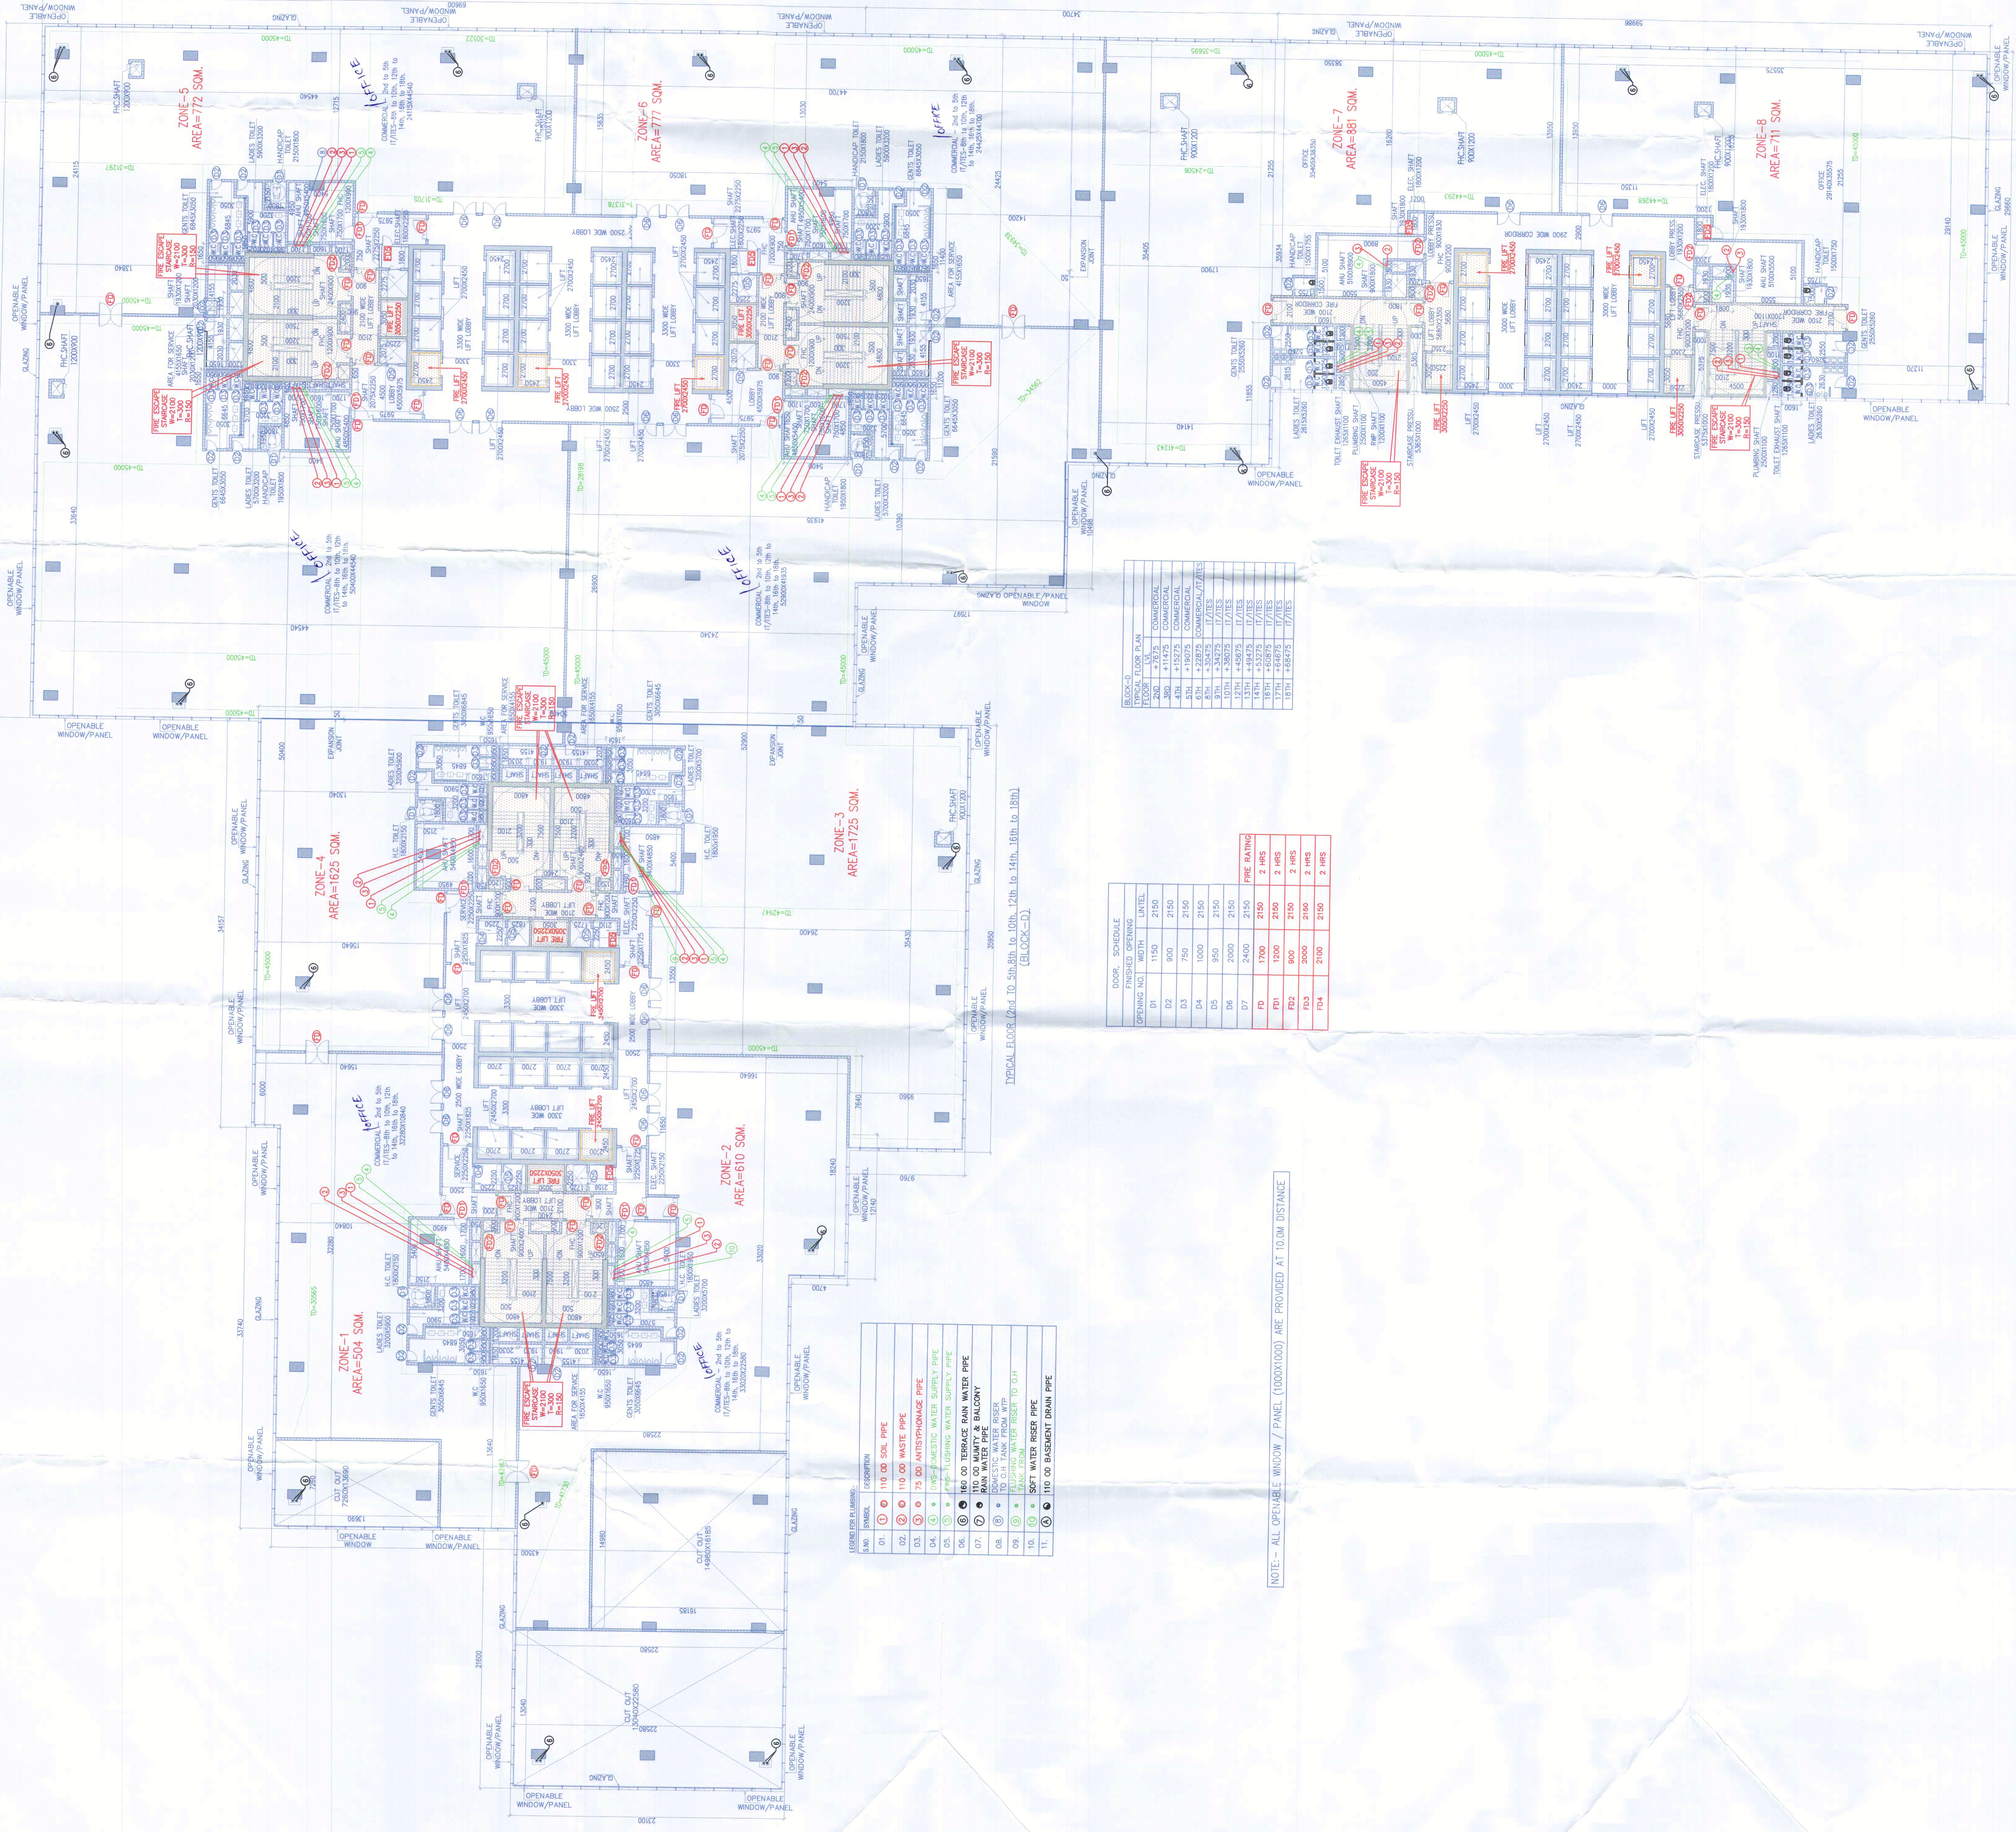

DOOR SCHEDULE

DOOR NO.	SCHEDULE	LEVEL
01	110 00 WASTE PIPE	2150
02	110 00 WASTE PIPE	2150
03	75 00 ANTI-SIPHONAGE PIPE	2150
04	75 00 ANTI-SIPHONAGE PIPE	2150
05	160 00 TERRACE RAIN WATER PIPE	2150
06	160 00 TERRACE RAIN WATER PIPE	2150
07	160 00 TERRACE RAIN WATER PIPE	2150
08	160 00 TERRACE RAIN WATER PIPE	2150
09	160 00 TERRACE RAIN WATER PIPE	2150
10	160 00 TERRACE RAIN WATER PIPE	2150
11	110 00 BASEMENT DRAIN PIPE	2150

- LEGEND FOR SYMBOLS:
- 01. 110 00 WASTE PIPE
 - 02. 110 00 WASTE PIPE
 - 03. 75 00 ANTI-SIPHONAGE PIPE
 - 04. 75 00 ANTI-SIPHONAGE PIPE
 - 05. 160 00 TERRACE RAIN WATER PIPE
 - 06. 160 00 TERRACE RAIN WATER PIPE
 - 07. 160 00 TERRACE RAIN WATER PIPE
 - 08. 160 00 TERRACE RAIN WATER PIPE
 - 09. 160 00 TERRACE RAIN WATER PIPE
 - 10. 160 00 TERRACE RAIN WATER PIPE
 - 11. 110 00 BASEMENT DRAIN PIPE

NOTE: - ALL OPENABLE WINDOW / PANEL (1000X1000) ARE PROVIDED AT 10.0M DISTANCE

TYPICAL FLOOR (Ref. to 10th, 12th, 14th, 16th to 18th) (BLOCK-D)