

This is a "PROVISIONAL BUILDING PLAN" approved only for the purpose of filing applications from the general public.

(Signatures and stamps)


Architect: *(Signature)*
 Hafeez Contractor
 29 Boka Street, Boka 00 023, New Delhi-110070

Contractor: *(Signature)*
 DLF Cyber City Developers Ltd.
 10th Floor DLF Gateway Tower,
 DLF Cyber City, Gurugram, Haryana
 Pin: 122002


Scale: 1:100
 Date: 24-04-2021

Project: RMS ARCHITECTS PVT. LTD.
 69 Nara Niwas Bhawani Kunj
 (Behind D2), Vasant Kunj,
 New Delhi-110070.
 Tel.: 011-26888616, 26888617
 www.fsms-arch.com

KEY PLAN

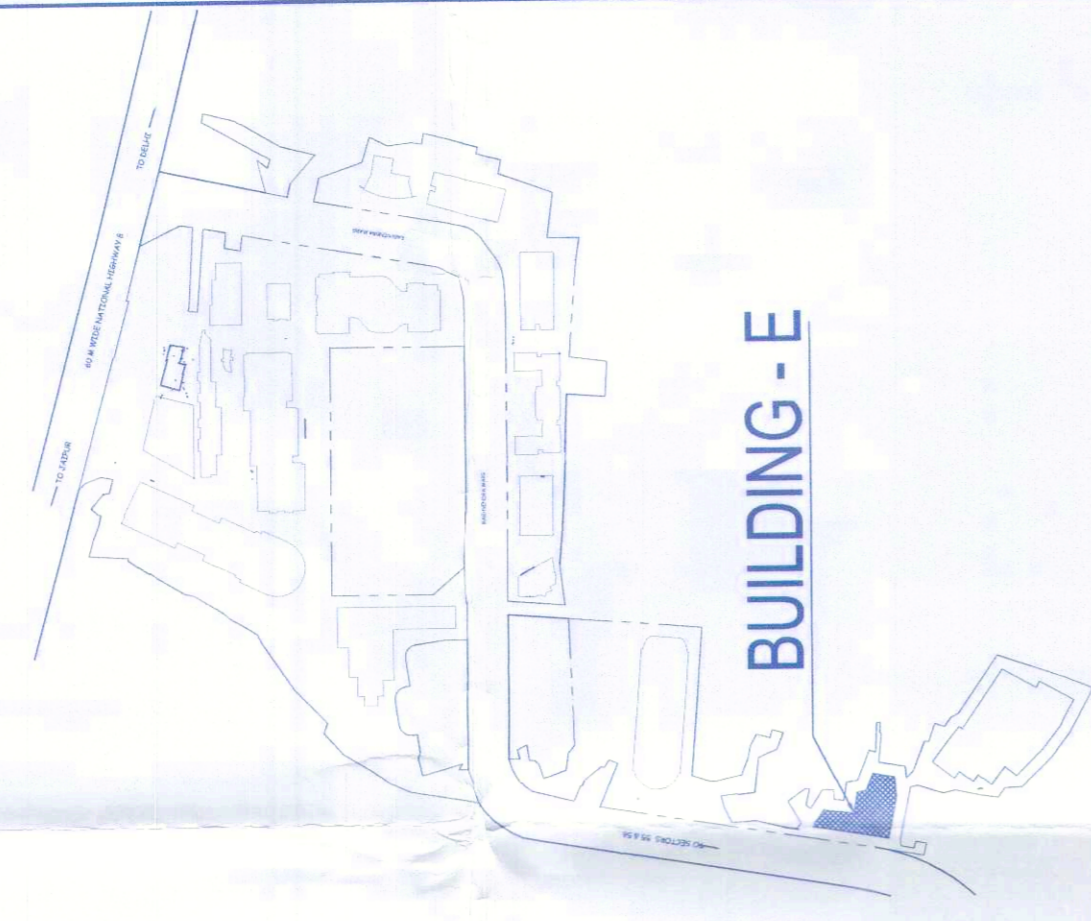

Architect
Hafeez Contractor
 29 Boka Street, Boka 00 023, New Delhi-110070

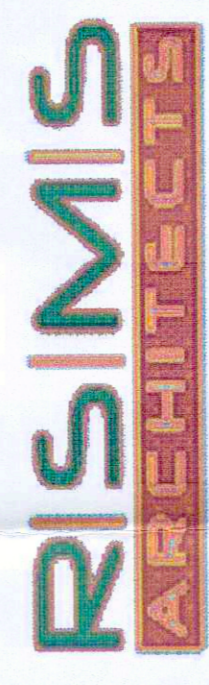

RMS ARCHITECTS PVT. LTD.
 69 Nara Niwas Bhawani Kunj
 (Behind D2), Vasant Kunj,
 New Delhi-110070.
 Tel.: 011-26888616, 26888617
 www.fsms-arch.com



Project: PROPOSED BUILDING PLANS OF BUILDING - B AND REVISED BUILDING PLANS OF BUILDING - C, D, E, & F IN CYBER CITY UNDER TRANSIT ORIENTED DEVELOPMENT (TOD) POLICY FOR MIX LAND USED COLONY 70% IT/ITES (+30% COMMERCIAL) MEASURING 108.55922 ACRES IN SECTOR 24, 25 & 25-A, GURUGRAM, MANESAR URBAN COMPLEX BEING DEVELOPED BY DLF CYBER CITY DEVELOPERS LIMITED

OWNER: DLF Cyber City Developers Ltd.
 10th Floor DLF Gateway Tower,
 DLF Cyber City, Gurugram, Haryana
 Pin: 122002


DRAWING TITLE -

ROOF PLAN BLOCK-E

REVISION	JOB NO. -	DRG NO. -	NORTH -
FILE -	SCALE: 1:100	DATE: 24-04-2021	APPROVED BY: <i>(Signature)</i>
DEALT BY: -	CHECKED BY: -	OWNERS SEAL & SIGNATURE	APPROVED BY: <i>(Signature)</i>

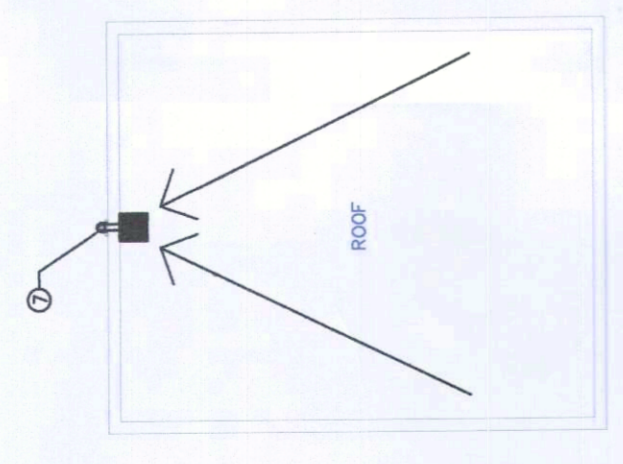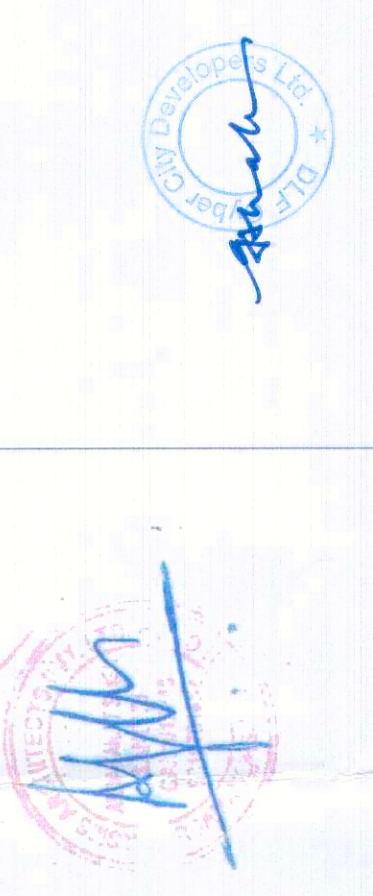

NO.	DESCRIPTION
01	110.00 SLOPE
02	110.00 WATER PIPE
03	110.00 ANTITERRAZZO PIPE
04	110.00 WATER SUPPLY PIPE
05	110.00 WATER SUPPLY PIPE
06	110.00 WATER SUPPLY PIPE
07	110.00 WATER SUPPLY PIPE
08	110.00 WATER SUPPLY PIPE
09	110.00 WATER SUPPLY PIPE
10	110.00 WATER SUPPLY PIPE
11	110.00 WATER SUPPLY PIPE
12	110.00 WATER SUPPLY PIPE
13	110.00 WATER SUPPLY PIPE
14	110.00 WATER SUPPLY PIPE
15	110.00 WATER SUPPLY PIPE
16	110.00 WATER SUPPLY PIPE
17	110.00 WATER SUPPLY PIPE
18	110.00 WATER SUPPLY PIPE
19	110.00 WATER SUPPLY PIPE
20	110.00 WATER SUPPLY PIPE
21	110.00 WATER SUPPLY PIPE
22	110.00 WATER SUPPLY PIPE
23	110.00 WATER SUPPLY PIPE
24	110.00 WATER SUPPLY PIPE
25	110.00 WATER SUPPLY PIPE
26	110.00 WATER SUPPLY PIPE
27	110.00 WATER SUPPLY PIPE
28	110.00 WATER SUPPLY PIPE
29	110.00 WATER SUPPLY PIPE
30	110.00 WATER SUPPLY PIPE
31	110.00 WATER SUPPLY PIPE
32	110.00 WATER SUPPLY PIPE
33	110.00 WATER SUPPLY PIPE
34	110.00 WATER SUPPLY PIPE
35	110.00 WATER SUPPLY PIPE
36	110.00 WATER SUPPLY PIPE
37	110.00 WATER SUPPLY PIPE
38	110.00 WATER SUPPLY PIPE
39	110.00 WATER SUPPLY PIPE
40	110.00 WATER SUPPLY PIPE
41	110.00 WATER SUPPLY PIPE
42	110.00 WATER SUPPLY PIPE
43	110.00 WATER SUPPLY PIPE
44	110.00 WATER SUPPLY PIPE
45	110.00 WATER SUPPLY PIPE
46	110.00 WATER SUPPLY PIPE
47	110.00 WATER SUPPLY PIPE
48	110.00 WATER SUPPLY PIPE
49	110.00 WATER SUPPLY PIPE
50	110.00 WATER SUPPLY PIPE

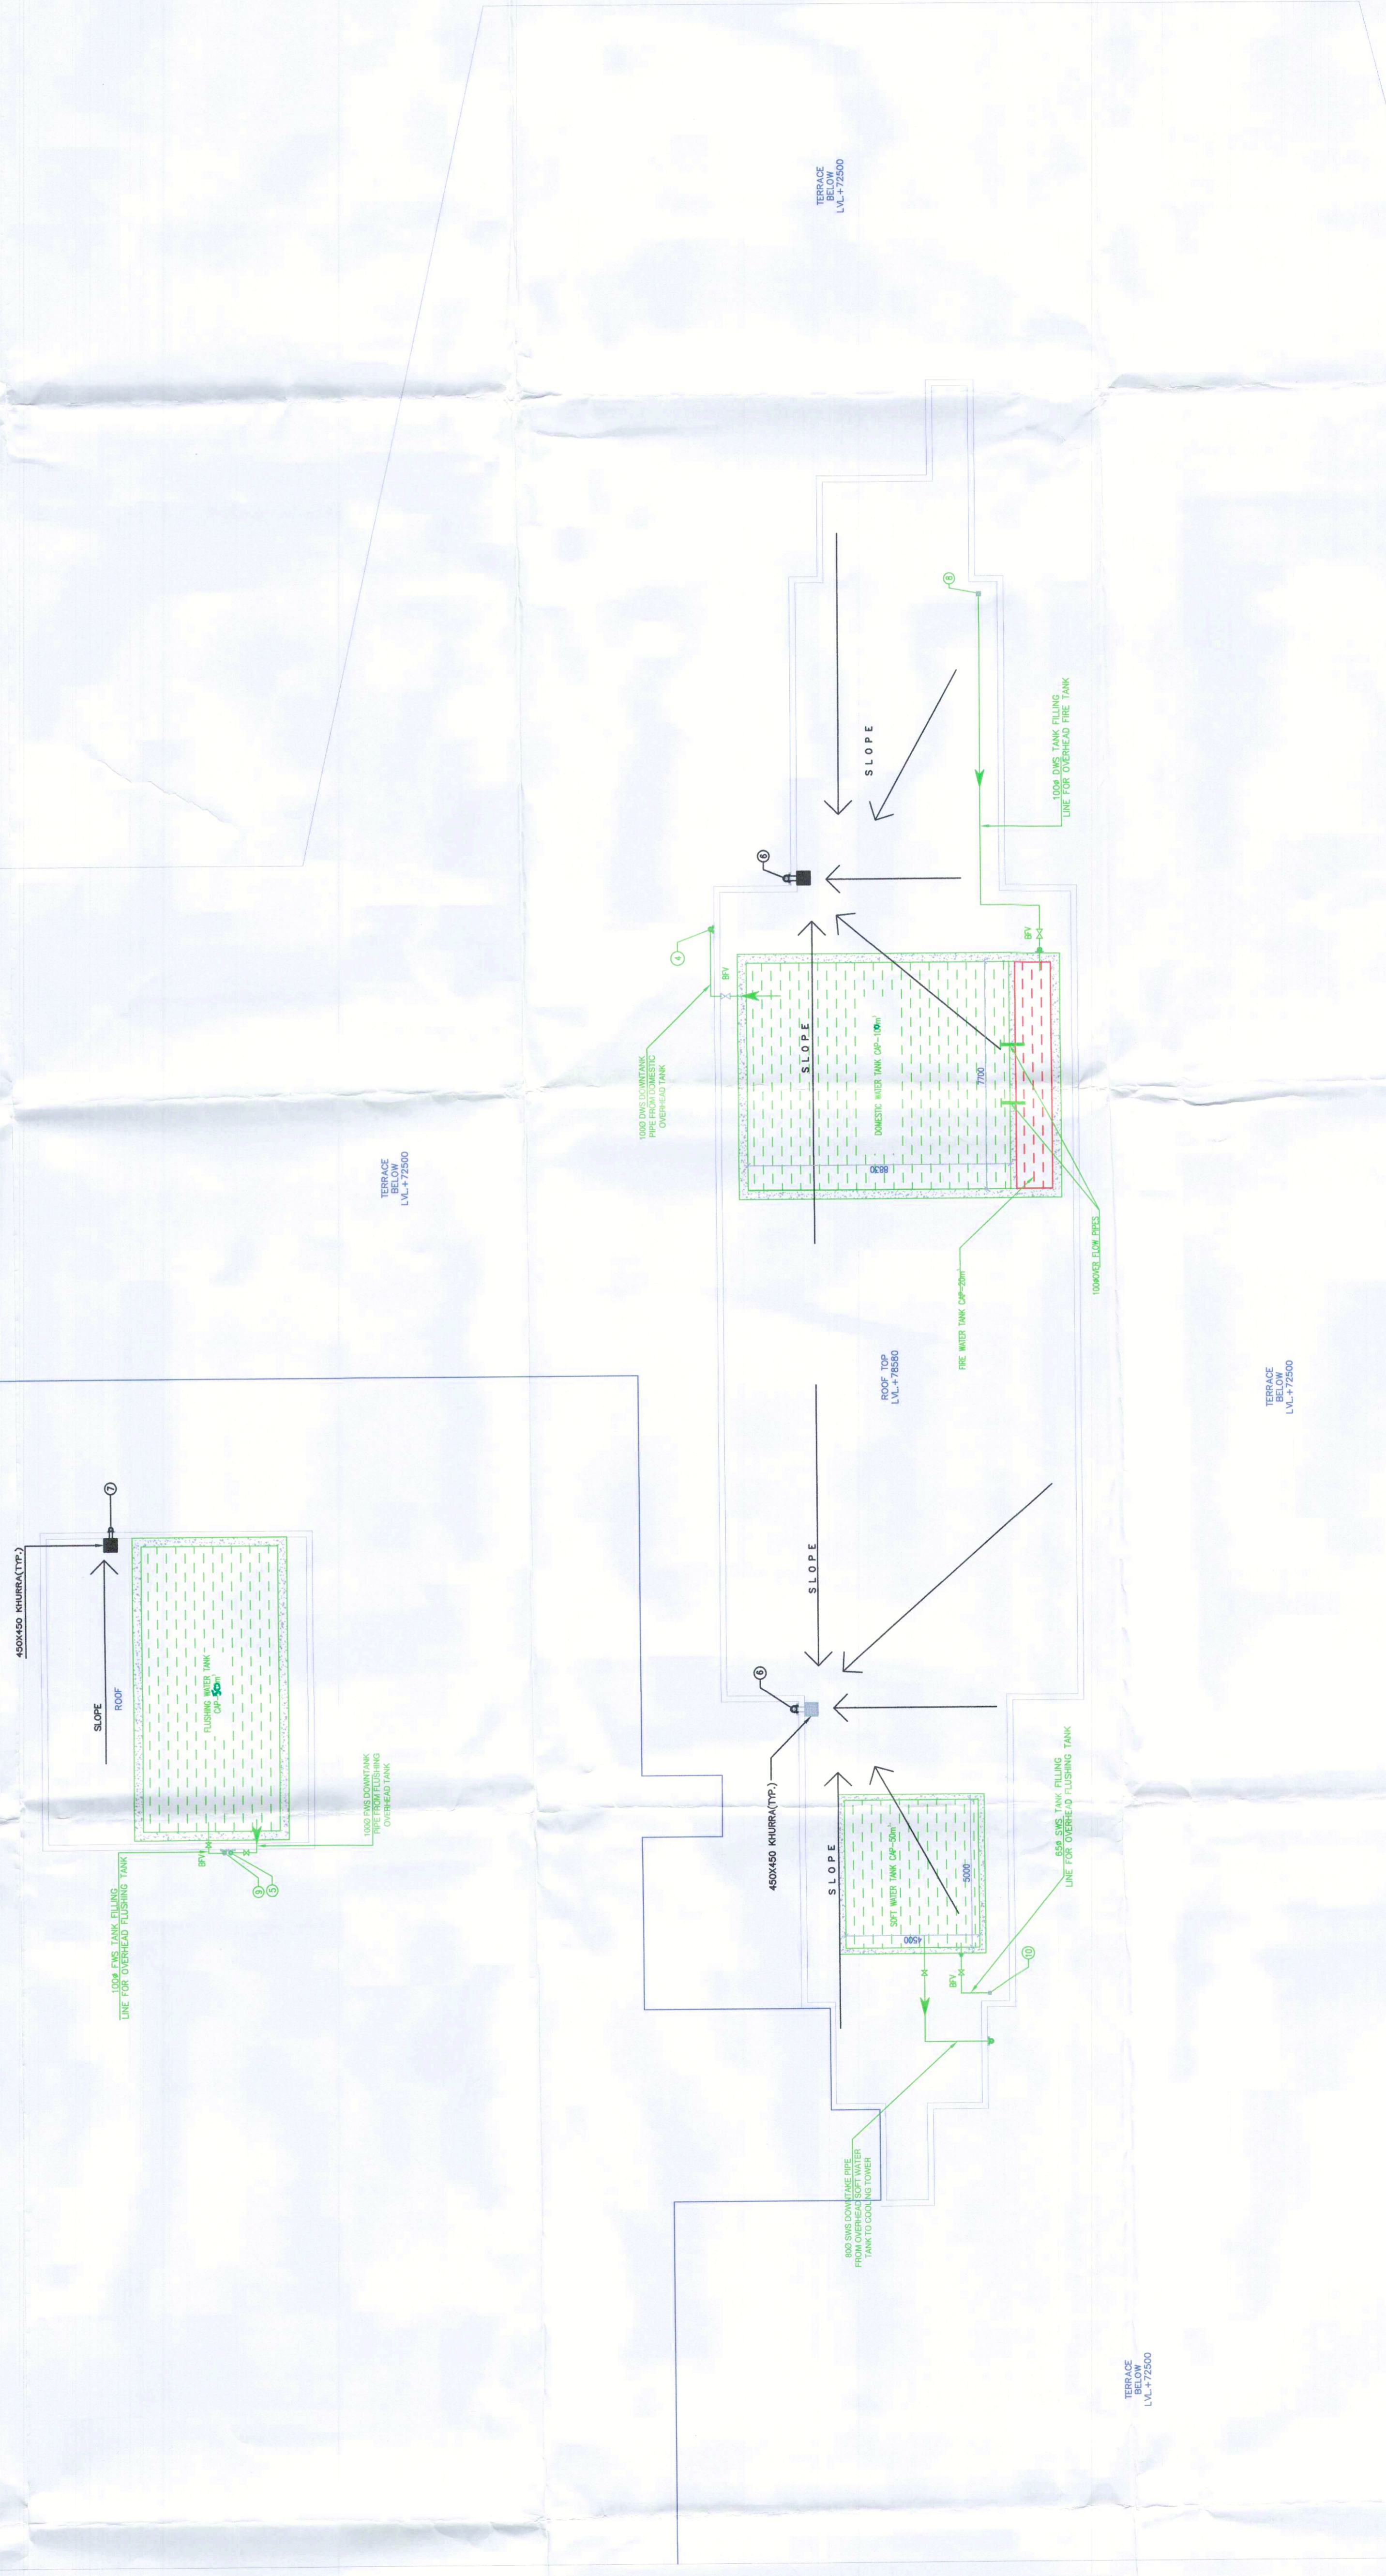

ROOF PLAN BLOCK-E