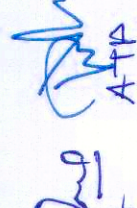


This is a "PROVISIONAL BUILDING PLAN" approved only for the purpose of inviting objections from the general public.


DRG NO.

BF-01

  
 M. Khan  
 Architect (I/O) S.T.P.  
 Registered Architect  
 BPC - BPC  
 Rain Water Harvesting  
 (OPTION)

  
 M. S. P.  
 BPC - BPC

KEY PLAN

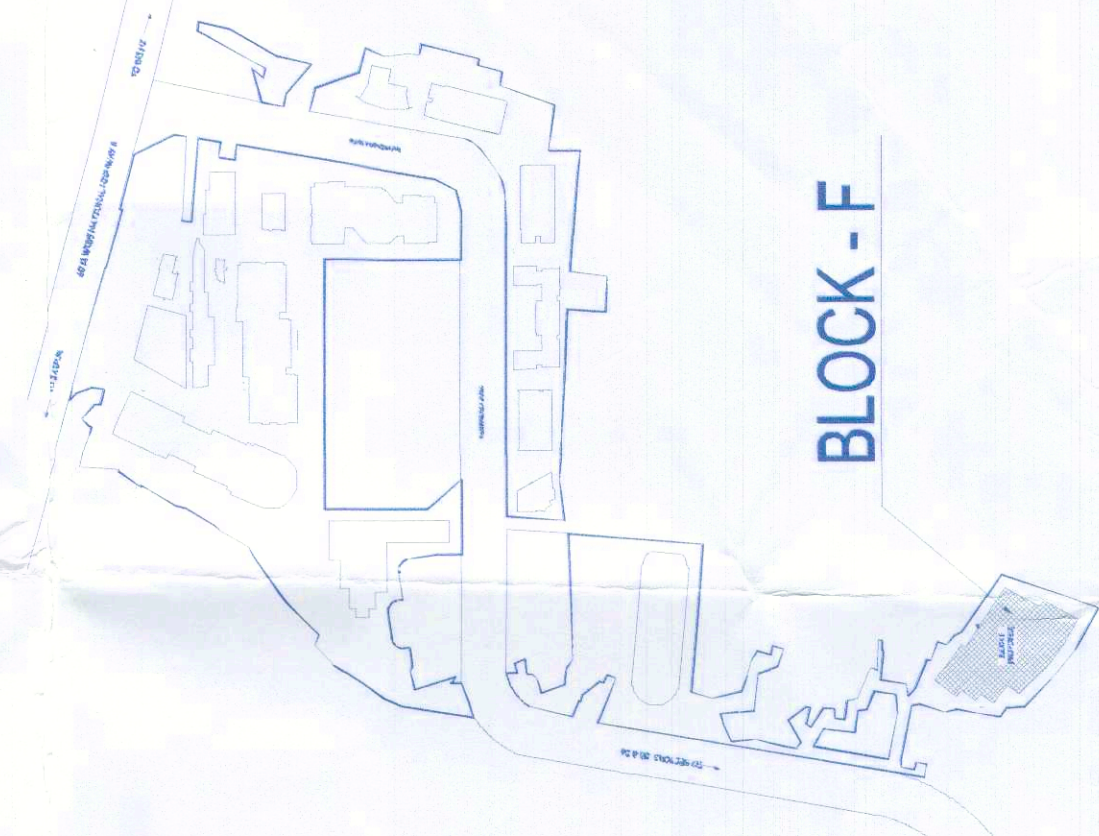

Architect  
**Hafeez**  
 Contractor

**RISIMIS**  
 ARCHITECTS

RMS ARCHITECTS PVT. LTD.  
 69 Hero Noida, Bhawan, Kirti  
 (Behind D2), Vasant Kunj,  
 New Delhi-110070  
 Tel: 011-2689-8116, 26898017  
 www.rms-arch.com

PROJECT: PROPOSED BUILDING PLANS OF BUILDING - D, E & F IN CYBER CITY UNDER TRANSIT ORIENTED DEVELOPMENT (TOD) POLICY FOR N/LAND USED COLONY (C/17/1163/4-30% COMMERCIAL) MEASURING 108.20022 ACRES IN SCHEM 24, 25 & 25-A, GURUGRAM MANESHA, URBAN COMPLEX BEING DEVELOPED BY DLF CYBER CITY DEVELOPERS LIMITED



OWNER: DLF Cyber City Developers Ltd  
 11th Floor DLF Gateway Tower,  
 DLF Cyber City, Gurugram, Haryana  
 Pin: 122002


DRAWING TITLE:

GROUND FLOOR PLAN  
BLOCK-F

REVISION:   
 DATE: 12-04-2021  
 SCALE: 1:200

FILE NO: 12-04-2021  
 PREPARED BY: ARCH-02  
 CHECKED BY: ARCH-02  
 ARCHITECT'S SEAL & SIGNATURE: 

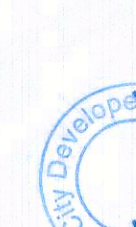APPROVED BY:   
 ARCHITECT'S SEAL & SIGNATURE: 

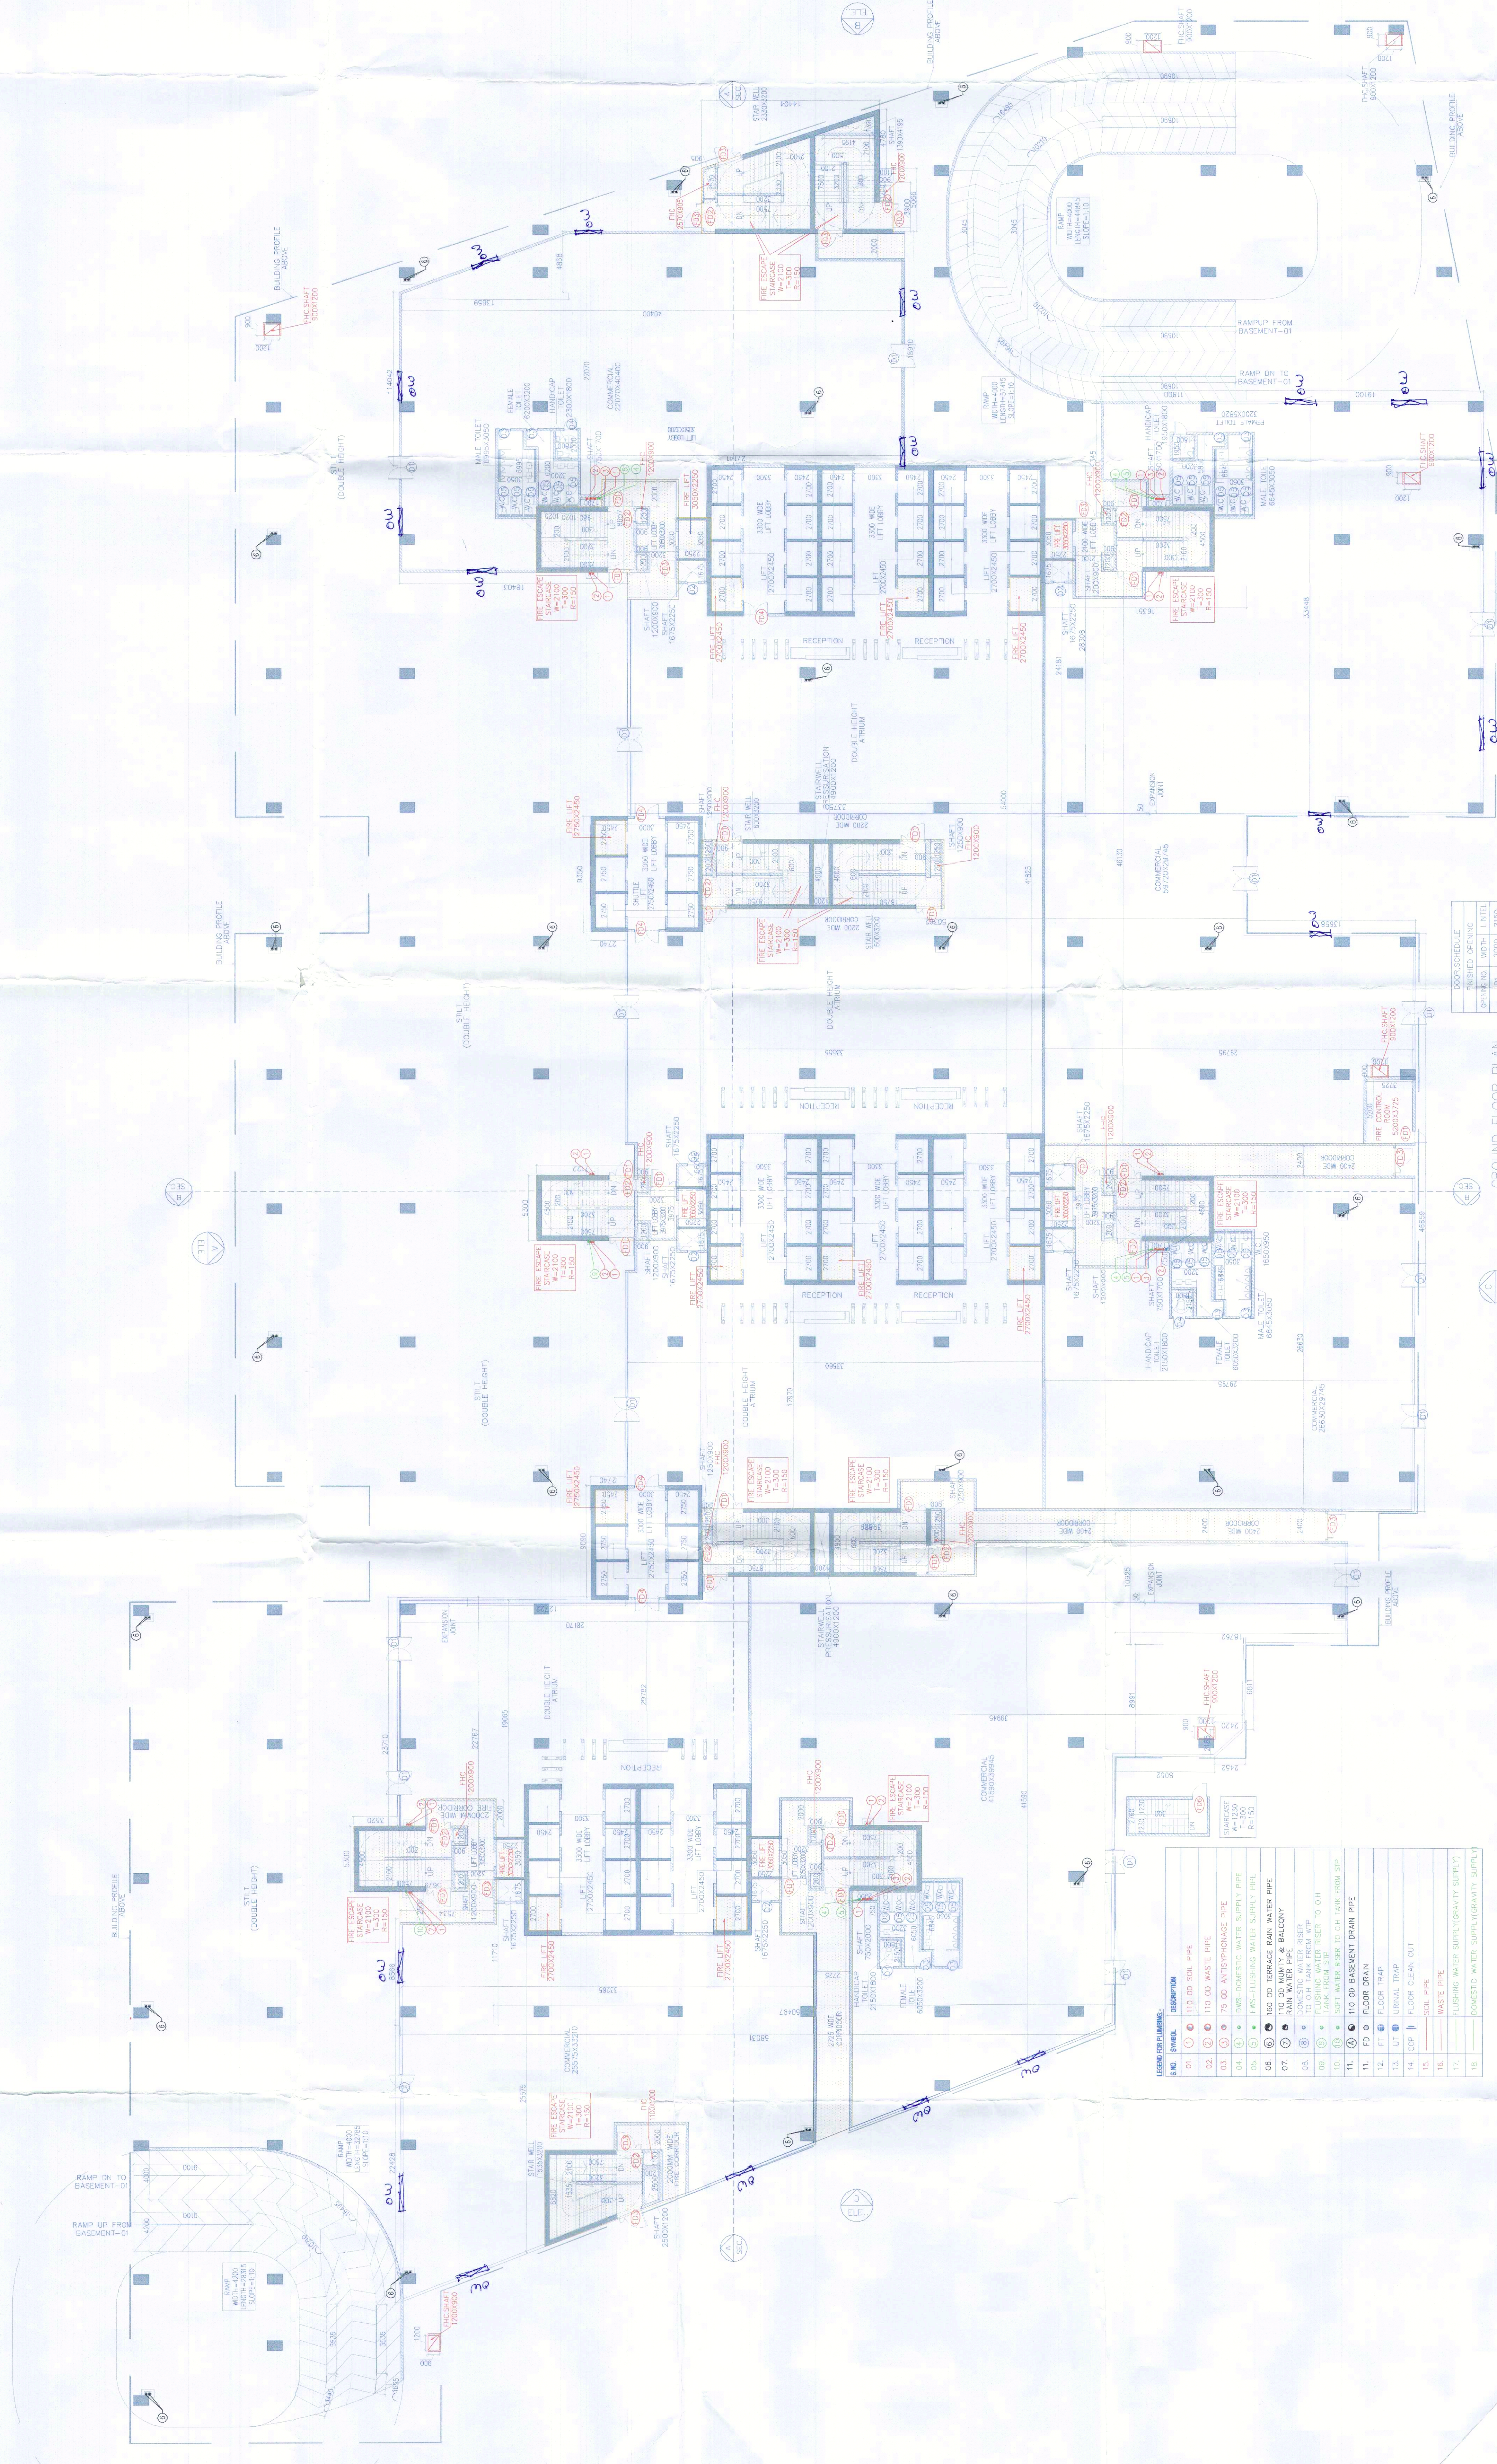

ROOM SCHEDULE	NO.	AREA (SQ. METERS)	TOTAL AREA (SQ. METERS)
RECEPTION	01	100.00	100.00
OFFICE	02	100.00	200.00
CONFERENCE	03	100.00	300.00
RESTROOM	04	100.00	400.00
STAFF	05	100.00	500.00
STAIR	06	100.00	600.00
ELEVATOR	07	100.00	700.00
UTILITY	08	100.00	800.00
MECHANICAL	09	100.00	900.00
WATER TREATMENT	10	100.00	1000.00
WATER STORAGE	11	100.00	1100.00
WATER SUPPLY	12	100.00	1200.00
WATER DISTRIBUTION	13	100.00	1300.00
WATER TREATMENT	14	100.00	1400.00
WATER STORAGE	15	100.00	1500.00
WATER SUPPLY	16	100.00	1600.00
WATER DISTRIBUTION	17	100.00	1700.00
WATER TREATMENT	18	100.00	1800.00
WATER STORAGE	19	100.00	1900.00
WATER SUPPLY	20	100.00	2000.00
WATER DISTRIBUTION	21	100.00	2100.00
WATER TREATMENT	22	100.00	2200.00
WATER STORAGE	23	100.00	2300.00
WATER SUPPLY	24	100.00	2400.00
WATER DISTRIBUTION	25	100.00	2500.00
WATER TREATMENT	26	100.00	2600.00
WATER STORAGE	27	100.00	2700.00
WATER SUPPLY	28	100.00	2800.00
WATER DISTRIBUTION	29	100.00	2900.00
WATER TREATMENT	30	100.00	3000.00

GROUND FLOOR PLAN (COMMERCIAL) (BLOCK-F)

NOTE - OPENABLE WINDOWS @ 10M C/C DISTANCE

NO.	SYMBOL	DESCRIPTION
01	○	100.00 SQ. METER
02	○	100.00 METER
03	○	100.00 METER
04	○	100.00 METER
05	○	100.00 METER
06	○	100.00 METER
07	○	100.00 METER
08	○	100.00 METER
09	○	100.00 METER
10	○	100.00 METER
11	○	100.00 METER
12	○	100.00 METER
13	○	100.00 METER
14	○	100.00 METER
15	○	100.00 METER
16	○	100.00 METER
17	○	100.00 METER
18	○	100.00 METER
19	○	100.00 METER
20	○	100.00 METER
21	○	100.00 METER
22	○	100.00 METER
23	○	100.00 METER
24	○	100.00 METER
25	○	100.00 METER
26	○	100.00 METER
27	○	100.00 METER
28	○	100.00 METER
29	○	100.00 METER
30	○	100.00 METER